


DOOR TYPES

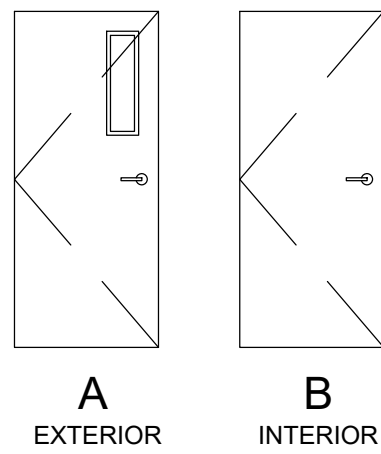

DOOR SCHEDULE

DOOR SCHEDULE												
TAG	ROOM	NOMINAL WIDTH	NOMINAL HEIGHT	TYPE	HAND	FRAME MATERIAL	DOOR SLAB	SLAB THICKNESS	DOOR CORE	DOOR FINISH	HARDWARE GROUP	REMARKS
D105	CLASSROOM 105	3'-0"	8'-0"	A	LHR	EXIST	MTL	1.75	SOLID	PT	A	SLAB ONLY- GLAZED, REUSED EXISTING FRAME
D115	RESTROOM 115	3'-0"	7'-0"	B	LH	MTL	MTL	1.75	SOLID	PT	B	MATCH EXISTING INTERIOR DOORS

HARDWARE SCHEDULE			
GROUP A			
3 ea.	Hinge	TBD	ME
1 ea.	Exit Device	TBD	ME
1 ea.	Closer	TBD	ME
1 ea.	Threshold	TBD	ME
1 ea.	Kickplate	TBD	ME
GROUP B			
3 ea.	Hinge	TBD	ME
1 ea.	Interconnected Lock	TBD	ME
1 ea.	Closer	TBD	ME
1 ea.	Wall Stop	TBD	ME
1 ea.	Kickplate	TBD	ME

WINDOW SCHEDULE

WINDOW SCHEDULE													
ROOM			WALL				WINDOW						
ROOM	ROOM NAME	WALL	WIND. #	QUAN.	R.O. WIND.	# O. HEIGHT	TYPE	OPERATION	FRAME COMPOSITION	FINISH	GLAZING	MANUFACTURER	MODEL
105	CLASSROOM	N	1	1	4'-0"	3'-11"	MATCH EXISTING	STAT	MATCH EXIST.	MATCH EXIST.	8"PF INSUL. W/ LOW-E COATING	TBD	TBD
105	CLASSROOM	N	2	1	4'-0"	3'-11"	MATCH EXISTING	STAT	MATCH EXIST.	MATCH EXIST.	8"PF INSUL. W/ LOW-E COATING	TBD	TBD

FINISH SCHEDULE


TAG	TYPE	LOCATION(S)	MANUF. / VENDOR	COLOR / DESCRIPTION / ID	TEXTURE / FINISH	NOTES
CPT-1	CARPET		INTERFACE	SR999 Product#: 1388702500 Color: 104026 Midnight		walk-off mat carpet squares for entry's, exits, and hallways
CPT-2	CARPET		INTERFACE	Product#: 1462102500 Color: 102419 Purl Accent		(standard carpet squares for offices)
VB-1	VINYL COVE BASE- 4"		FLEXCO	Color: #03 "Charcoal" Product#: C4SCW1P003		
VB-2	VINYL COVE BASE- 6"		FLEXCO	Color: #03 "Charcoal" Product#: C6SCW1P003	FLAT	
PT-1	PAINT		MILLER PAINT	Color: "Fondant" #E0126	FLAT	
PT-2	PAINT		SHERWIN WILLIAMS	Color: #SW7072 "Online" 235-C2 (Paintable doors and metal trim)	SATIN	
SV-1	SHEET VINYL		MANNINGTON	"Terrace" Color: #18022 "Aluminum"	SATIN	Size: 2 meters (6'-6" width) (in bathrooms and kitchens)
VCT-1	VINYL COMP TILE		ARMSTRONG	#67551 - "Perfect Storm"	EGGSHELL	12"x12"x0.125" (Classrooms)
WC-1	WAINSCOT		WILSONART	Color: #4643-60 "Misted Zephyr" Matte Finish, BA Aluminum		Size: 60" tall (all walls in restrooms specified)
PL-1	PLASTIC LAMINATE	CASEWORK	WILSONART	Color: #4643-60 "Misted Zephyr" Matte Finish	VERTICAL GRADE	
PL-2	PLASTIC LAMINATE	CTOPS / BACKSPLASH	WILSONART	Color: #D62-60 Dove Gray Matte Finish	SURFACE GRADE	
		WINDOW/DOOR FRAMES		MATCH EXISTING		MATCH EXISTING
		DOOR HARDWARE		MATCH EXISTING		MATCH EXISTING
		HINGES / LOCKSETS / KICKPLATES / CLOSERS		MATCH EXISTING		MATCH EXISTING
		THRESHOLDS / WEATHERSTRIPPING ETC...		MATCH EXISTING		MATCH EXISTING

GENERAL NOTES


- 3405.3.17 LOCKING ARRANGEMENTS IN EDUCATIONAL OCCUPANCIES. IN GROUP E OCCUPANCIES, GROUP B EDUCATIONAL OCCUPANCIES AND GROUP I-4 OCCUPANCIES, EGRESS DOORS WITH LOCKING ARRANGEMENTS DESIGNED TO KEEP INTRUDERS FROM ENTERING THE ROOM SHALL COMPLY WITH SECTION 1010.2.8.

KEY NOTES

- DEMO EXISTING DOOR / FRAME.
- REMOVE EXISTING DOOR PANEL.
- CREATE WINDOW OPENING IN EXISTING WALL.
- ()
- ()
- INFILL (E) WALL. FINISH TO MATCH EXISTING.
- CONSTRUCT NEW INTERIOR NON-BEARING PARTITION
- INSTALL NEW METAL DOOR WITH NARROW LITE PER DOOR SCHEDULE.
- INSTALL NEW STRUCTURAL HEADER / WINDOWS- SEE STRUCTURAL DWGS.
- INSTALL NEW CASEWORK.
- INSTALL NEW PLUMBING FIXTURE.

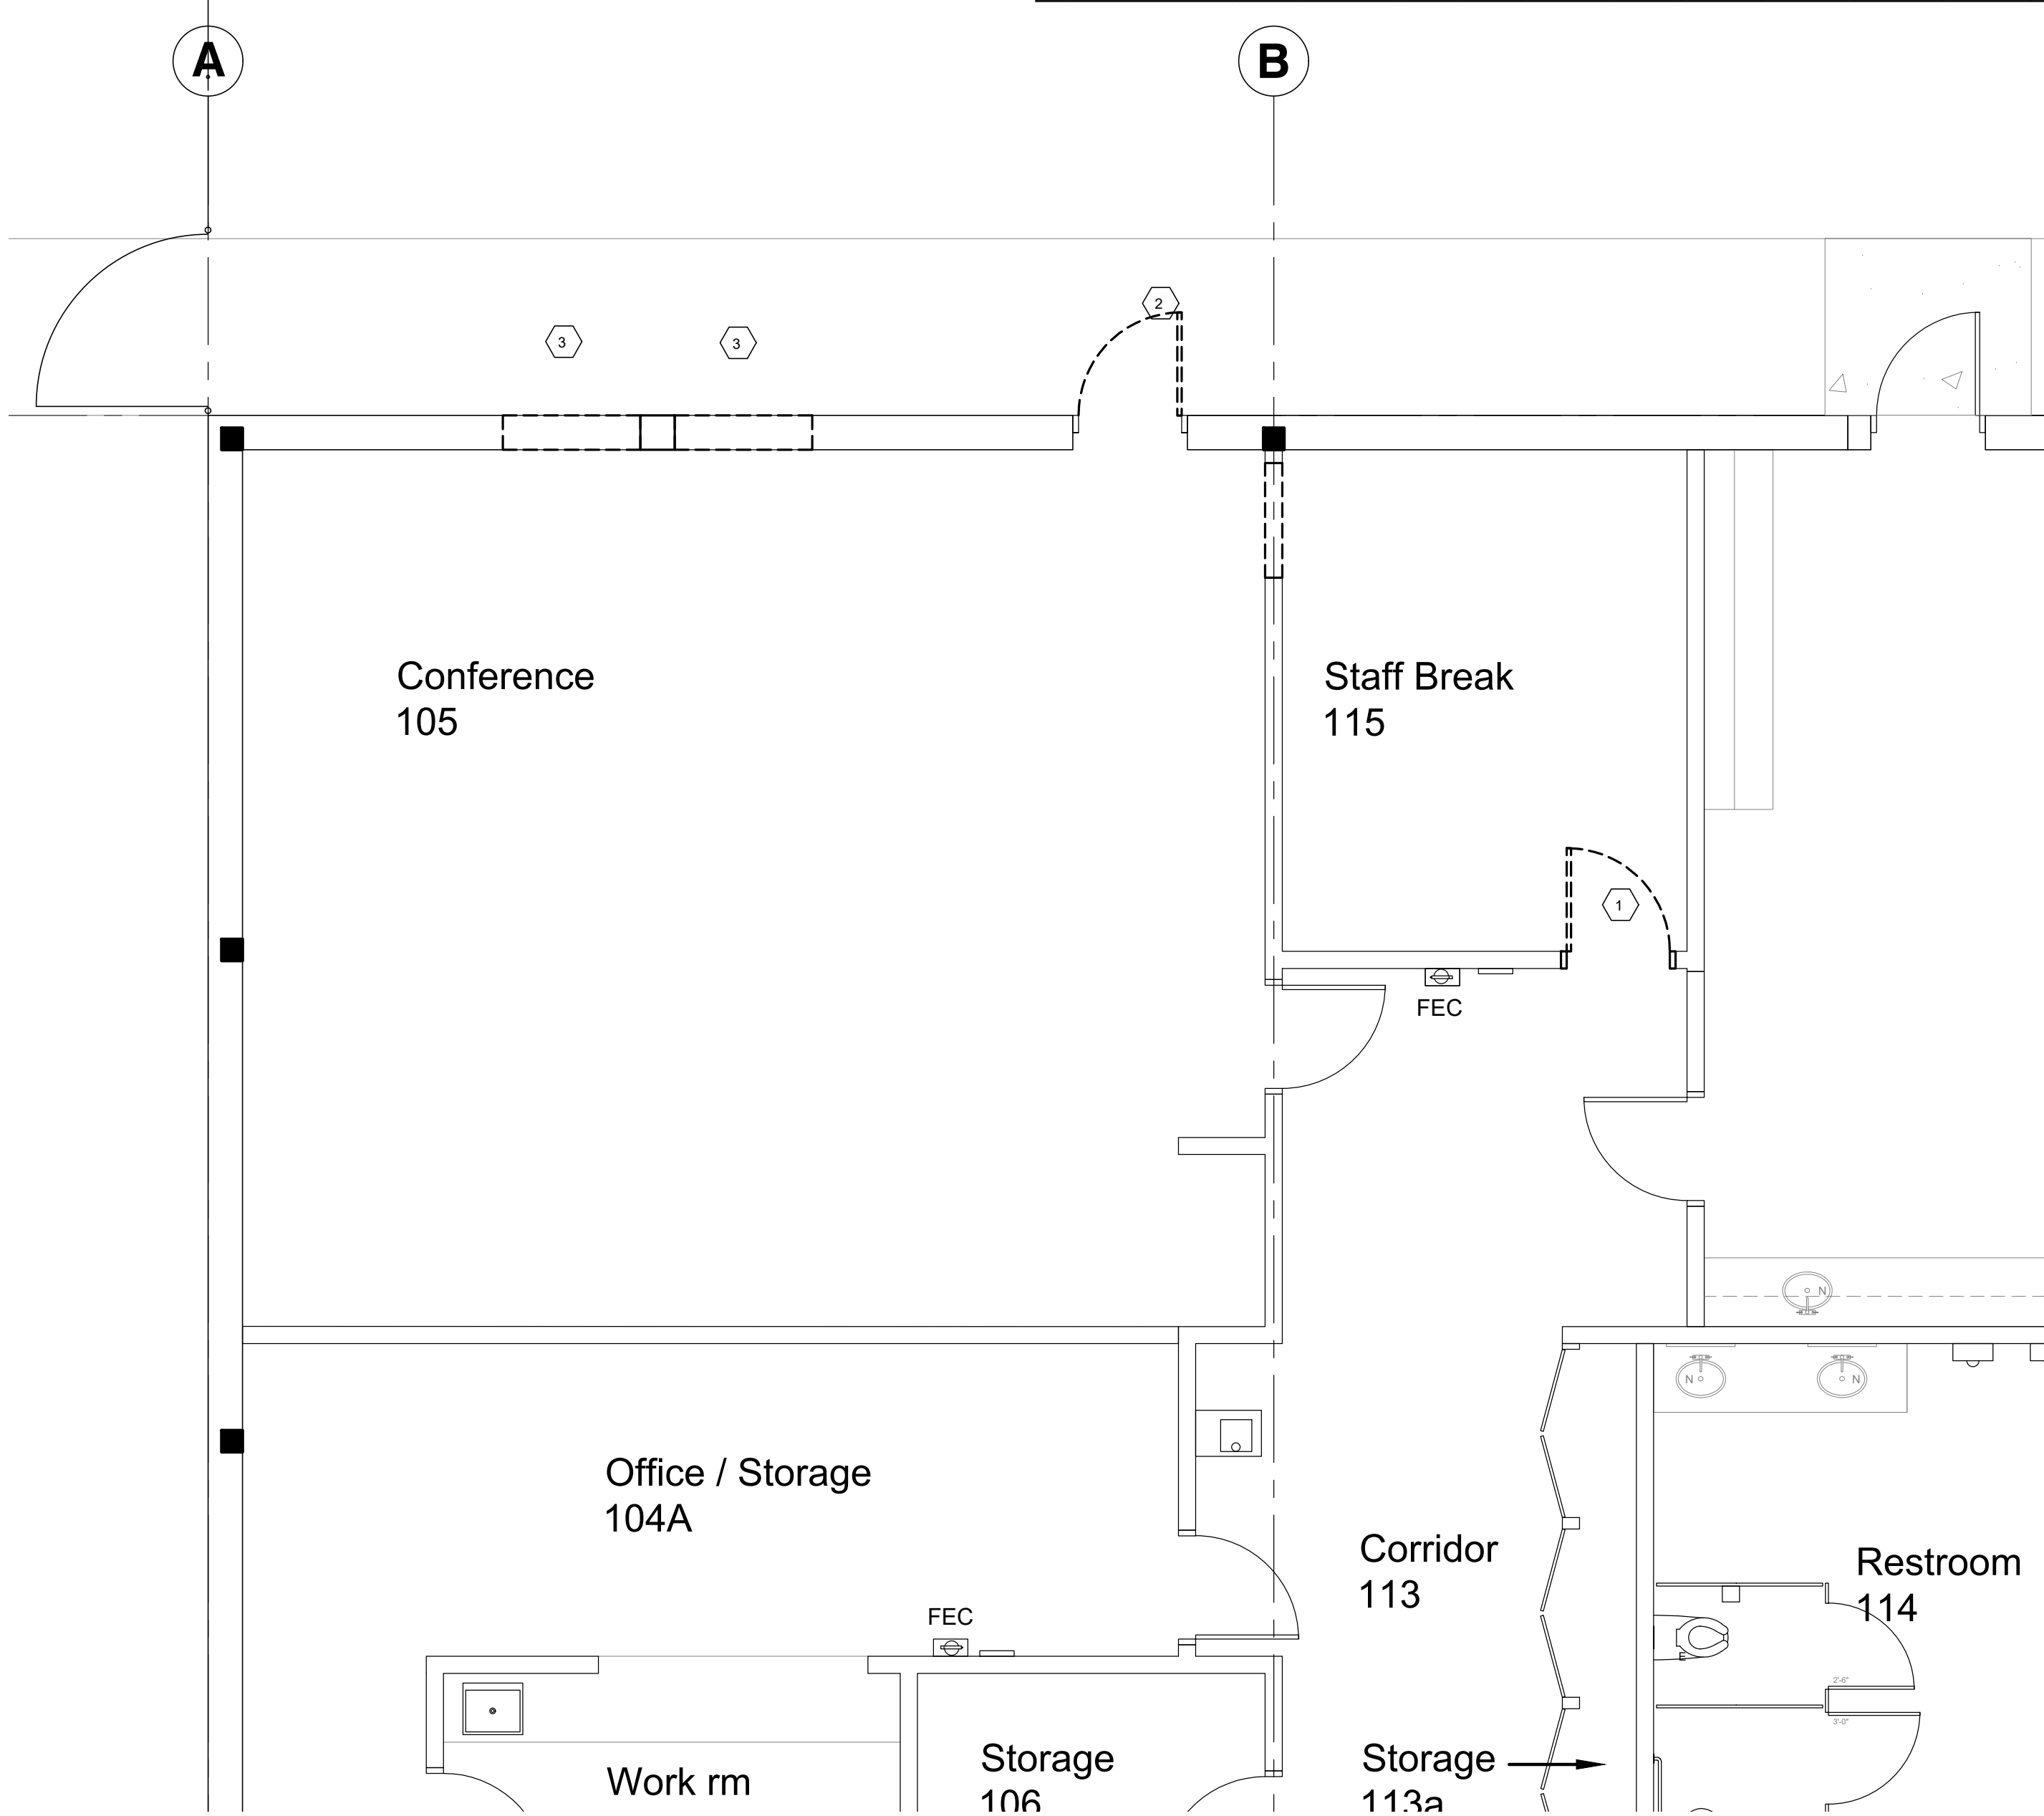

2 DEMO PLAN
A2.40 Scale 1/4"=1'-0"

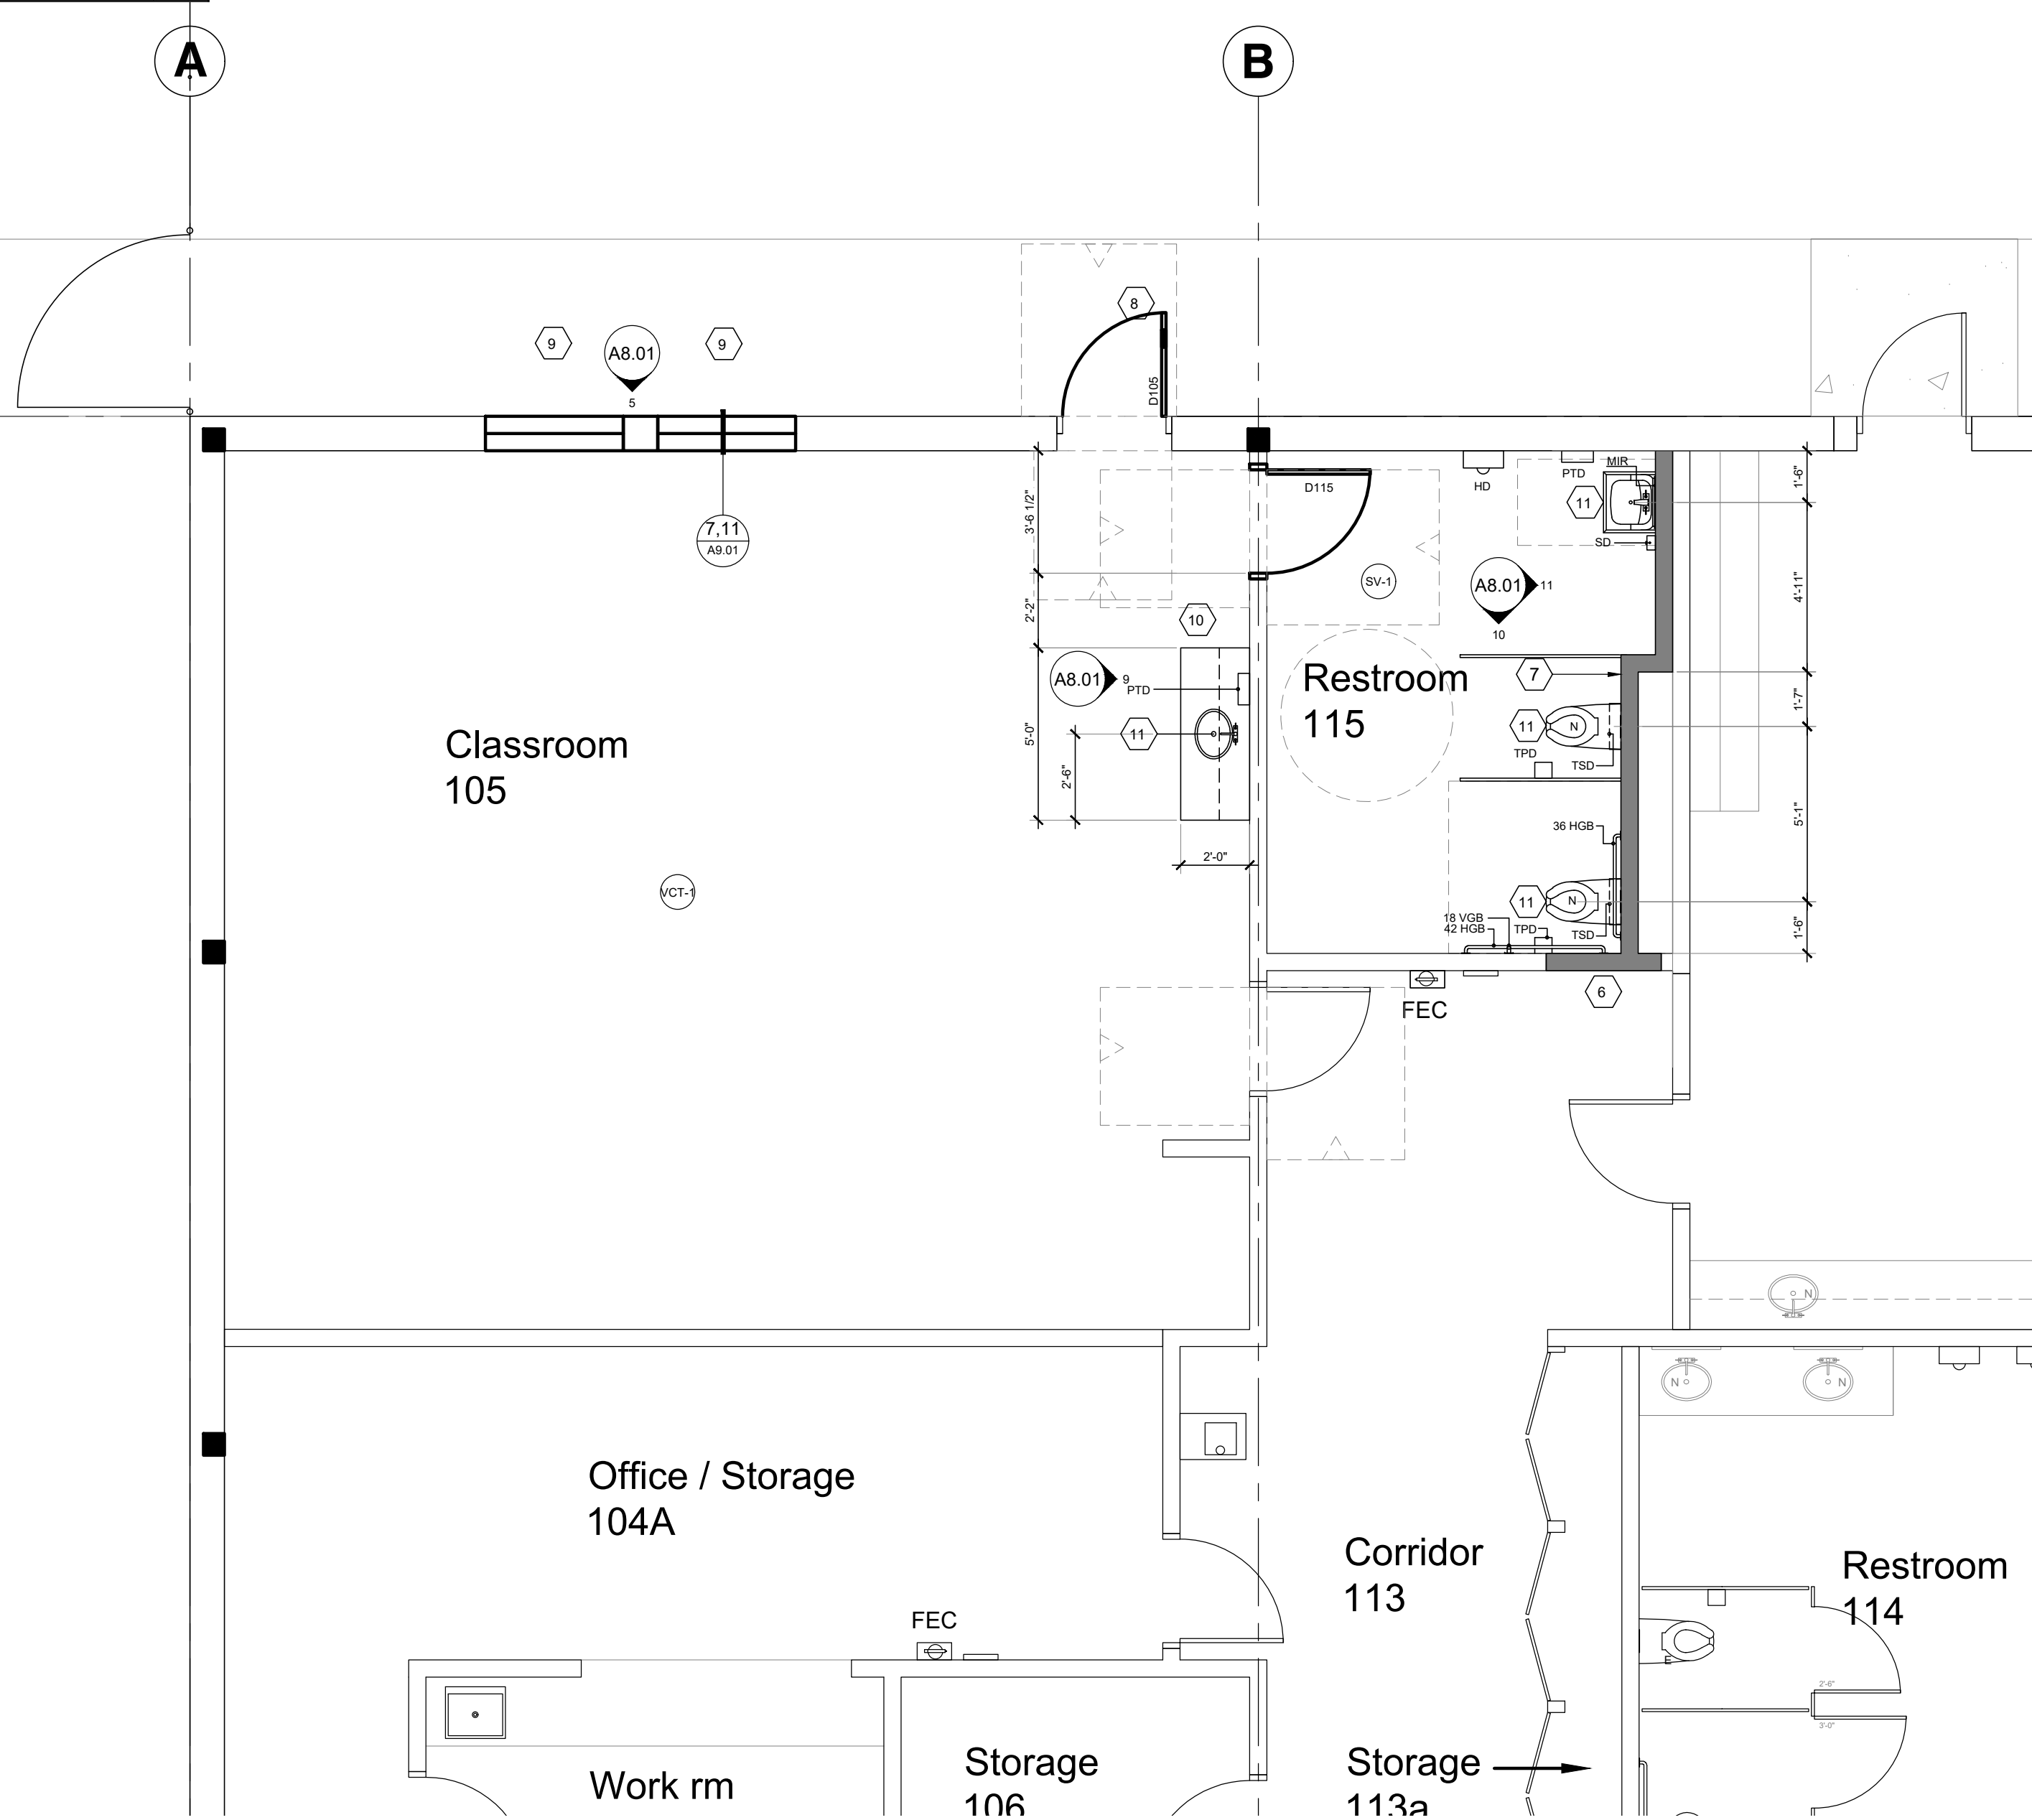

1 FLOOR PLAN
A2.40 Scale 1/4"=1'-0"

REGISTERED
PROJECT
STATE OF WISCONSIN

LEEKA
Architecture and Planning

Creating Positive Impressions in the Built Environment

1001 SE Water Avenue Suite 175
Portland, Oregon 97214
success@leeka.com e-mail
www.leeka.com web

503.644.4222 tel

Copyright © LEKA INC. ALL RIGHTS RESERVED

Revised:
2024-FEB-01
SUBMIT FOR PERMIT

Job No: 2357
Date: Jan. 9, 2024
File Size: 24x36
Permit Application
DRAWN: NYL_SF
CHECKED: NYL
Sheet Title
FLOOR PLAN /
DEMO PLAN
Sheet Number
A2.40

CMI-350735
Educational Service District 112
49th St. Early Learning Center
Tenant Improvement Project: Phase II
14619 NE 49th St. Suite B, Vancouver, WA 98682