

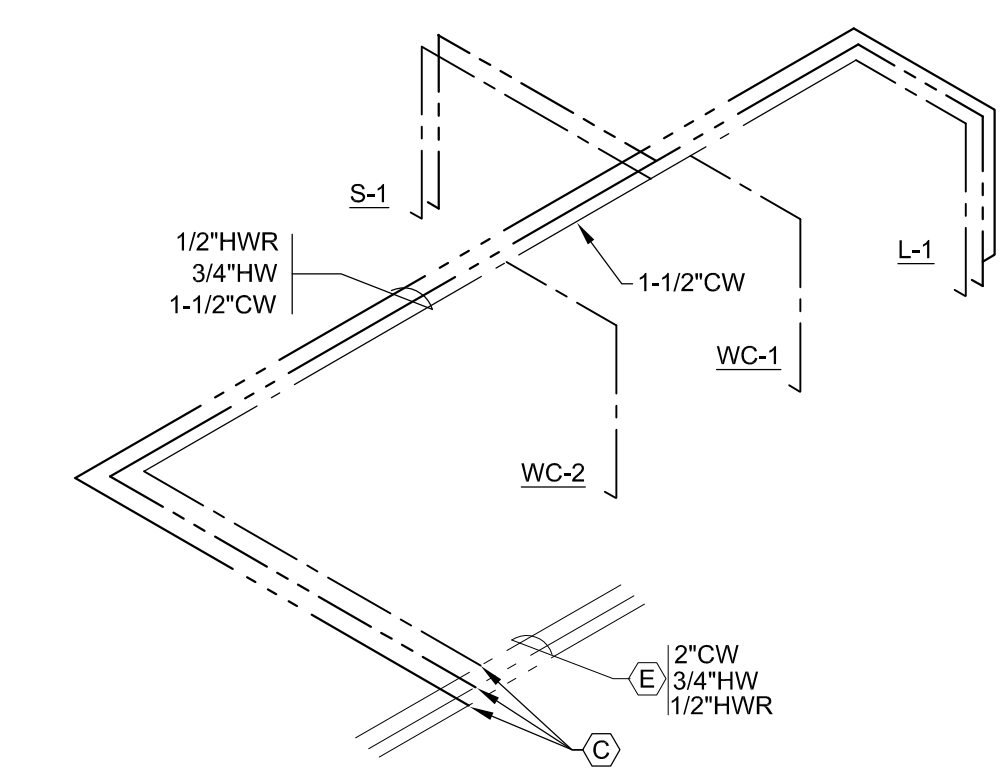


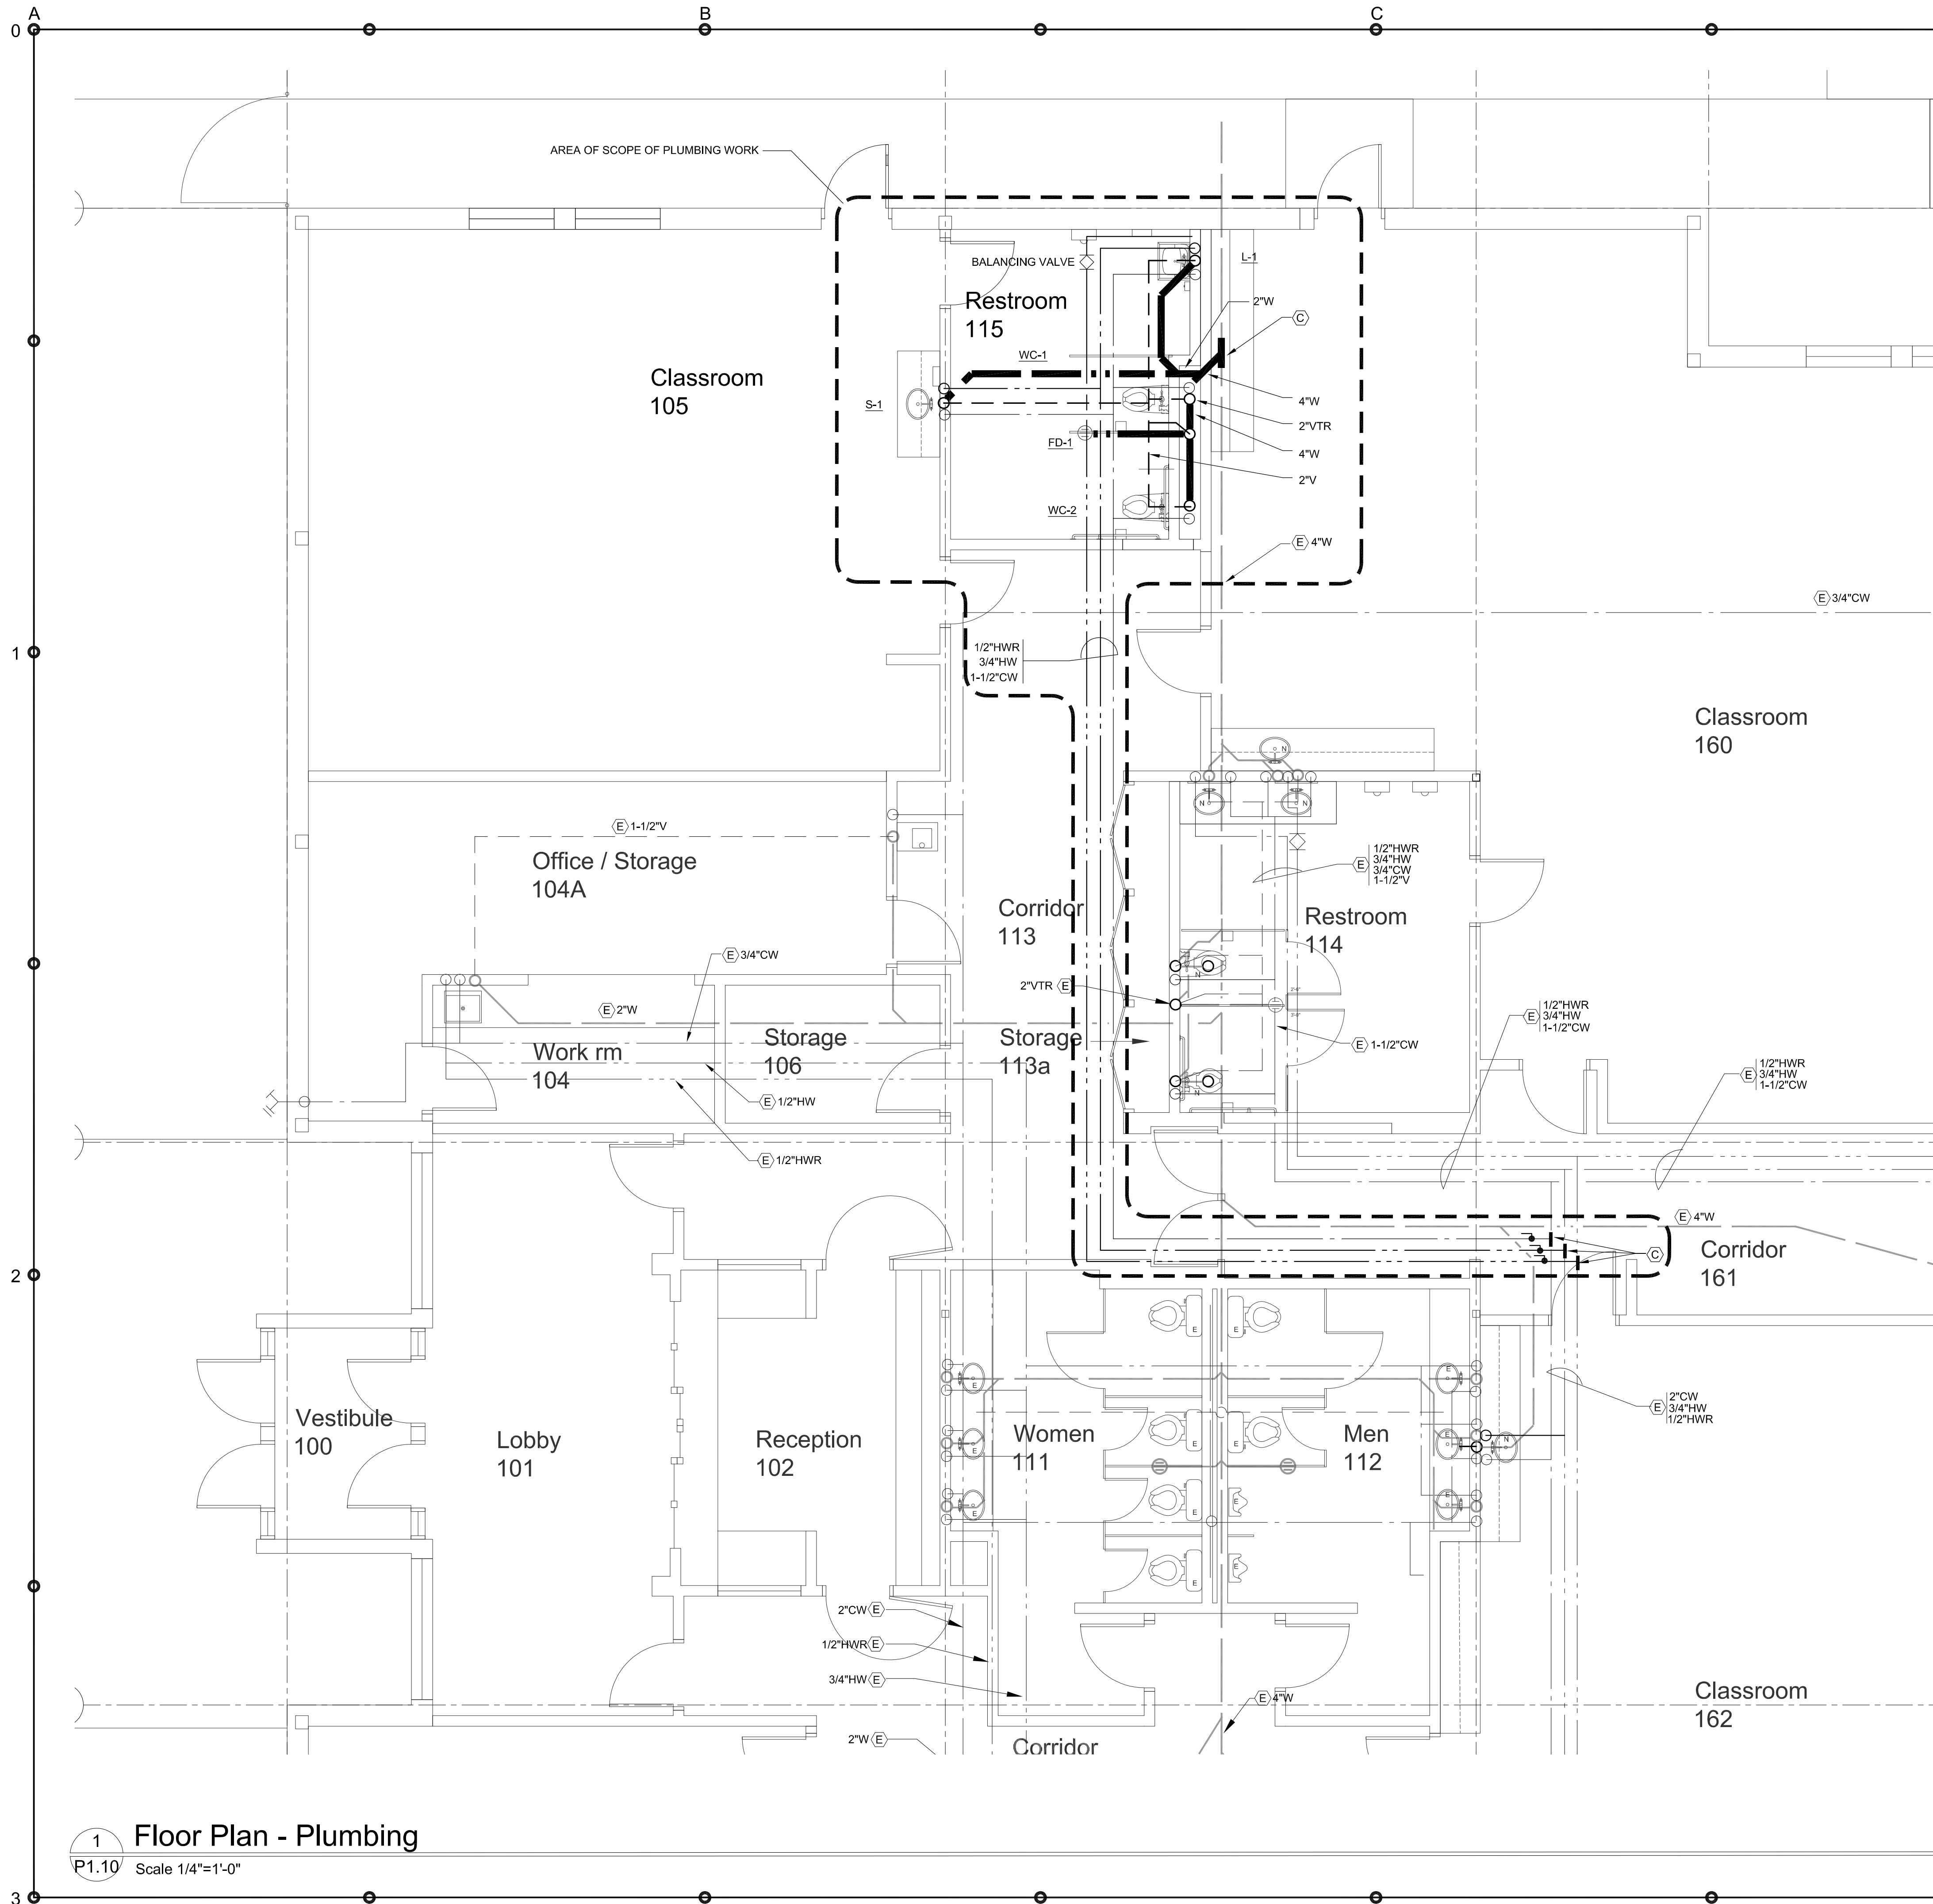


2 WATER DIAGRAM
P1.10 DIAGRAMMATIC

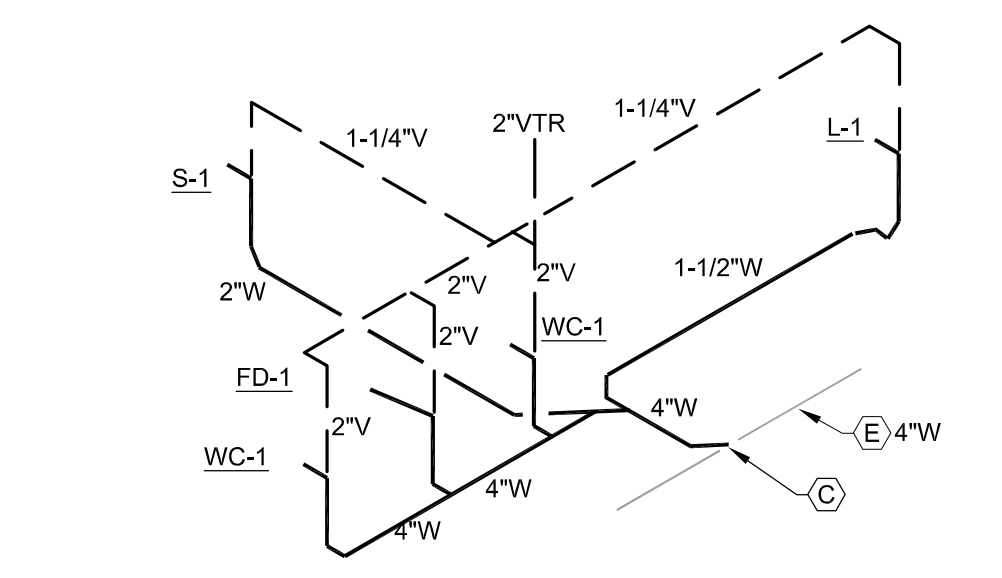

3 WASTE & DIAGRAM
P1.10 DIAGRAMMATIC

1 Floor Plan - Plumbing
P1.10 Scale 1/4"=1'-0"

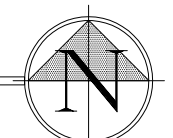

SYSTEM DESIGN CONSULTANTS INC.
333 SE SECOND AVE, SUITE 100
PORTLAND, OREGON 97214
503-248-0227
CONTACT: NEIL BOYER
PROJECT #: LED2017

LEEKA Architecture and Planning
Creating Positive Impressions in the Built Environment
503.644.4222 tel
suec@leeka.com e-mail
www.leekainc.com web

Educational Service District 112
49th St. Early Learning Center
Tenant Improvement Project: Phase II
14619 NE 49th St. Suite B, Vancouver, WA 98682

Revised:	CMI-350735
Job No:	2357
Date:	Jan. 9, 2024
File Size:	24x36
Permit Application	
DRAWN:	NLB
CHECKED:	JDF
Sheet Title	Plumbing Floor Plan
Sheet Number	P1.10