


REVISED
4:00 pm, Oct 06, 2023

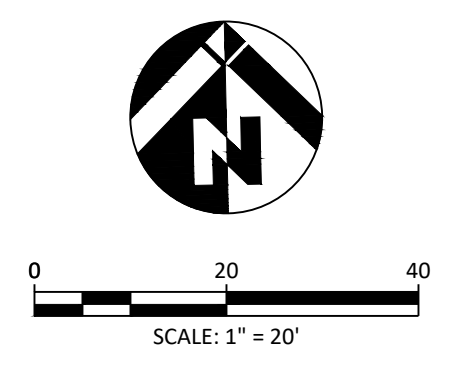


ESD BUILDING 2400
VANCOUVER, WASHINGTON
UTILITY PLAN

REVISIONS:


JOB NO.:	18009
DATE:	4/19/2023
SCALE:	1" = 20'
DESIGNED BY:	PM
DRAWN BY:	PM
CHECKED BY:	DW

FILE: W:\18009 ESD BLDG 2400\500 DESIGN\502 DRAWINGS\SHEETS\C300 UTILITY PLAN.DWG

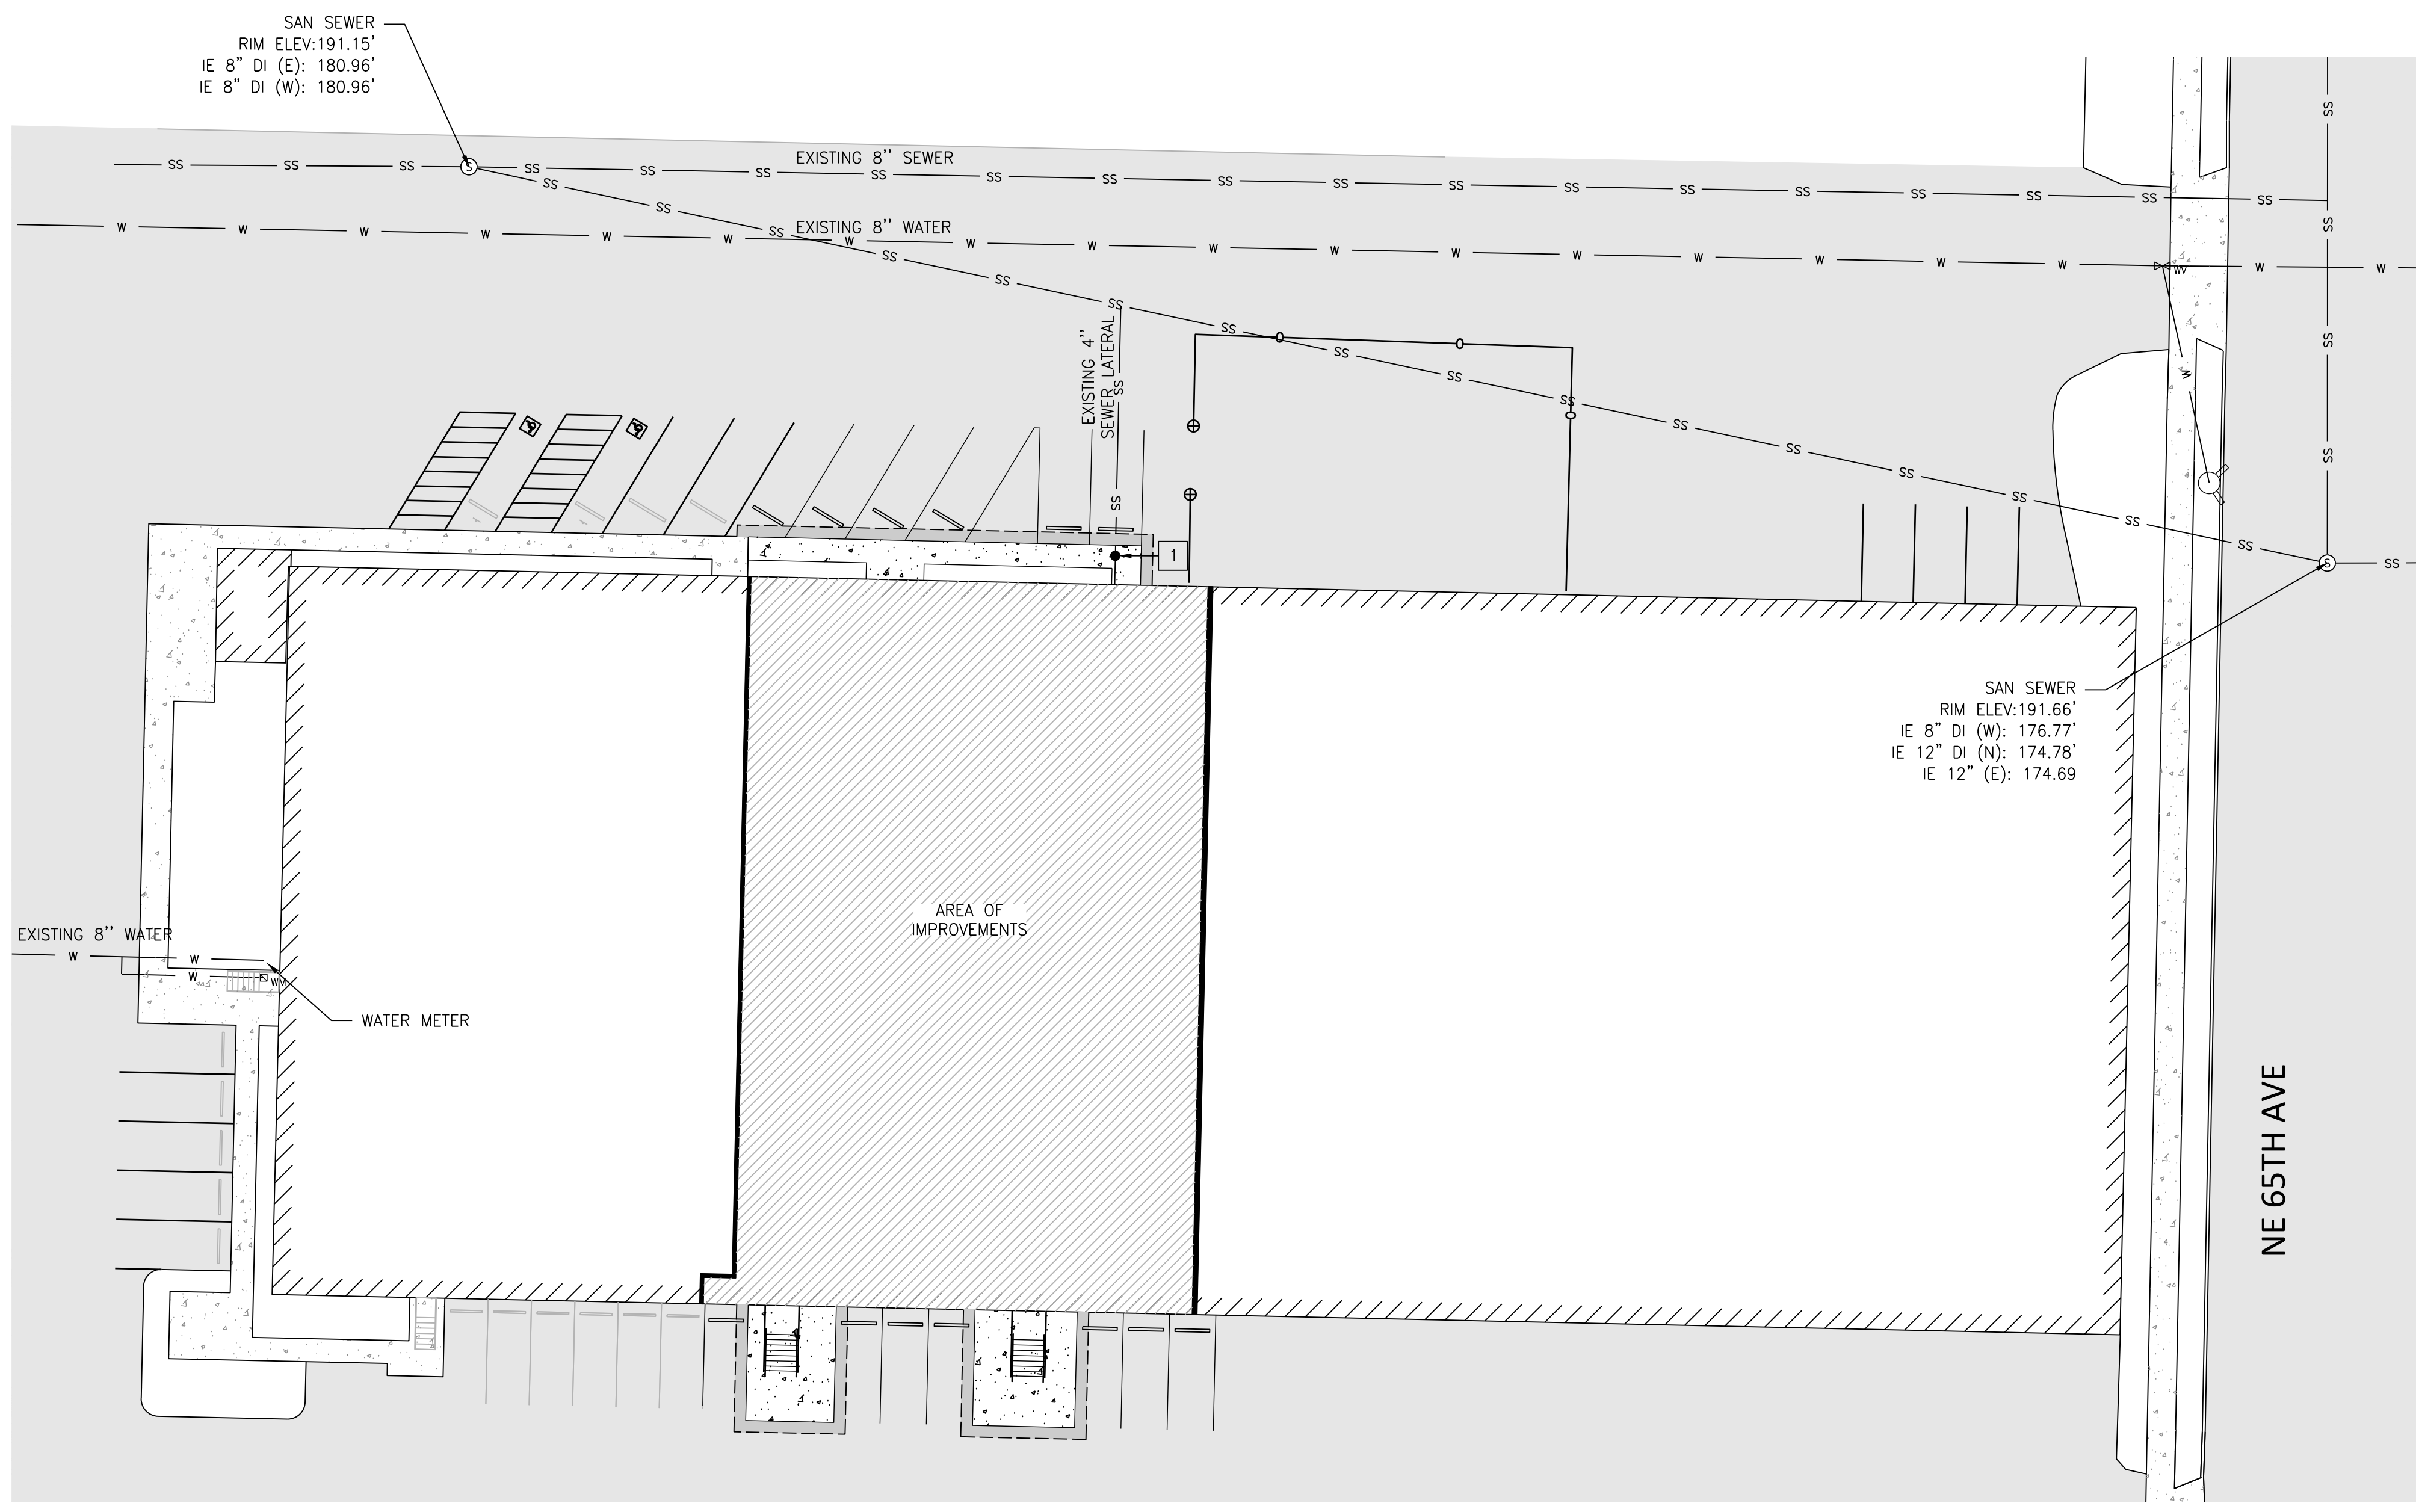

SEWER KEYNOTES

- 1 INSTALL 2-WAY COMMERCIAL SEWER CLEAN OUT PER DETAIL, THIS SHEET
- RIM= 191.05
IE IN/OUT = MATCH EXISTING

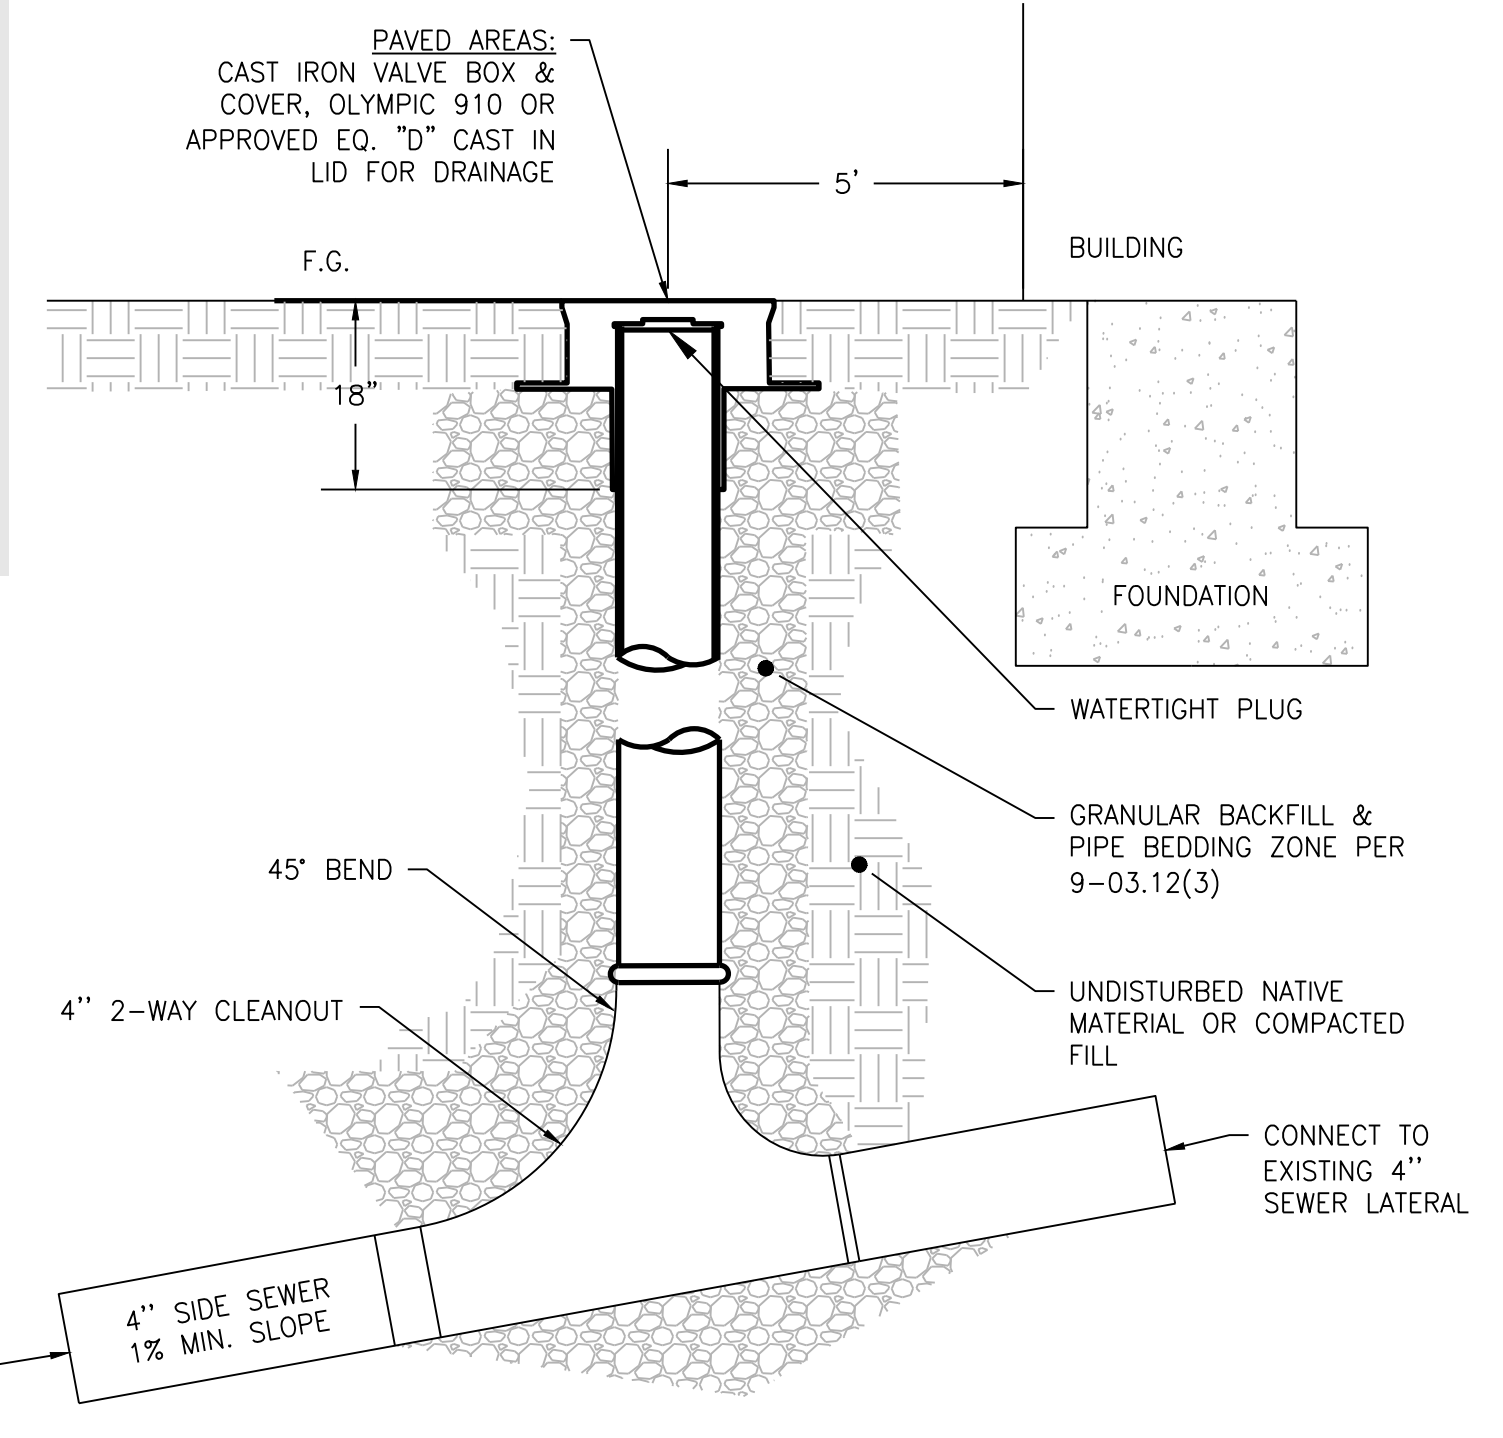

1 2-WAY SEWER CLEANOUT
NO SCALE