


REVISED
4:08 pm, Oct 06, 2023

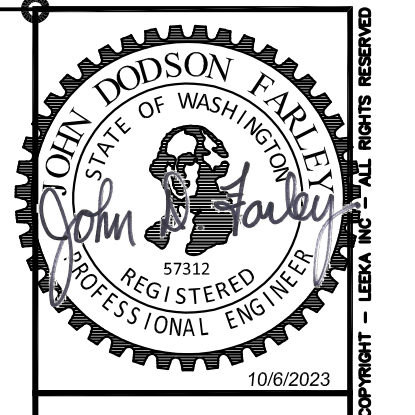


LEEKA Architecture and Planning
Creating Positive Impressions in the Built Environment
503.844.4222 tel
503.844.4222 fax
leeka@leekainc.com e-mail
www.leekainc.com web
1001 SE Water Avenue Suite 175
Portland, Oregon 97214

**Tenant Improvement
ESD112
Mental Health Facility Phase II**
2400 NE 65th Ave. Vancouver, WA.


Revised:	DATE: AUG. 10, 2023
PCR 01	
APPLICANT EDITS	DATE: AUG. 17, 2023
APPLICANT EDITS	DATE: SEPT. 22, 2023
APPLICANT EDITS	DATE: OCT. 03, 2023

Job No:	2246
Date:	February 18, 2023
File Size:	24x36
Progress set	
DRAWN:	NLB
CHECKED:	
Sheet Title	Plumbing Details
Sheet Number	P3.00

SYSTEM DESIGN CONSULTANTS INC.
333 SE SECOND AVE, SUITE 100
PORTLAND, OREGON 97214
503-248-0227
CONTACT: NEIL BOYER

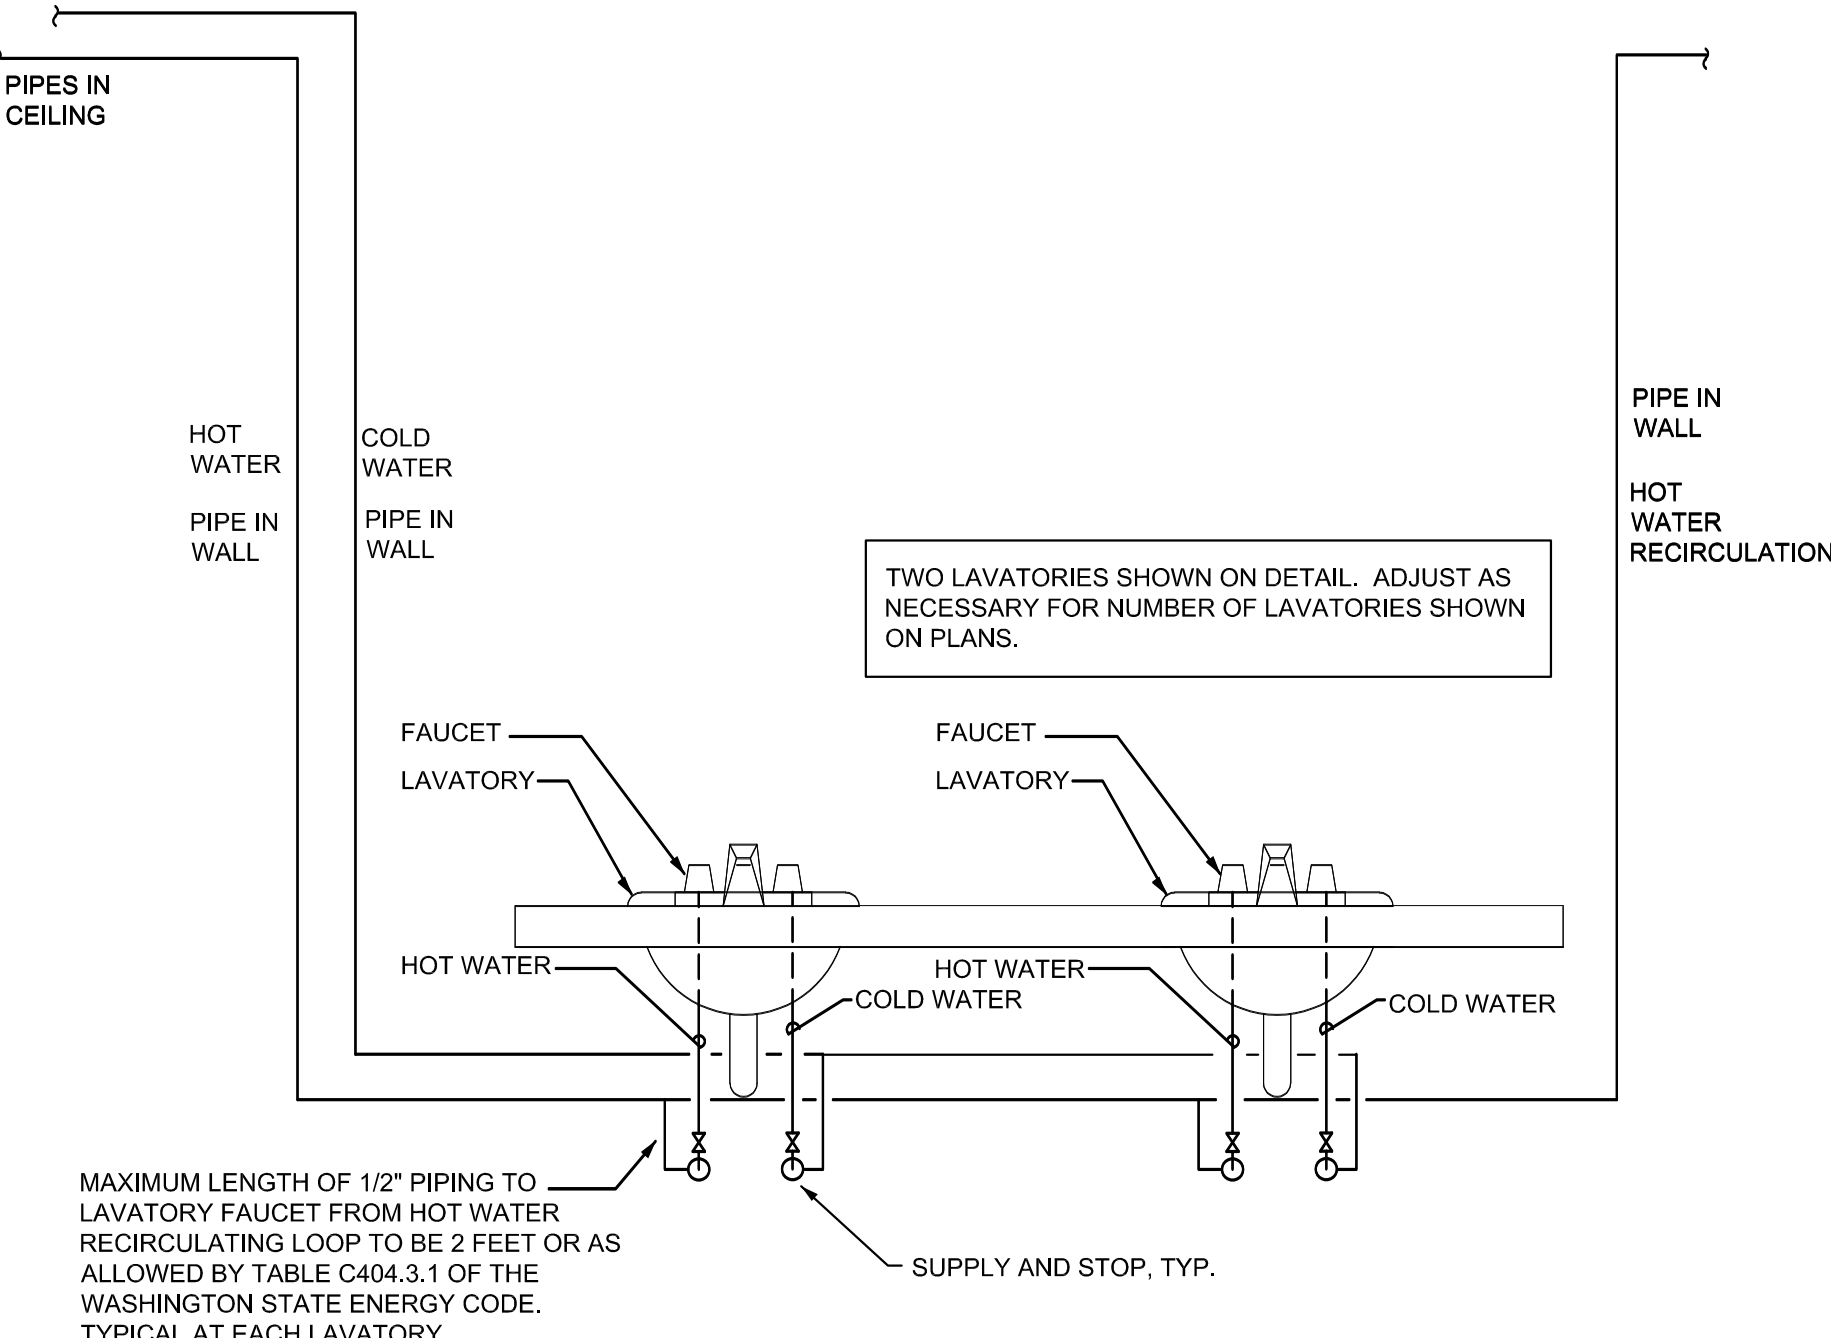

1 LAVATORY SUPPLY PIPING
P3.00 DIAGRAMMATIC

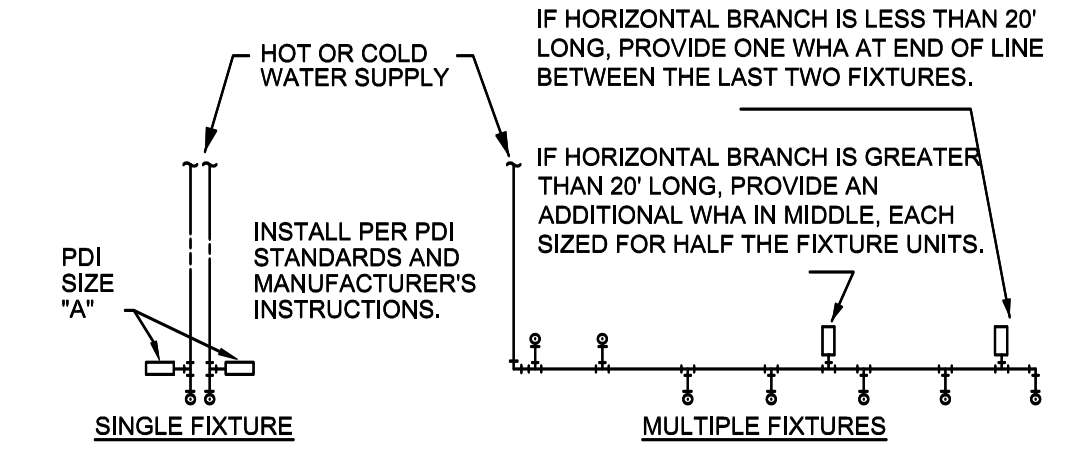

PDI SIZE	PIPE SIZE	FIXTURE UNIT LOAD
A	1/2"	1-11
B	3/4"	12-32
C	1"	33-60
D	1-1/4"	61-113
E	1-1/2"	114-154
F	2"	154-330

FIXTURE	FIXTURE UNIT TABULATION	
	COLD	HOT
WATER CLOSET	10	--
URINAL	5	--
LAVATORY/HAND SINK	1.5	1.5
SINK/JANITOR'S SINK	3	3

PC TO PROVIDE WATER HAMMER ARRESTORS BY SIOUX CHIEF, PRECISION PLUMBING PRODUCTS OR WATTS WITH PISTON AND O-RING CONSTRUCTION, HAVING PDI #WH-201, ASSE # 1010 AND ANSI # A112.26.1M CERTIFICATION. INSTALL IN HORIZONTAL OR VERTICAL POSITION, BUT NEVER UPSIDE DOWN. INSTALL IN LINE WITH WATER FLOW DIRECTION IF POSSIBLE. PROVIDE ACCESS DOOR FOR SERVICING.

2 WATER HAMMER SUPPLY PIPING
P3.00 DIAGRAMMATIC