


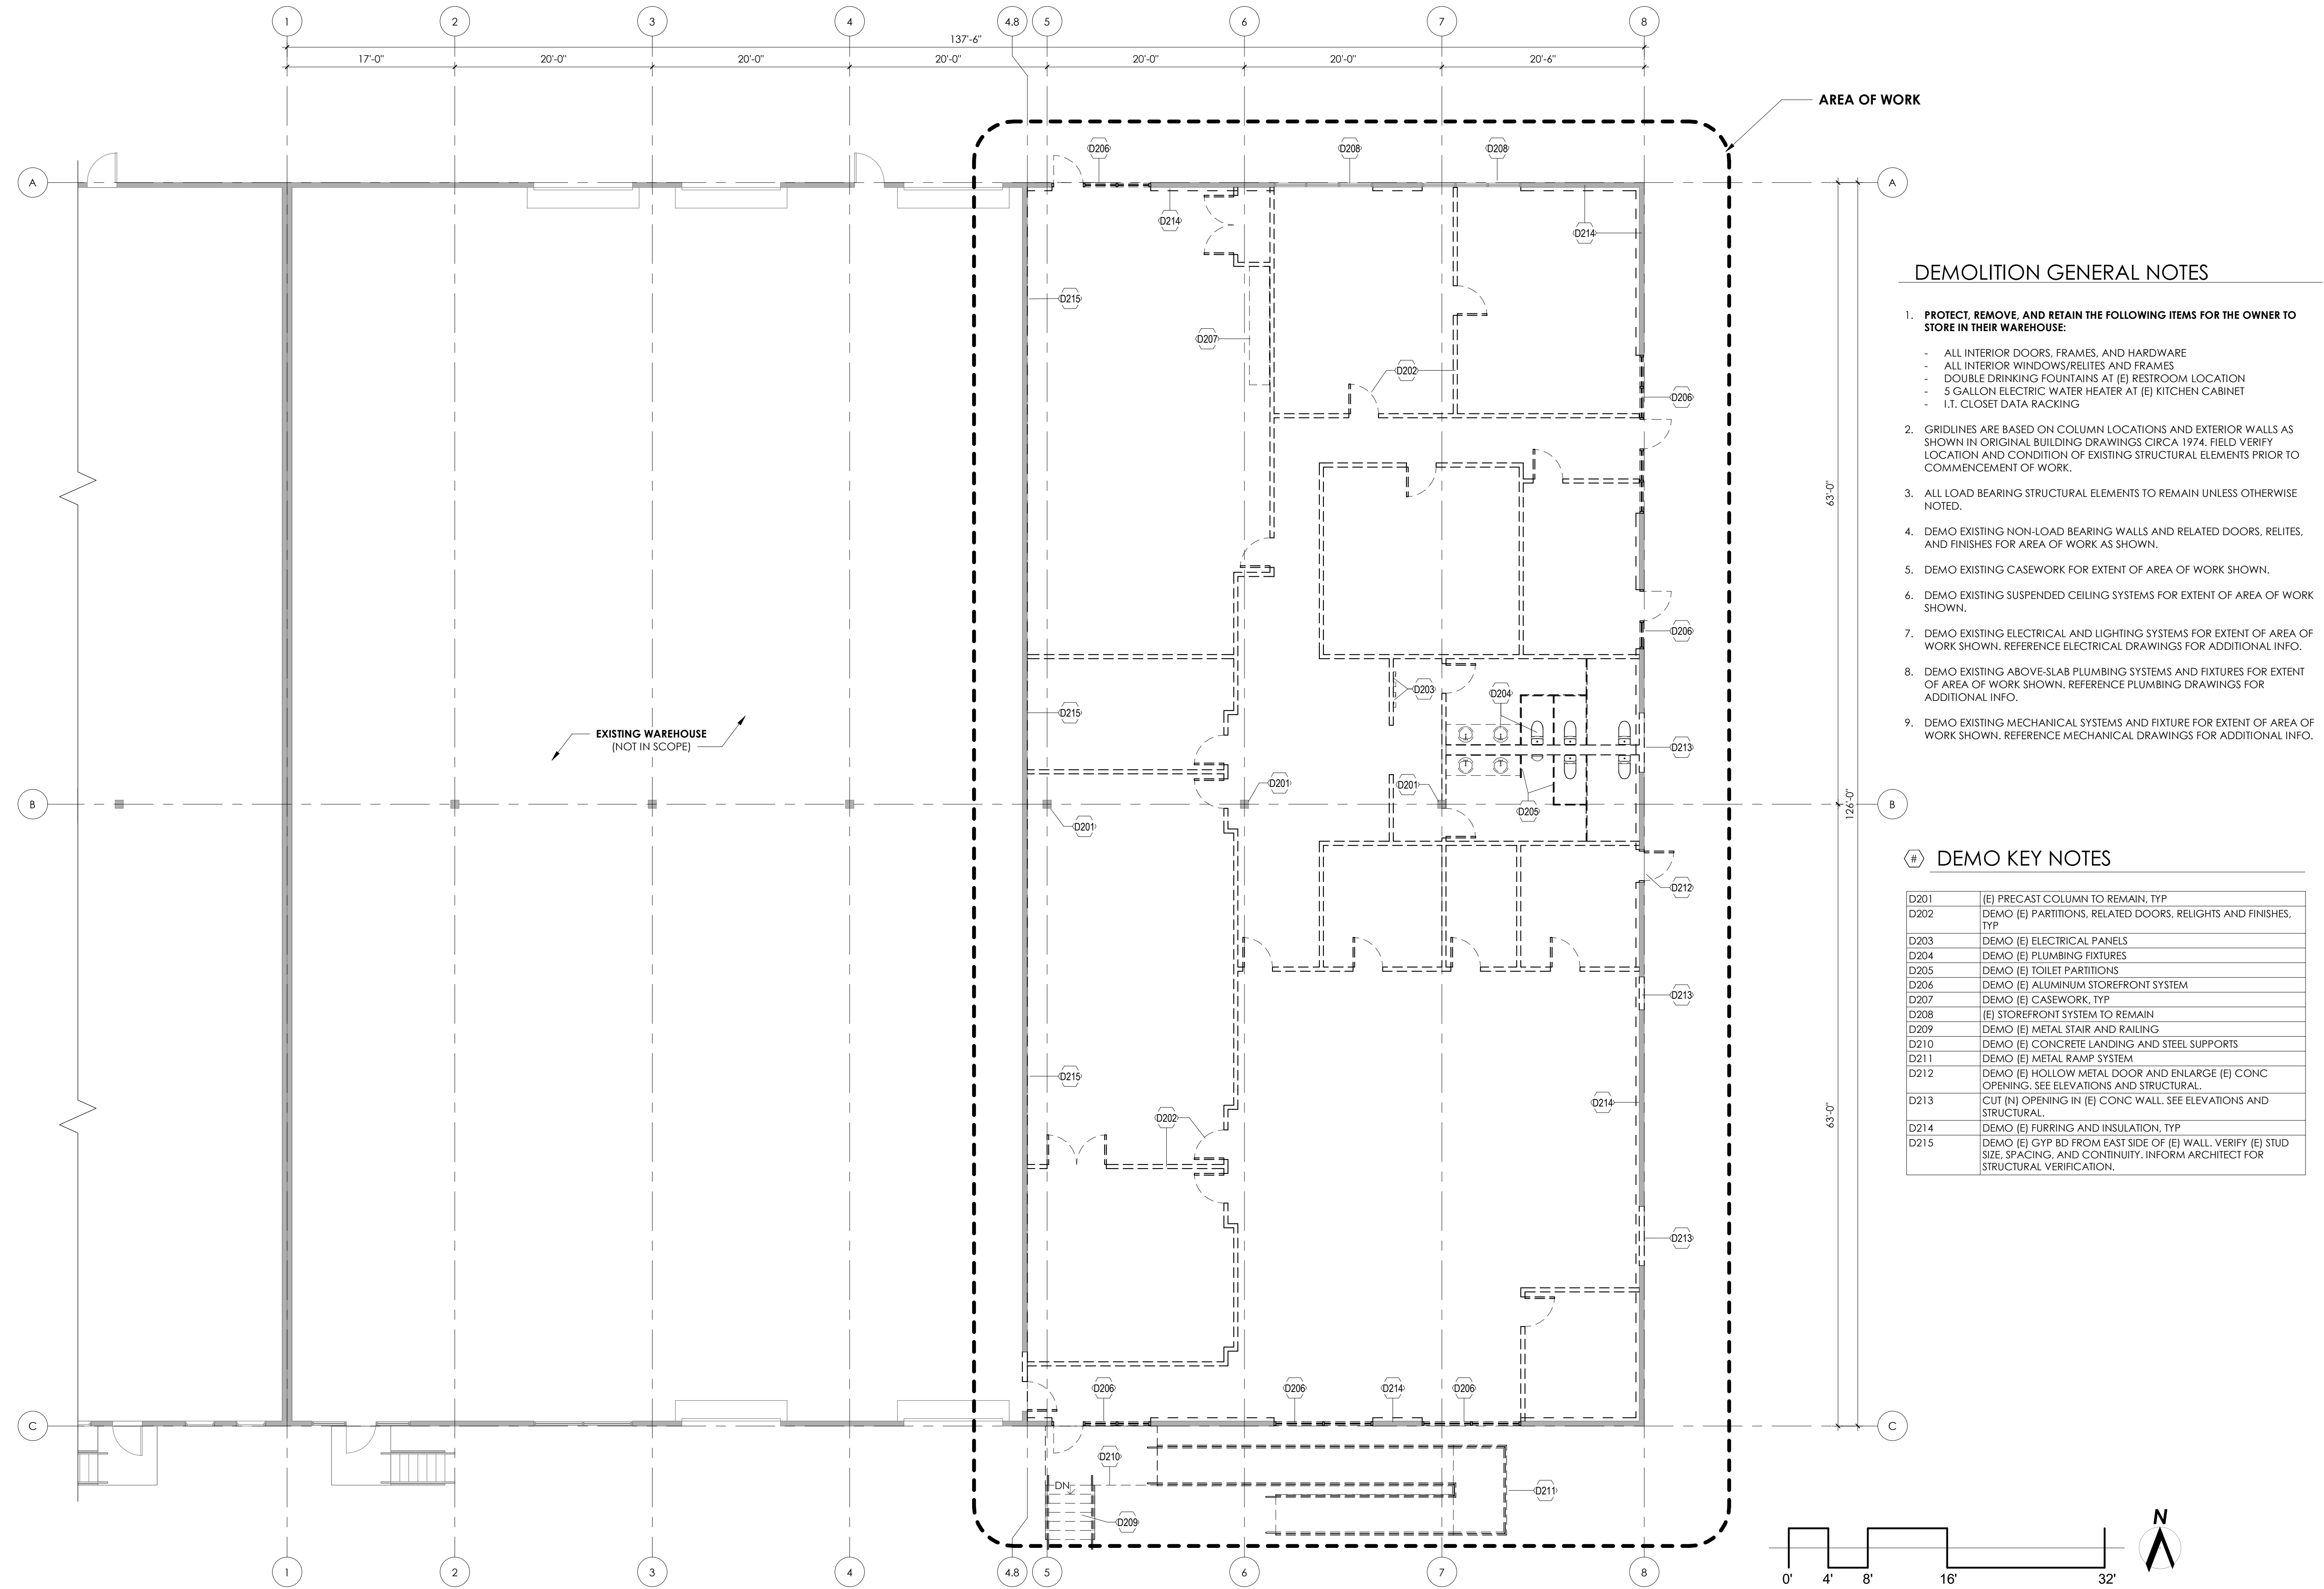


DEMOLITION GENERAL NOTES

1. PROTECT, REMOVE, AND RETAIN THE FOLLOWING ITEMS FOR THE OWNER TO STORE IN THEIR WAREHOUSE:
 - ALL INTERIOR DOORS, FRAMES, AND HARDWARE
 - ALL INTERIOR WINDOWS/RELITES AND FRAMES
 - DOUBLE DRINKING FOUNTAINS AT (E) RESTROOM LOCATION
 - 5 GALLON ELECTRIC WATER HEATER AT (E) KITCHEN CABINET
 - I.T. CLOSET DATA RACKING
2. GRIDLINES ARE BASED ON COLUMN LOCATIONS AND EXTERIOR WALLS AS SHOWN IN ORIGINAL BUILDING DRAWINGS CIRCA 1974. FIELD VERIFY LOCATION AND CONDITION OF EXISTING STRUCTURAL ELEMENTS PRIOR TO COMMENCEMENT OF WORK.
3. ALL LOAD BEARING STRUCTURAL ELEMENTS TO REMAIN UNLESS OTHERWISE NOTED.
4. DEMO EXISTING NON-LOAD BEARING WALLS AND RELATED DOORS, RELITES, AND FINISHES FOR AREA OF WORK AS SHOWN.
5. DEMO EXISTING CASEWORK FOR EXTENT OF AREA OF WORK SHOWN.
6. DEMO EXISTING SUSPENDED CEILING SYSTEMS FOR EXTENT OF AREA OF WORK SHOWN.
7. DEMO EXISTING ELECTRICAL AND LIGHTING SYSTEMS FOR EXTENT OF AREA OF WORK SHOWN. REFERENCE ELECTRICAL DRAWINGS FOR ADDITIONAL INFO.
8. DEMO EXISTING ABOVE-SLAB PLUMBING SYSTEMS AND FIXTURES FOR EXTENT OF AREA OF WORK SHOWN. REFERENCE PLUMBING DRAWINGS FOR ADDITIONAL INFO.
9. DEMO EXISTING MECHANICAL SYSTEMS AND FIXTURE FOR EXTENT OF AREA OF WORK SHOWN. REFERENCE MECHANICAL DRAWINGS FOR ADDITIONAL INFO.


DEMO KEY NOTES

D201	(E) PRECAST COLUMN TO REMAIN, TYP
D202	DEMO (E) PARTITIONS, RELATED DOORS, RELIGHTS AND FINISHES, TYP
D203	DEMO (E) ELECTRICAL PANELS
D204	DEMO (E) PLUMBING FIXTURES
D205	DEMO (E) TOILET PARTITIONS
D206	DEMO (E) ALUMINUM STOREFRONT SYSTEM
D207	DEMO (E) CASEWORK, TYP
D208	(E) STOREFRONT SYSTEM TO REMAIN
D209	DEMO (E) METAL STAIR AND RAILING
D210	DEMO (E) CONCRETE LANDING AND STEEL SUPPORTS
D211	DEMO (E) METAL RAMP SYSTEM
D212	DEMO (E) HOLLOW METAL DOOR AND ENLARGE (E) CONC OPENING. SEE ELEVATIONS AND STRUCTURAL.
D213	CUT (N) OPENING IN (E) CONC WALL. SEE ELEVATIONS AND STRUCTURAL.
D214	DEMO (E) FURRING AND INSULATION, TYP
D215	DEMO (E) GYP BD FROM EAST SIDE OF (E) WALL. VERIFY (E) STUD SIZE, SPACING, AND CONTINUITY. INFORM ARCHITECT FOR STRUCTURAL VERIFICATION.

1 / FLOOR PLAN - DEMOLITION
scale: 1/8" = 1'-0"

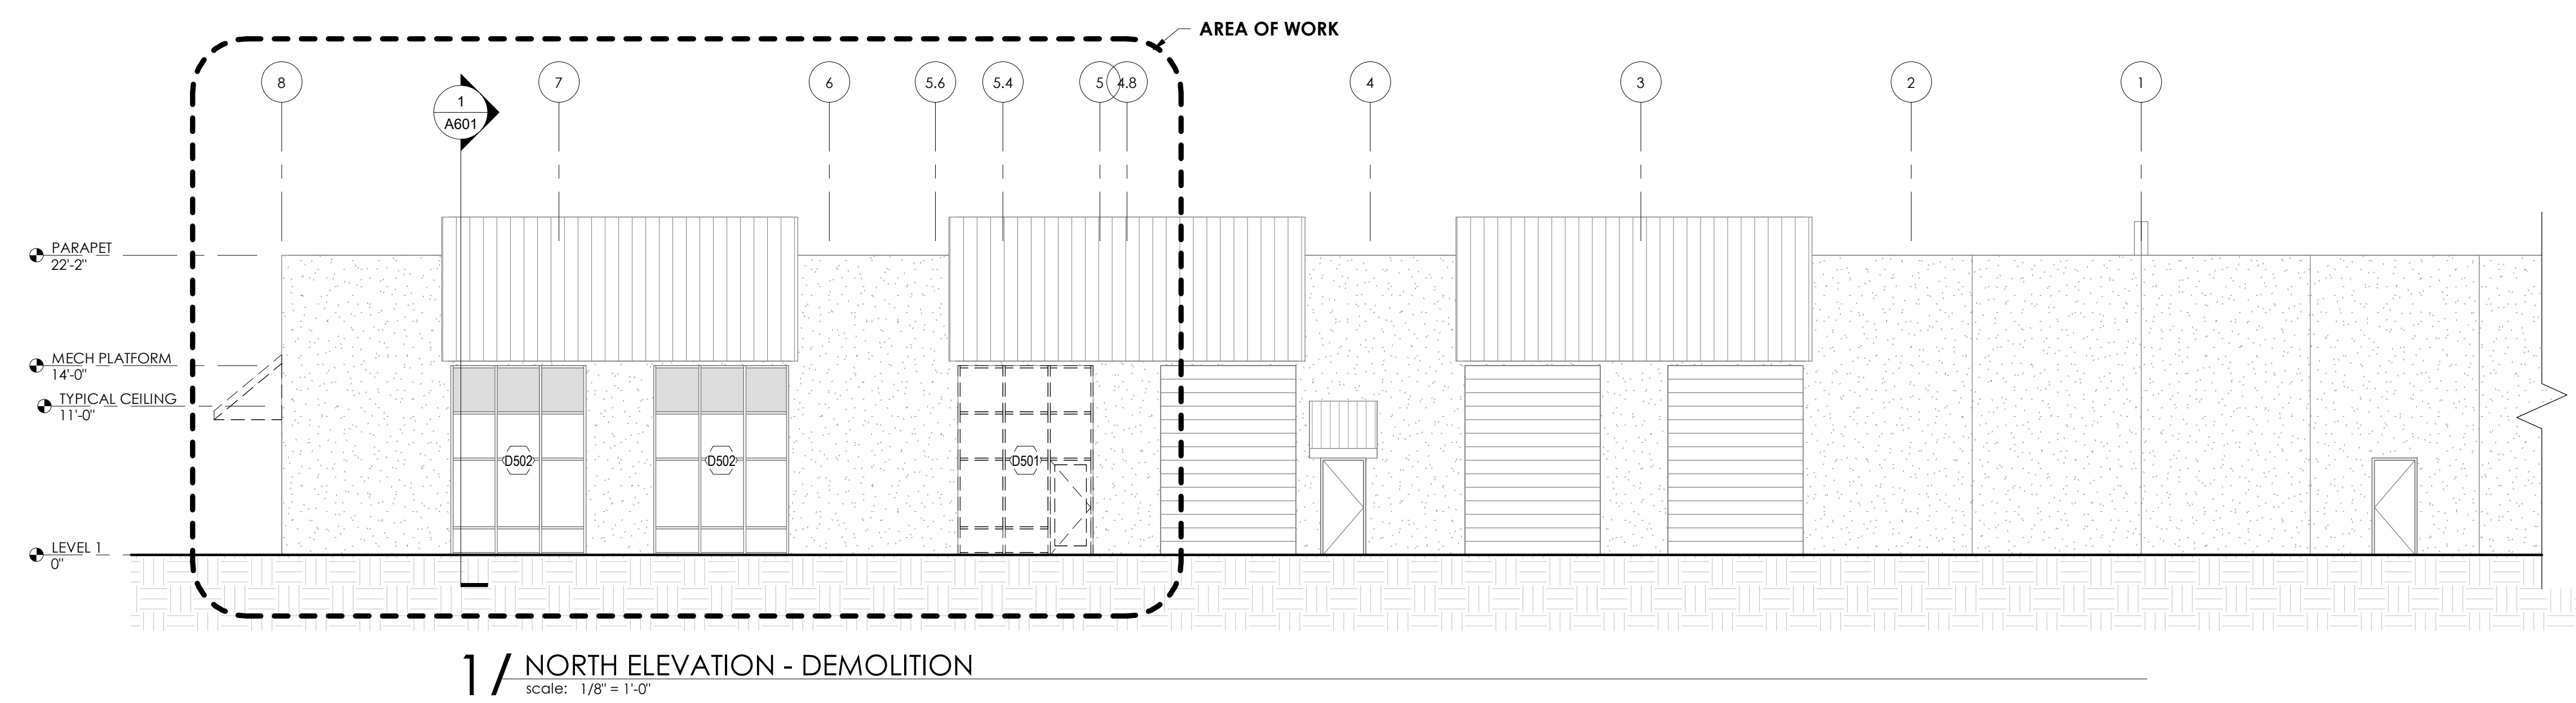


1 / NORTH ELEVATION - DEMOLITION
scale: 1/8" = 1'-0"

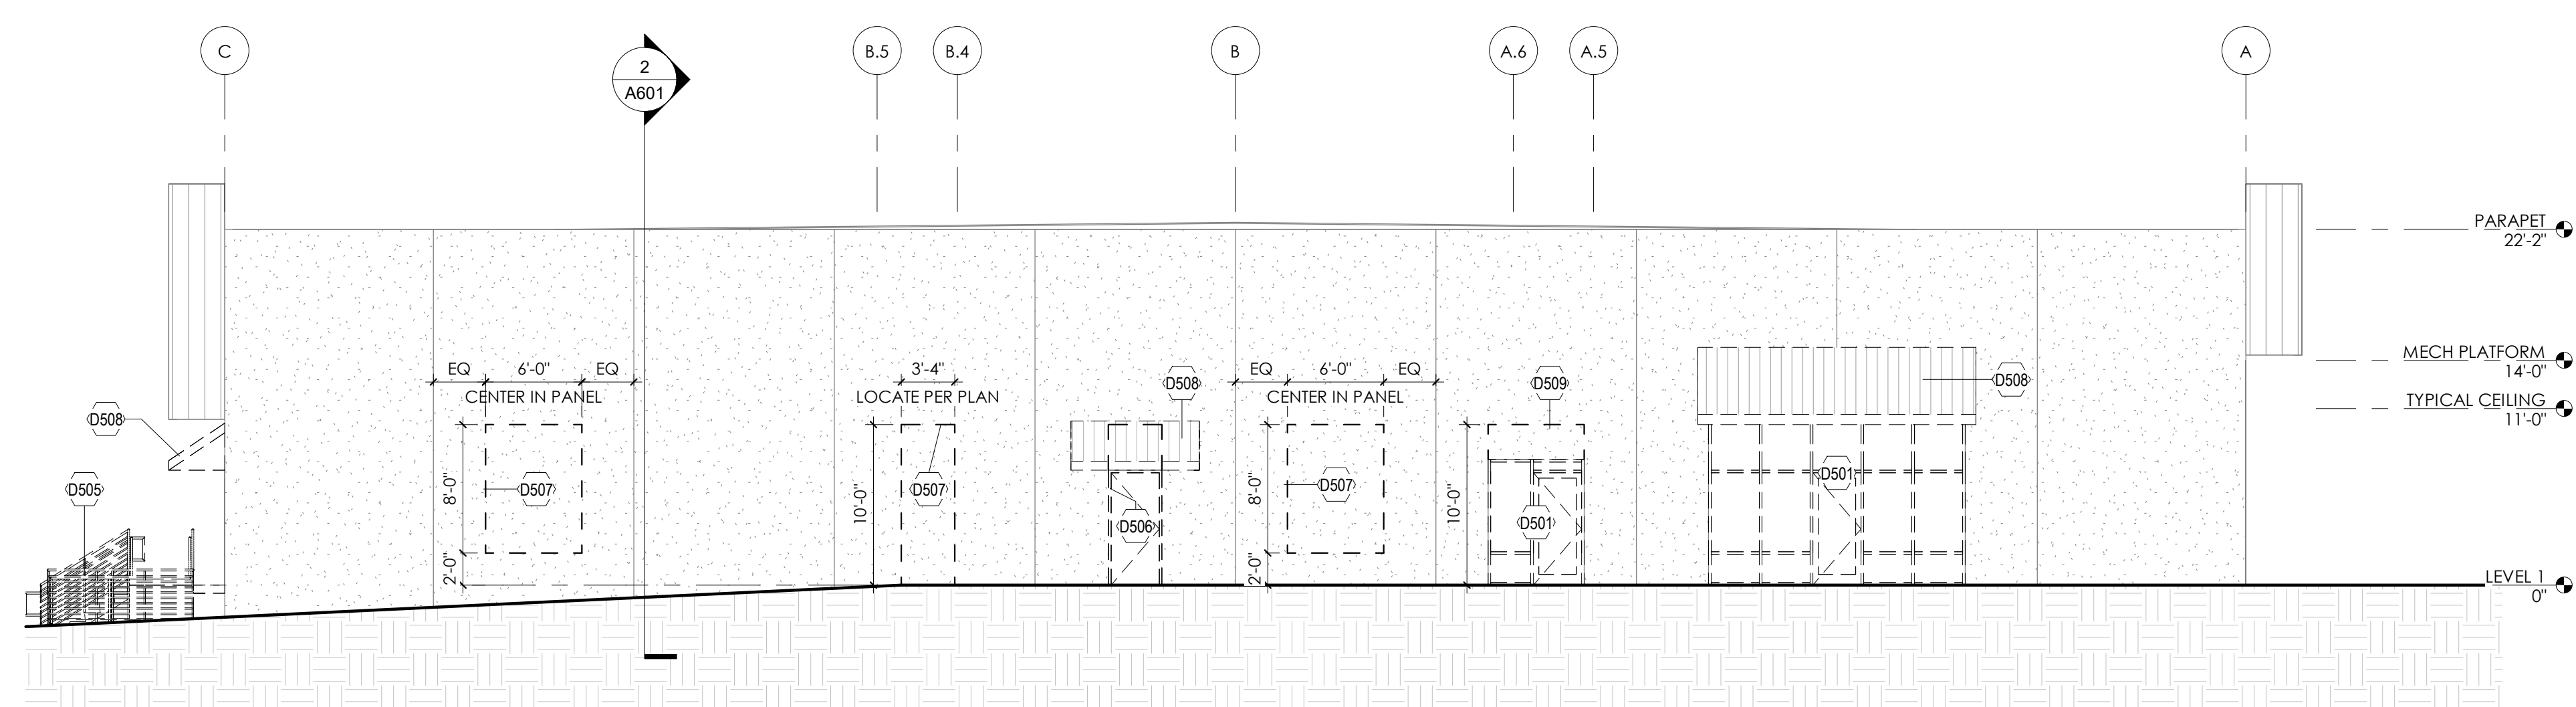

2 / EAST ELEVATION - DEMOLITION
scale: 1/8" = 1'-0"

#	DEMO KEY NOTES
D501	DEMO (E) ALUMINUM STOREFRONT SYSTEM
D502	(E) STOREFRONT SYSTEM TO REMAIN
D503	DEMO (E) METAL STAIR AND RAILING
D504	DEMO (E) CONCRETE LANDING AND STEEL SUPPORTS
D505	DEMO (E) METAL RAMP SYSTEM
D506	DEMO (E) HOLLOW METAL DOOR AND ENLARGE (E) CONC OPENING. SEE STRUCTURAL.
D507	CUT (N) OPENING IN (E) CONC WALL. SEE STRUCTURAL.
D508	DEMO (E) METAL AWNING & SUPPORT STRUCTURE
D509	ENLARGE (E) CONC OPENING. SEE STRUCTURAL.

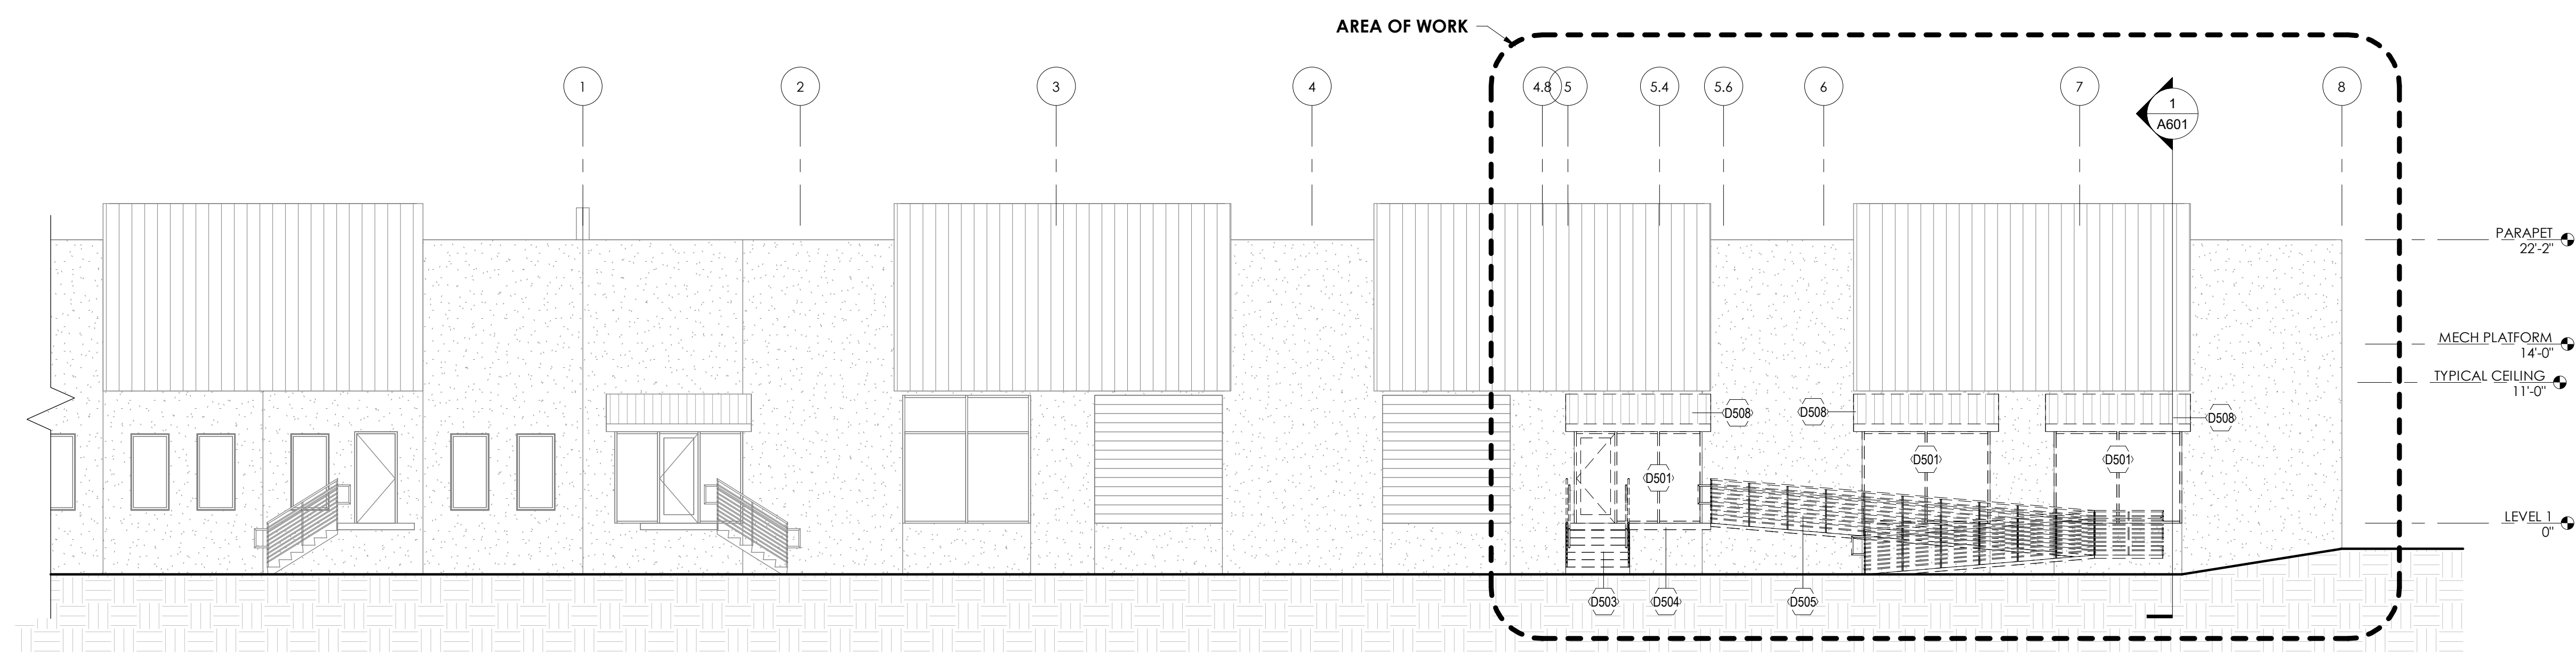

3 / SOUTH ELEVATION - DEMOLITION
scale: 1/8" = 1'-0"




ESD 112 - 2200 Building
Education Facility Renovation
2200 NE 65th Ave.
Vancouver, WA 98661


DATE: 08.07.2026
DRAWN BY: KR
JOB NO: 26-004
REV NO:

DEMO ELEVATIONS

AD501

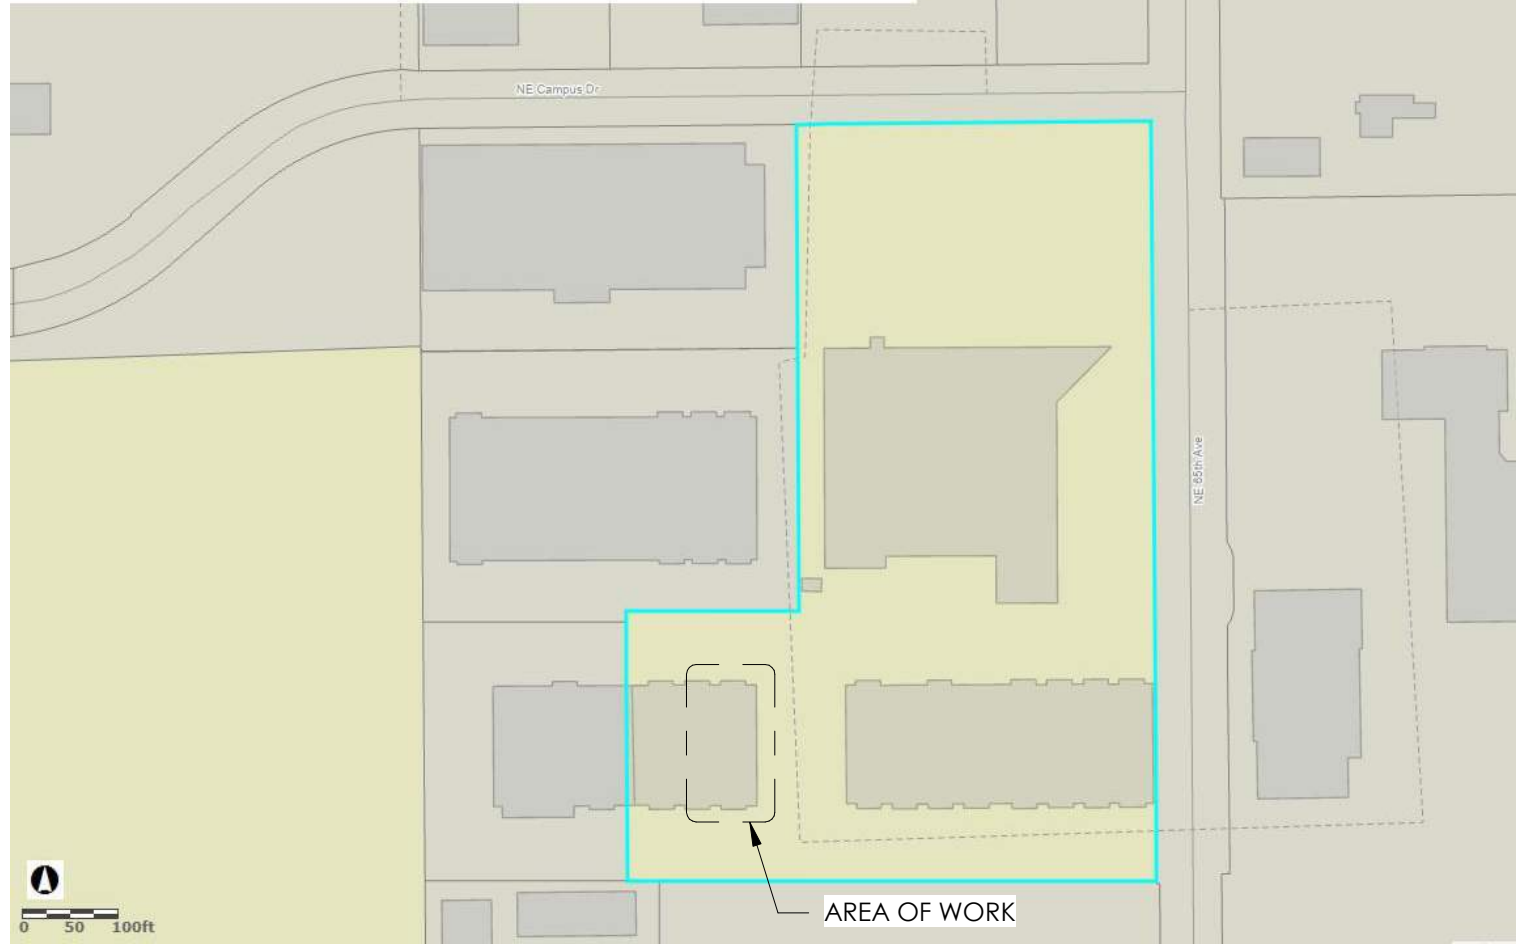

SITE MAP
scale: 1" = 200'-0"

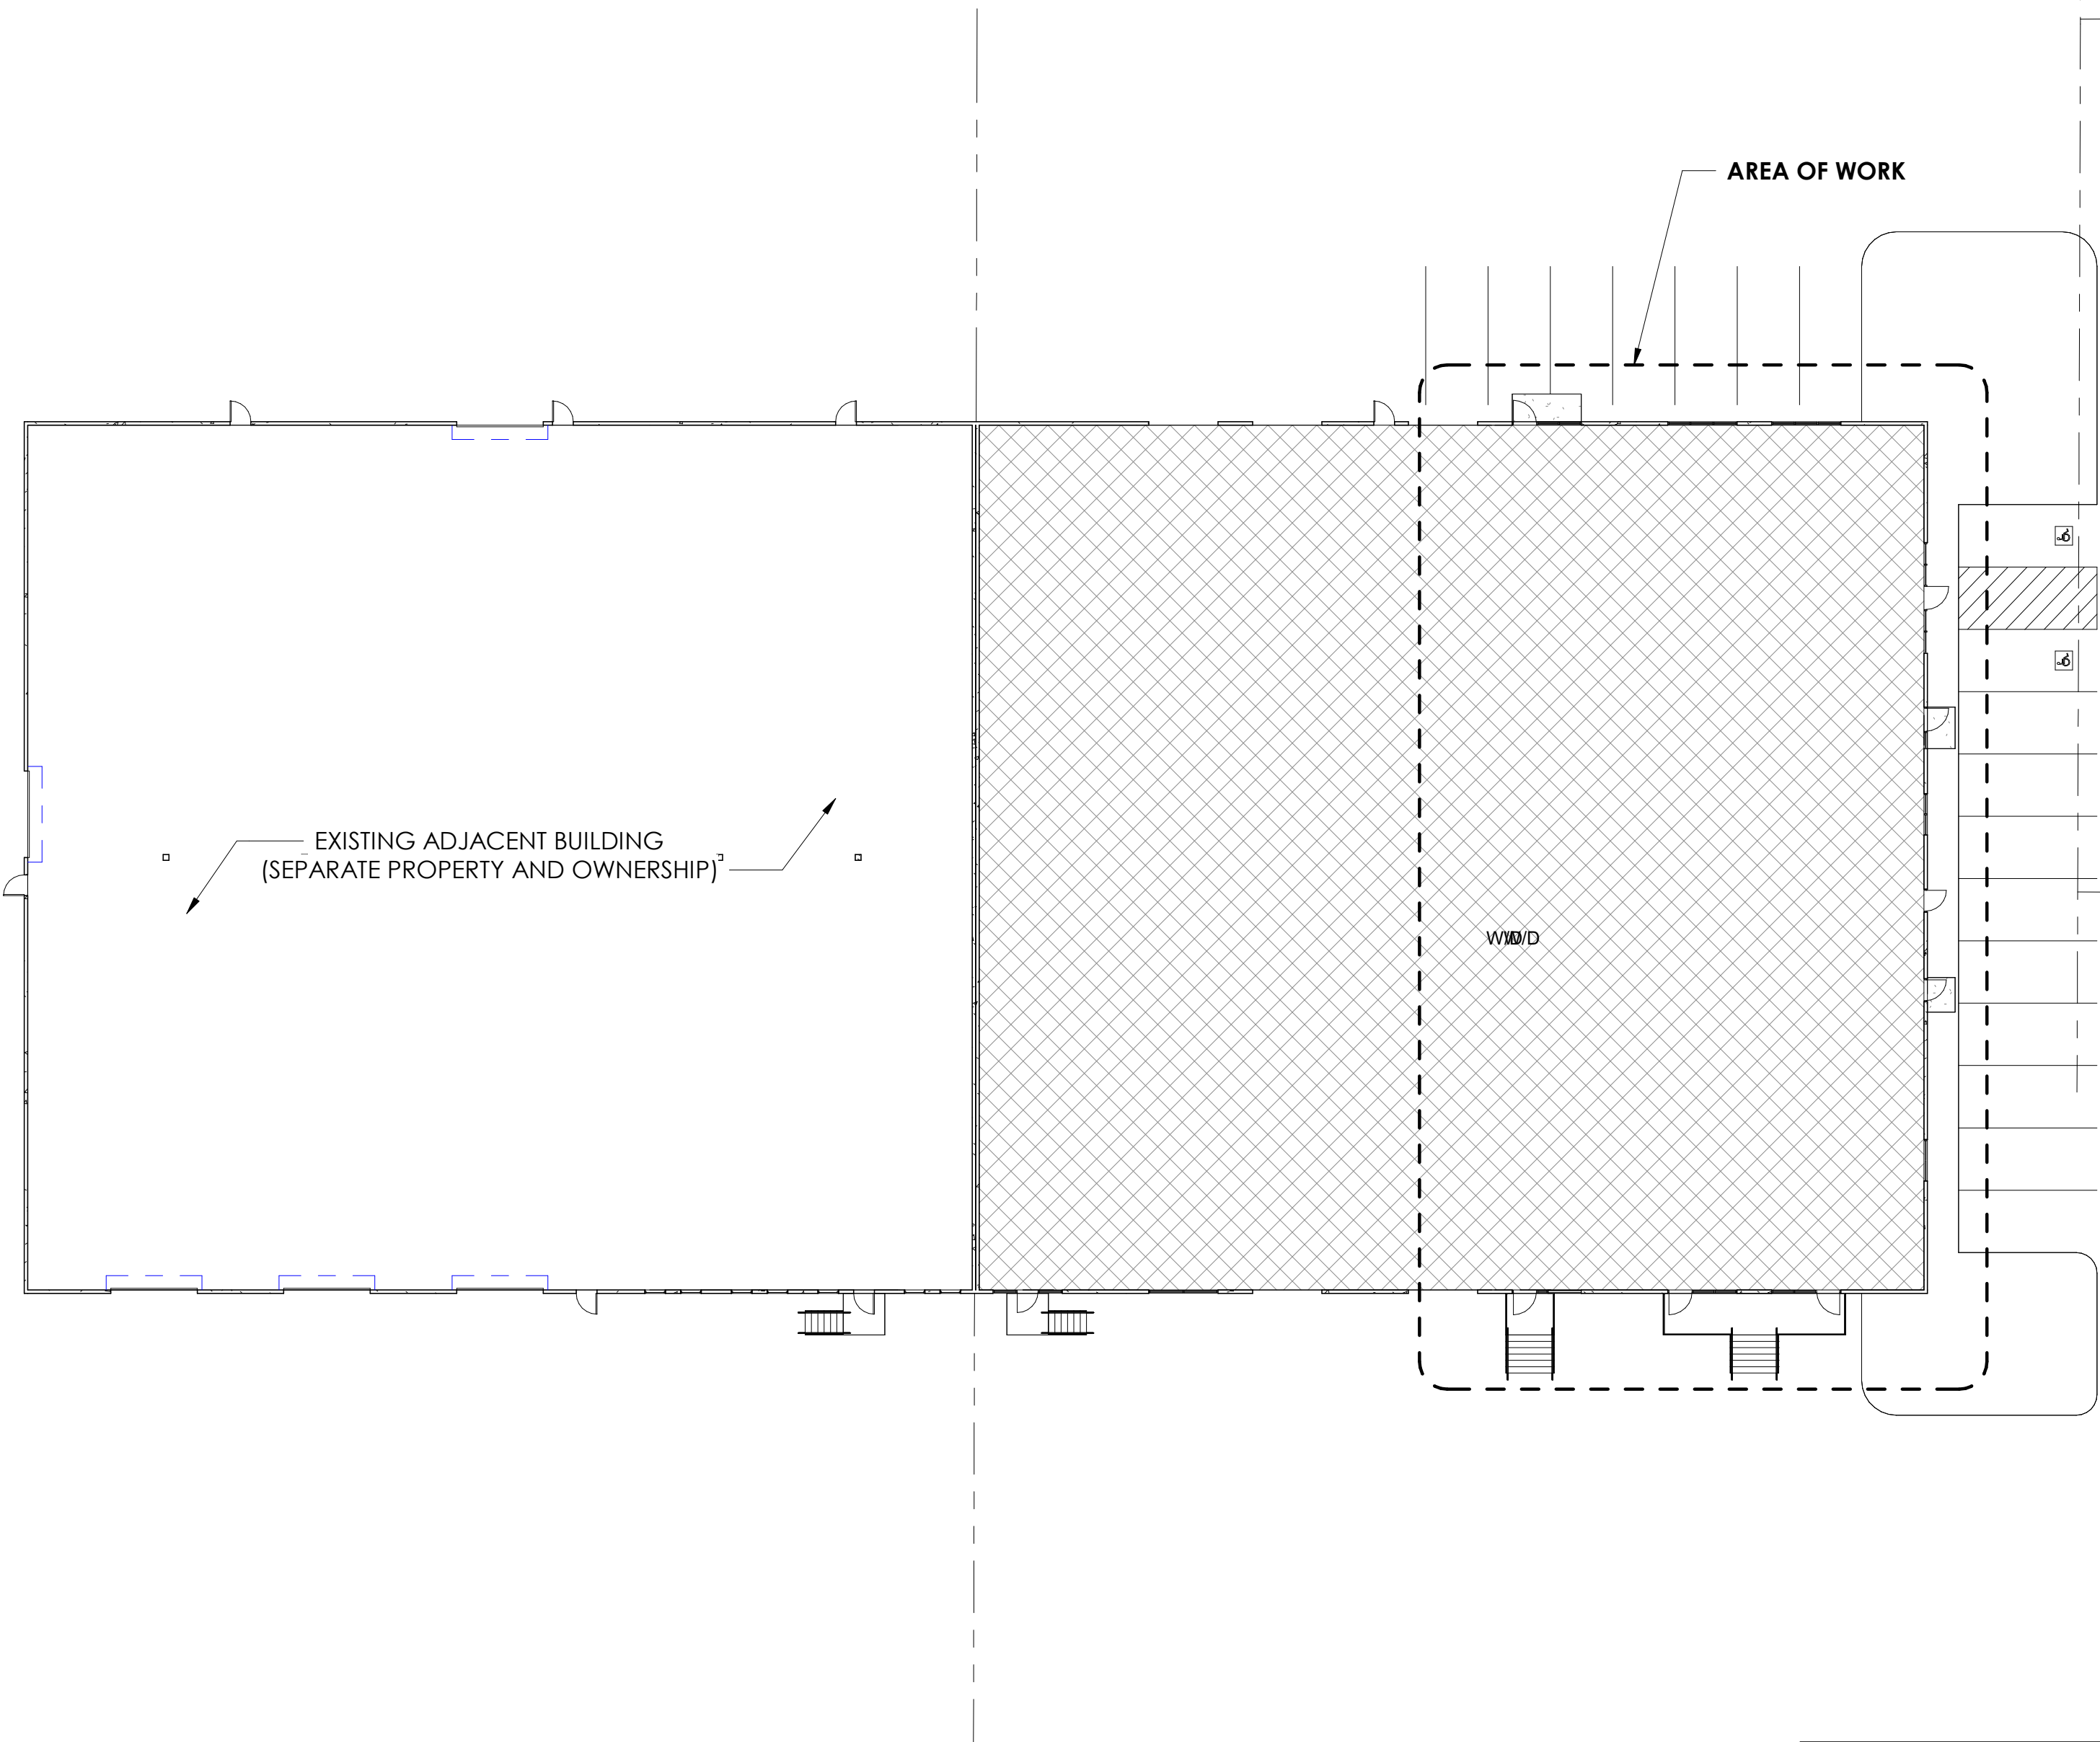

1 / SITE PLAN
scale: 1" = 20'-0"

KEY NOTES


SAN SEWER
RIM ELEV: 191.15'
IE 8" DI (C): 180.06'
IE 8" DI (W): 180.06'
(NO VISIBLE FLOW)

APPROXIMATE LOCATION OF SANITARY SEWER
(FOUND LOCATION OF CLEANOUT IN BUILDING AND
PROJECTED THE LINE NORTH)

FF ELEV: 191.13'
(TOP OF CONC IN
FRONT OF BAY DOOR)

FF ELEV: 191.17'
(TOP OF CONC IN
FRONT OF BAY DOOR)

FF ELEV: 191.02'
(TOP OF CONC IN FRONT OF
BAY DOOR)

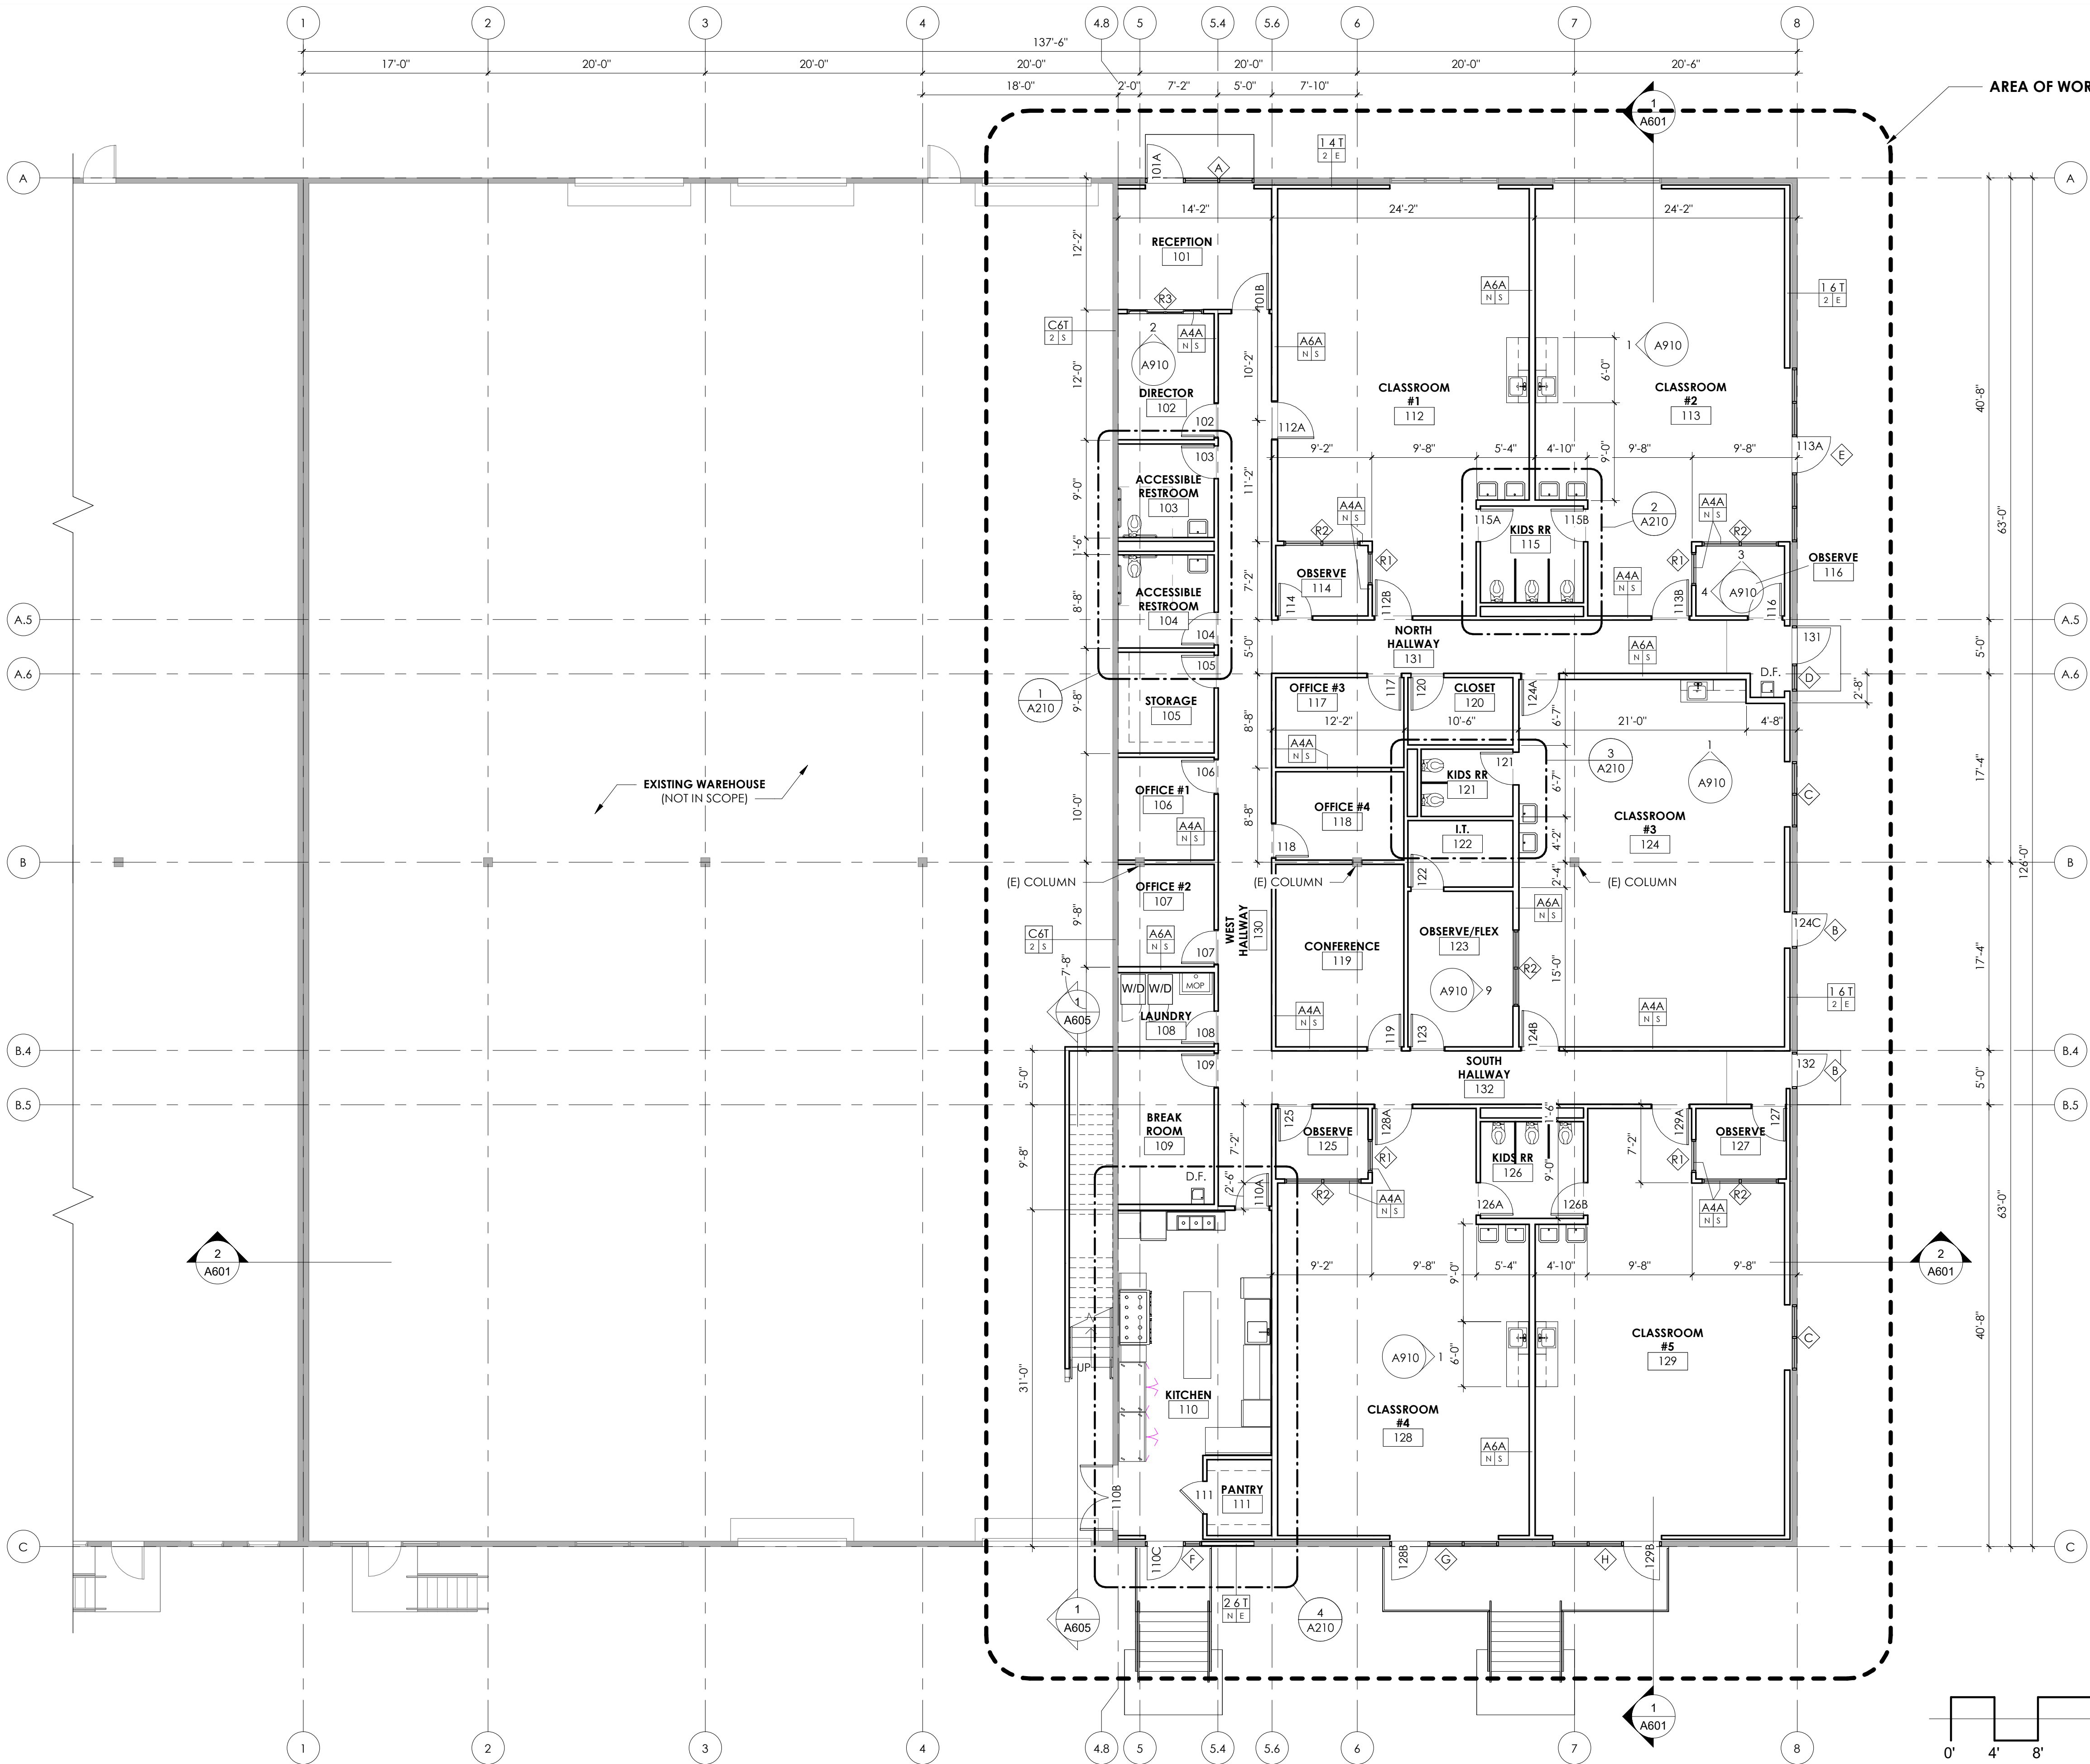


- FLOOR PLAN GENERAL NOTES**
- ALL DIMENSIONS ARE TO FACE OF FRAMING, CENTER OF COLUMN, OR GRIDLINE UNLESS NOTED OTHERWISE. EXTERIOR DIMENSIONS ARE TO FACE OF CONCRETE, DIMENSIONS INDICATED AS "CLR" ARE CLEAR MINIMUM TO FACE OF FINISH.
 - EXTERIOR OPENING CONDITIONS AND SIZES VARY. SEE PLANS AND WINDOW SCHEDULE FOR SIZE, TYPE, AND FUNCTION.
 - SEE STRUCTURAL PLANS FOR LOCATIONS OF SHEAR WALLS WITH ADDITIONAL PLYWOOD SHEATHING.
 - TYPICAL EXTERIOR WALL TYPE IS $\frac{1}{4}T$ $\frac{2}{E}$ U.N.O.
 - TYPICAL INTERIOR WALL TYPE IS $\frac{A}{4}$ $\frac{N}{S}$ U.N.O.
 - TYPICAL INTERIOR PLUMBING WALL TYPE IS $\frac{A}{6A}$ $\frac{N}{S}$ U.N.O.
 - PROVIDE ACOUSTICAL BATT INSULATION AT WALLS SURROUNDING RESTROOMS, CLASSROOMS, OFFICES, AND OBSERVATION ROOMS, TYPICAL.
 - PROVIDE MOISTURE RESISTANT GYPSUM WALL BOARD AT ALL PLUMBING WALL LOCATIONS.
 - ALL DOOR OPENINGS PERPENDICULAR TO A WALL ARE 4" TO THE WALL U.N.O.
 - DOTTED BOXES AND CIRCLES DESIGNATE ACCESSIBLE CLEAR FLOOR SPACES FOR REFERENCE. SEE ACCESSIBILITY DETAIL SHEETS FOR DETAILS.
 - SEE ACCESSIBILITY DETAIL SHEETS FOR FIXTURE MOUNTING HEIGHTS AND GRAB BAR BLOCKING REQUIREMENTS.




**ESD 112 - 2200 Building
Education Facility Renovation**
2200 NE 65th Ave.
Vancouver, WA 98661


DATE: 08.07.2026
DRAWN BY: KR
JOB NO: 26-004
REV NO:

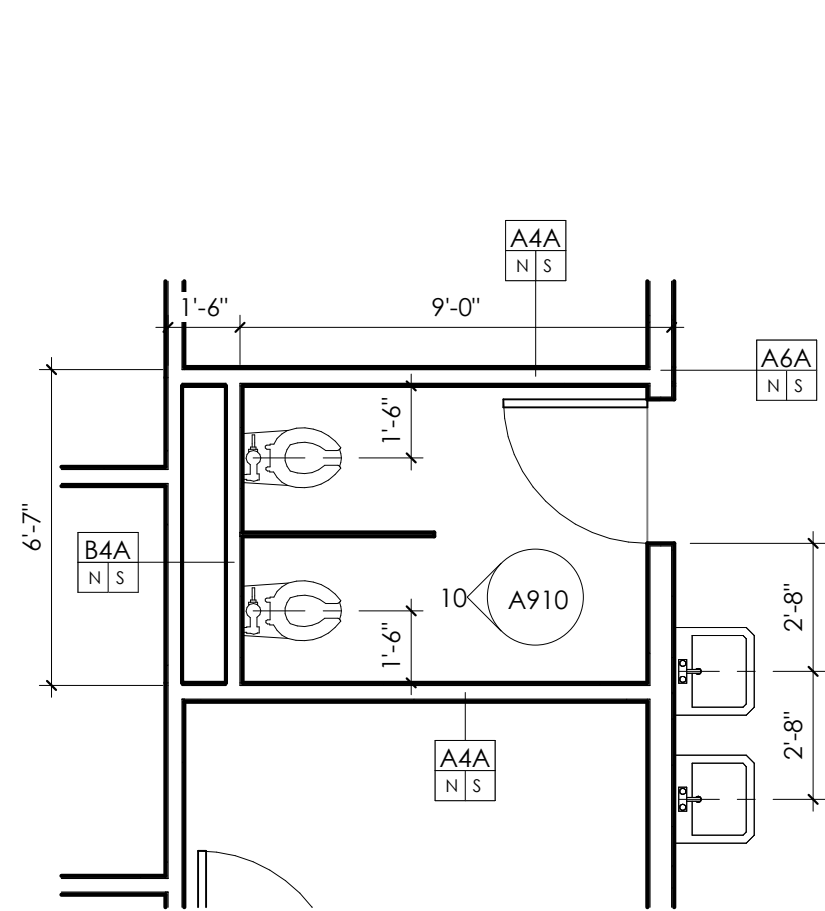

3/ ENLARGED KIDS RESTROOM #121
scale: 1/4" = 1'-0"

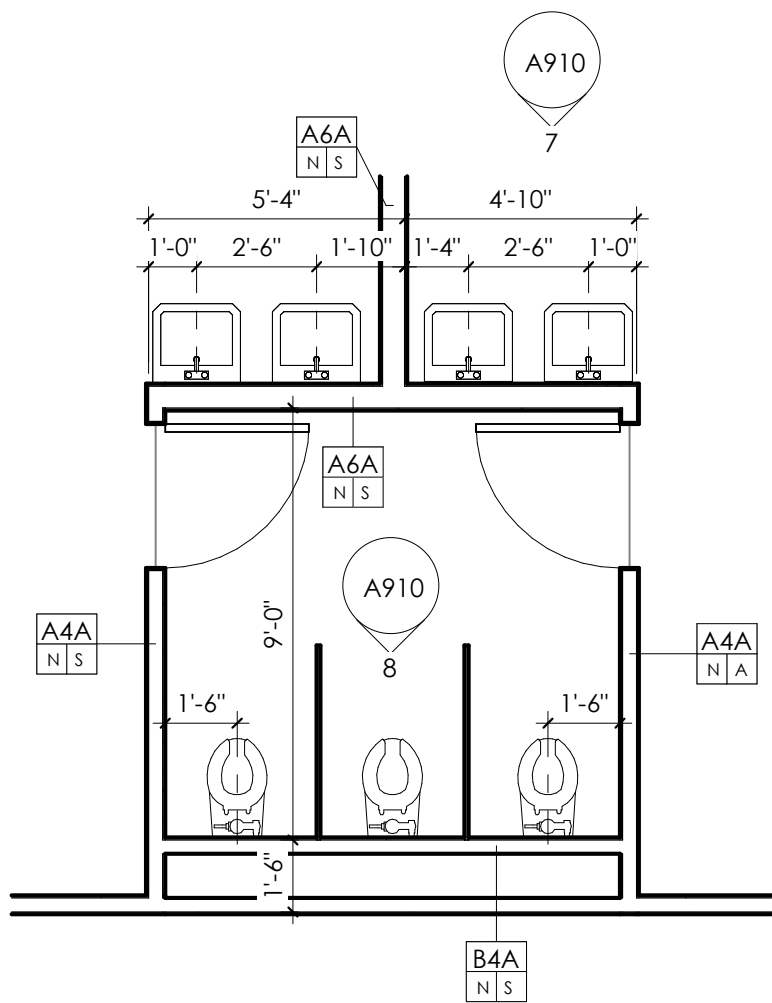

2/ ENLARGED KIDS RESTROOM #115 & #126
scale: 1/4" = 1'-0"

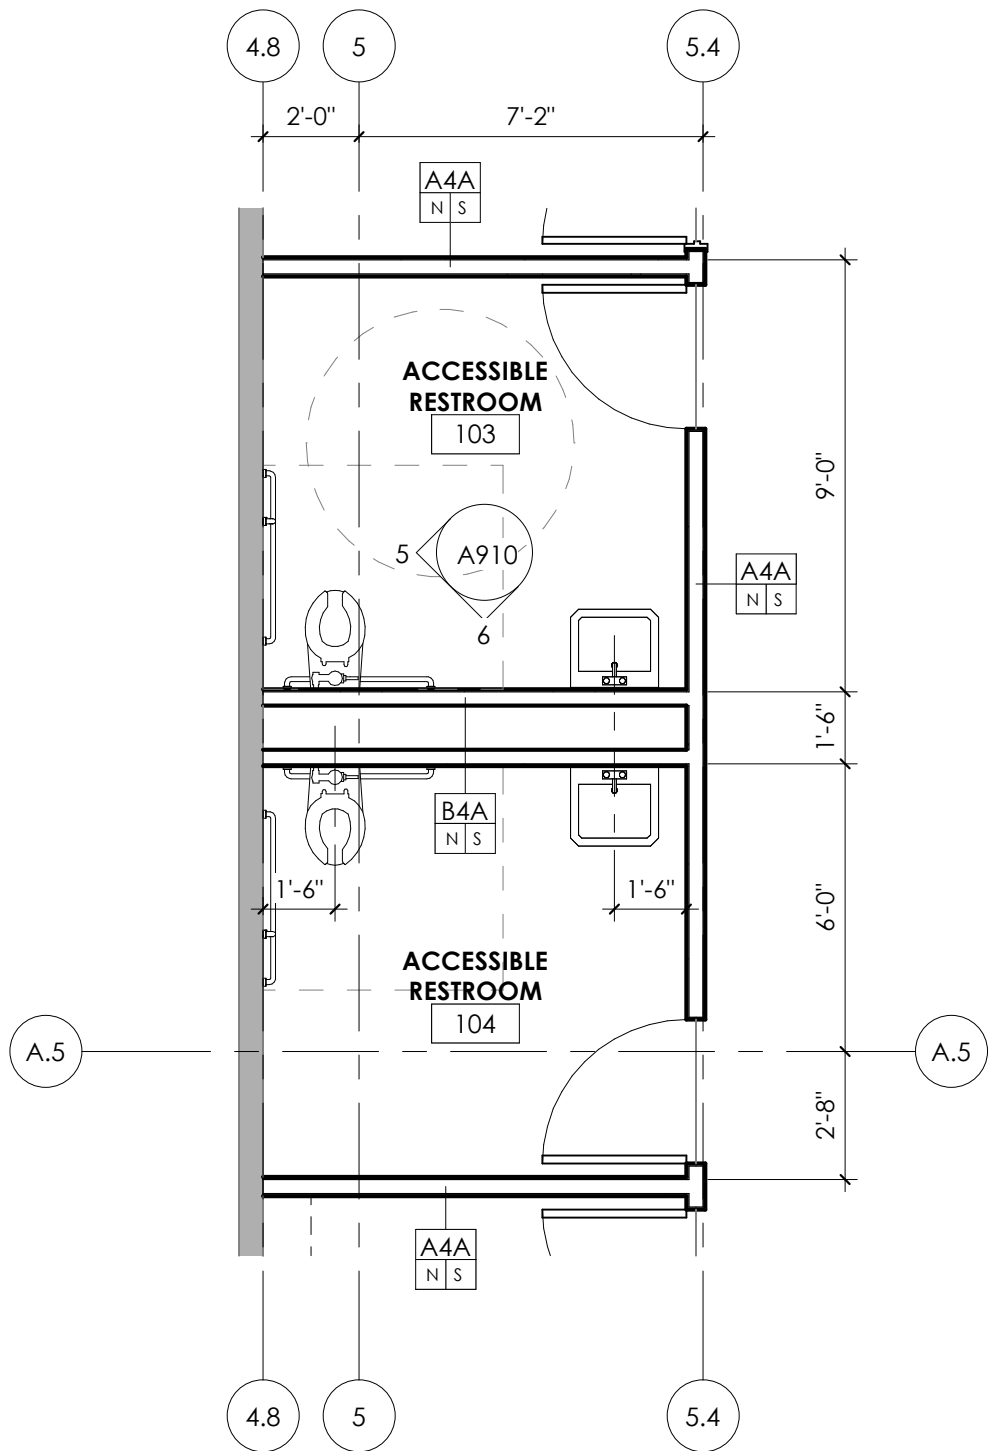


1/ ACCESSIBLE RESTROOM PLAN
scale: 1/4" = 1'-0"

KITCHEN EQUIPMENT

NOTE:
ALL OF THE BELOW COMMERCIAL KITCHEN EQUIPMENT AND
FIXTURES ARE TO BE **OWNER FURNISHED, CONTRACTOR INSTALLED.**

XX-#	
REF-1	REFRIGERATOR AVANTCO A-23R-HC 29" REACH-IN REFRIGERATOR #178A23RHC
REF-2	REFRIGERATOR AVANTCO A-49R-HC 54" REACH-IN REFRIGERATOR #178A49RHC
FRZ-1	FREEZER AVANTCO A-49F-HC 54" REACH-IN FREEZER #178A49FHC
RNG-1	RANGE COOKING PERFORMANCE GROUP ER60-208-3 60" RANGE #351ER60SC
WO-1	WARMING OVEN AVANTCO HPI-1836DC HOLDING/PROOFING CABINET #177HPI1836DC
S-1	3-COMPARTMENT SINK REGENCY 64" THREE COMPARTMENT SINK W/ DRAINBOARDS #600S3122012X
S-2	SINGLE SINK REGENCY 49 1/2" ONE COMPARTMENT COMMERCIAL SINK #60S1232324XL
DW-1	DISHWASHER MAINSTREET EQUIPMENT HTDT SINGLE RACK HIGH-TEMP #541HTDT403
TBL-1	ISLAND WORK TABLE REGENCY 30" X 96" COMMERCIAL ISLAND WORK TABLE #600TA3096S
TBL-2	WORK TABLE W/ SHELF REGENCY 30" X 60" COMMERCIAL WORK TABLE WITH SHELVES #600WT3060KIT
TBL-3	WORK TABLE REGENCY 30" X 72" COMMERCIAL WORK TABLE #600TSB3072S
TBL-4	FILLER TABLE REGENCY 30" X 18" EQUIPMENT FILLER TABLE # 600TB3018G
TBL-5	FILLER TABLE REGENCY 30" X 24" EQUIPMENT FILLER TABLE # 600TB3024G

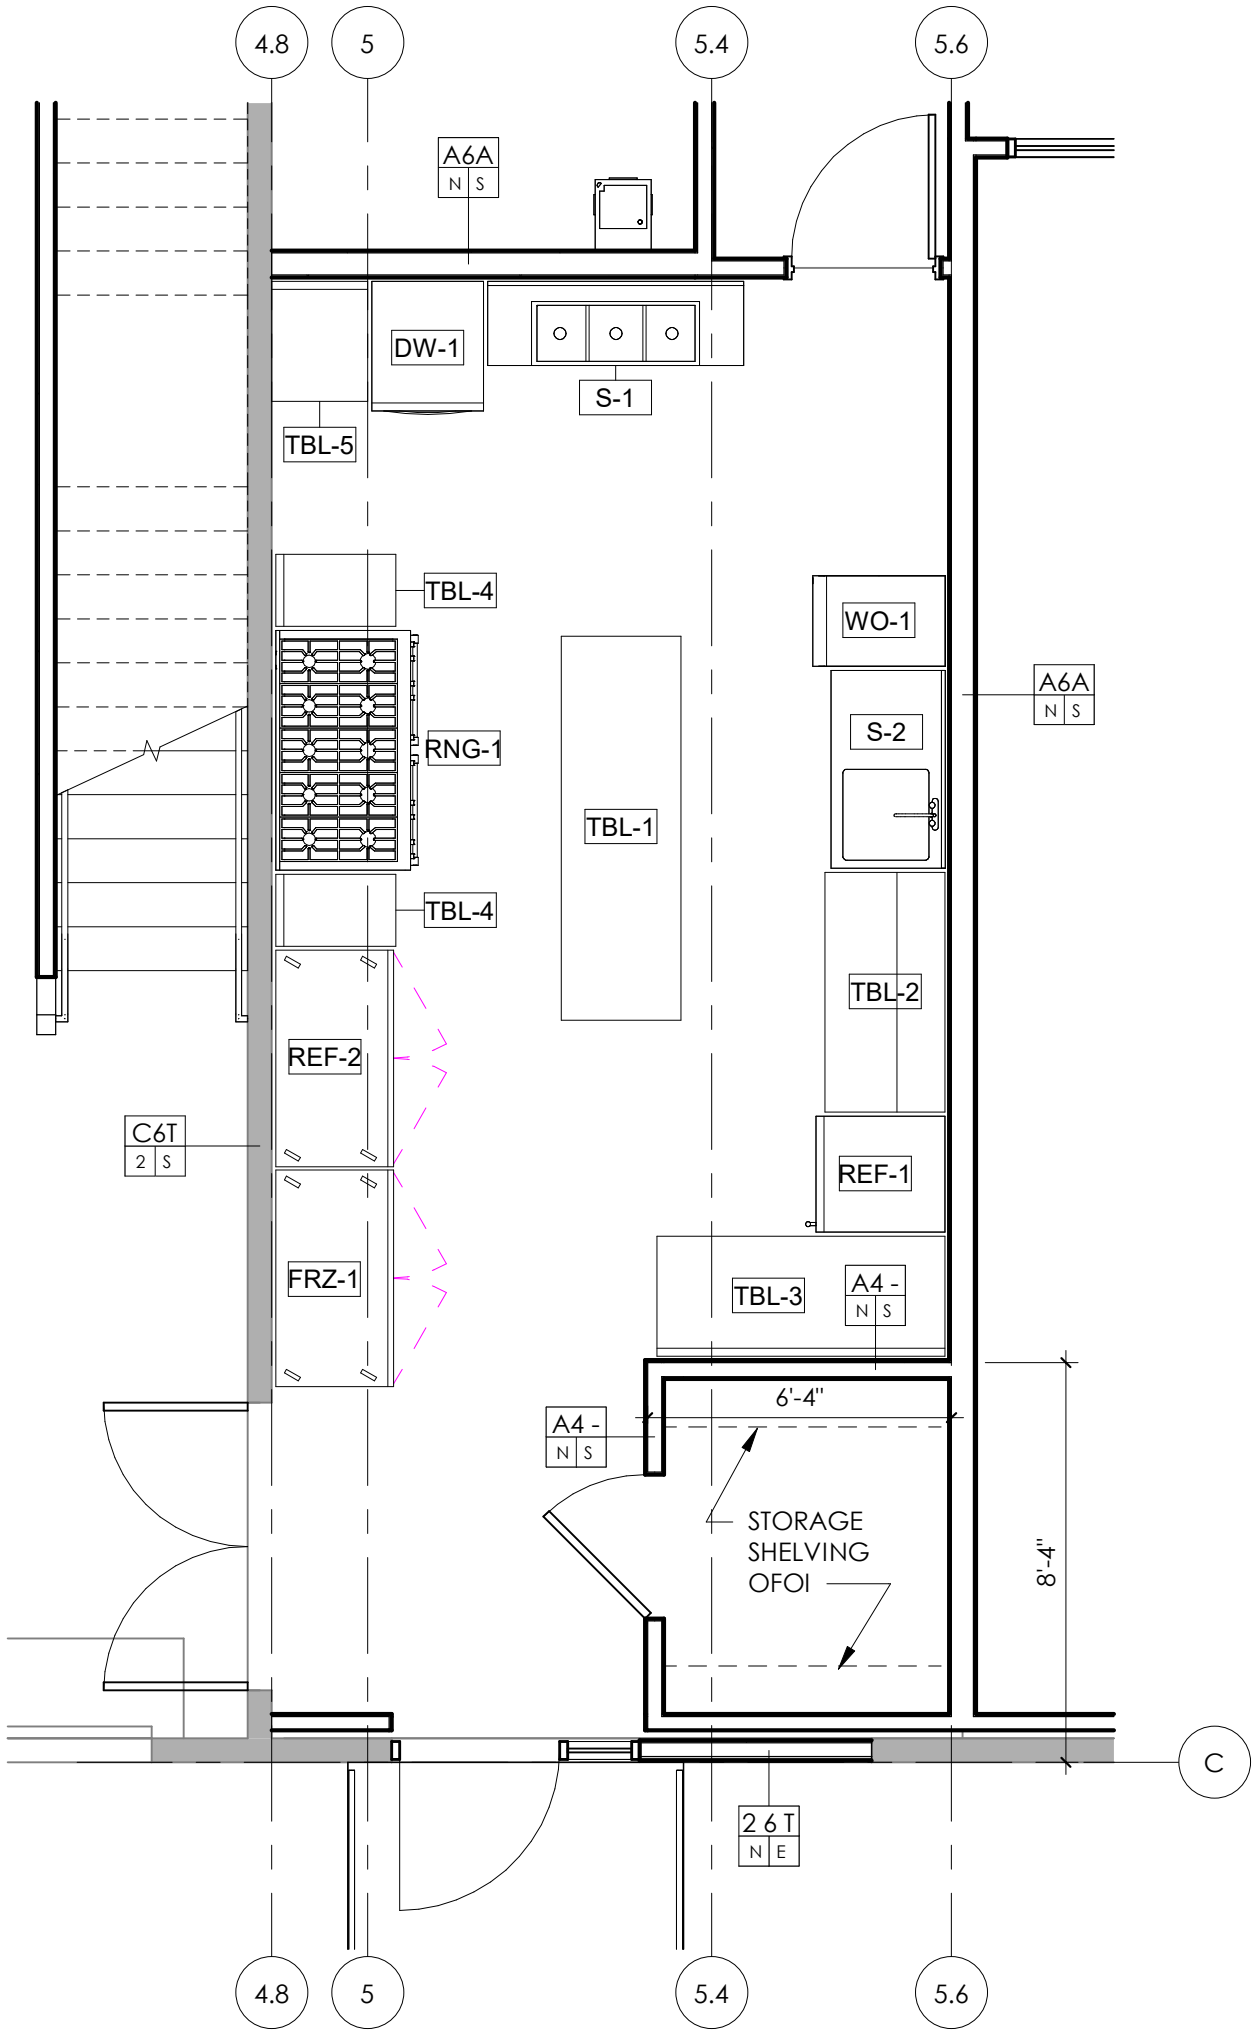

4/ ENLARGED KITCHEN PLAN
scale: 1/4" = 1'-0"

ESD 112 - 2200 Building
Education Facility Renovation
2200 NE 65th Ave.
Vancouver, WA 98661


DATE: 08.07.2026
DRAWN BY: KR
JOB NO: 26-004
REV NO:

ENLARGED FLOOR
PLANS


A210

PERMIT SET


© 2026

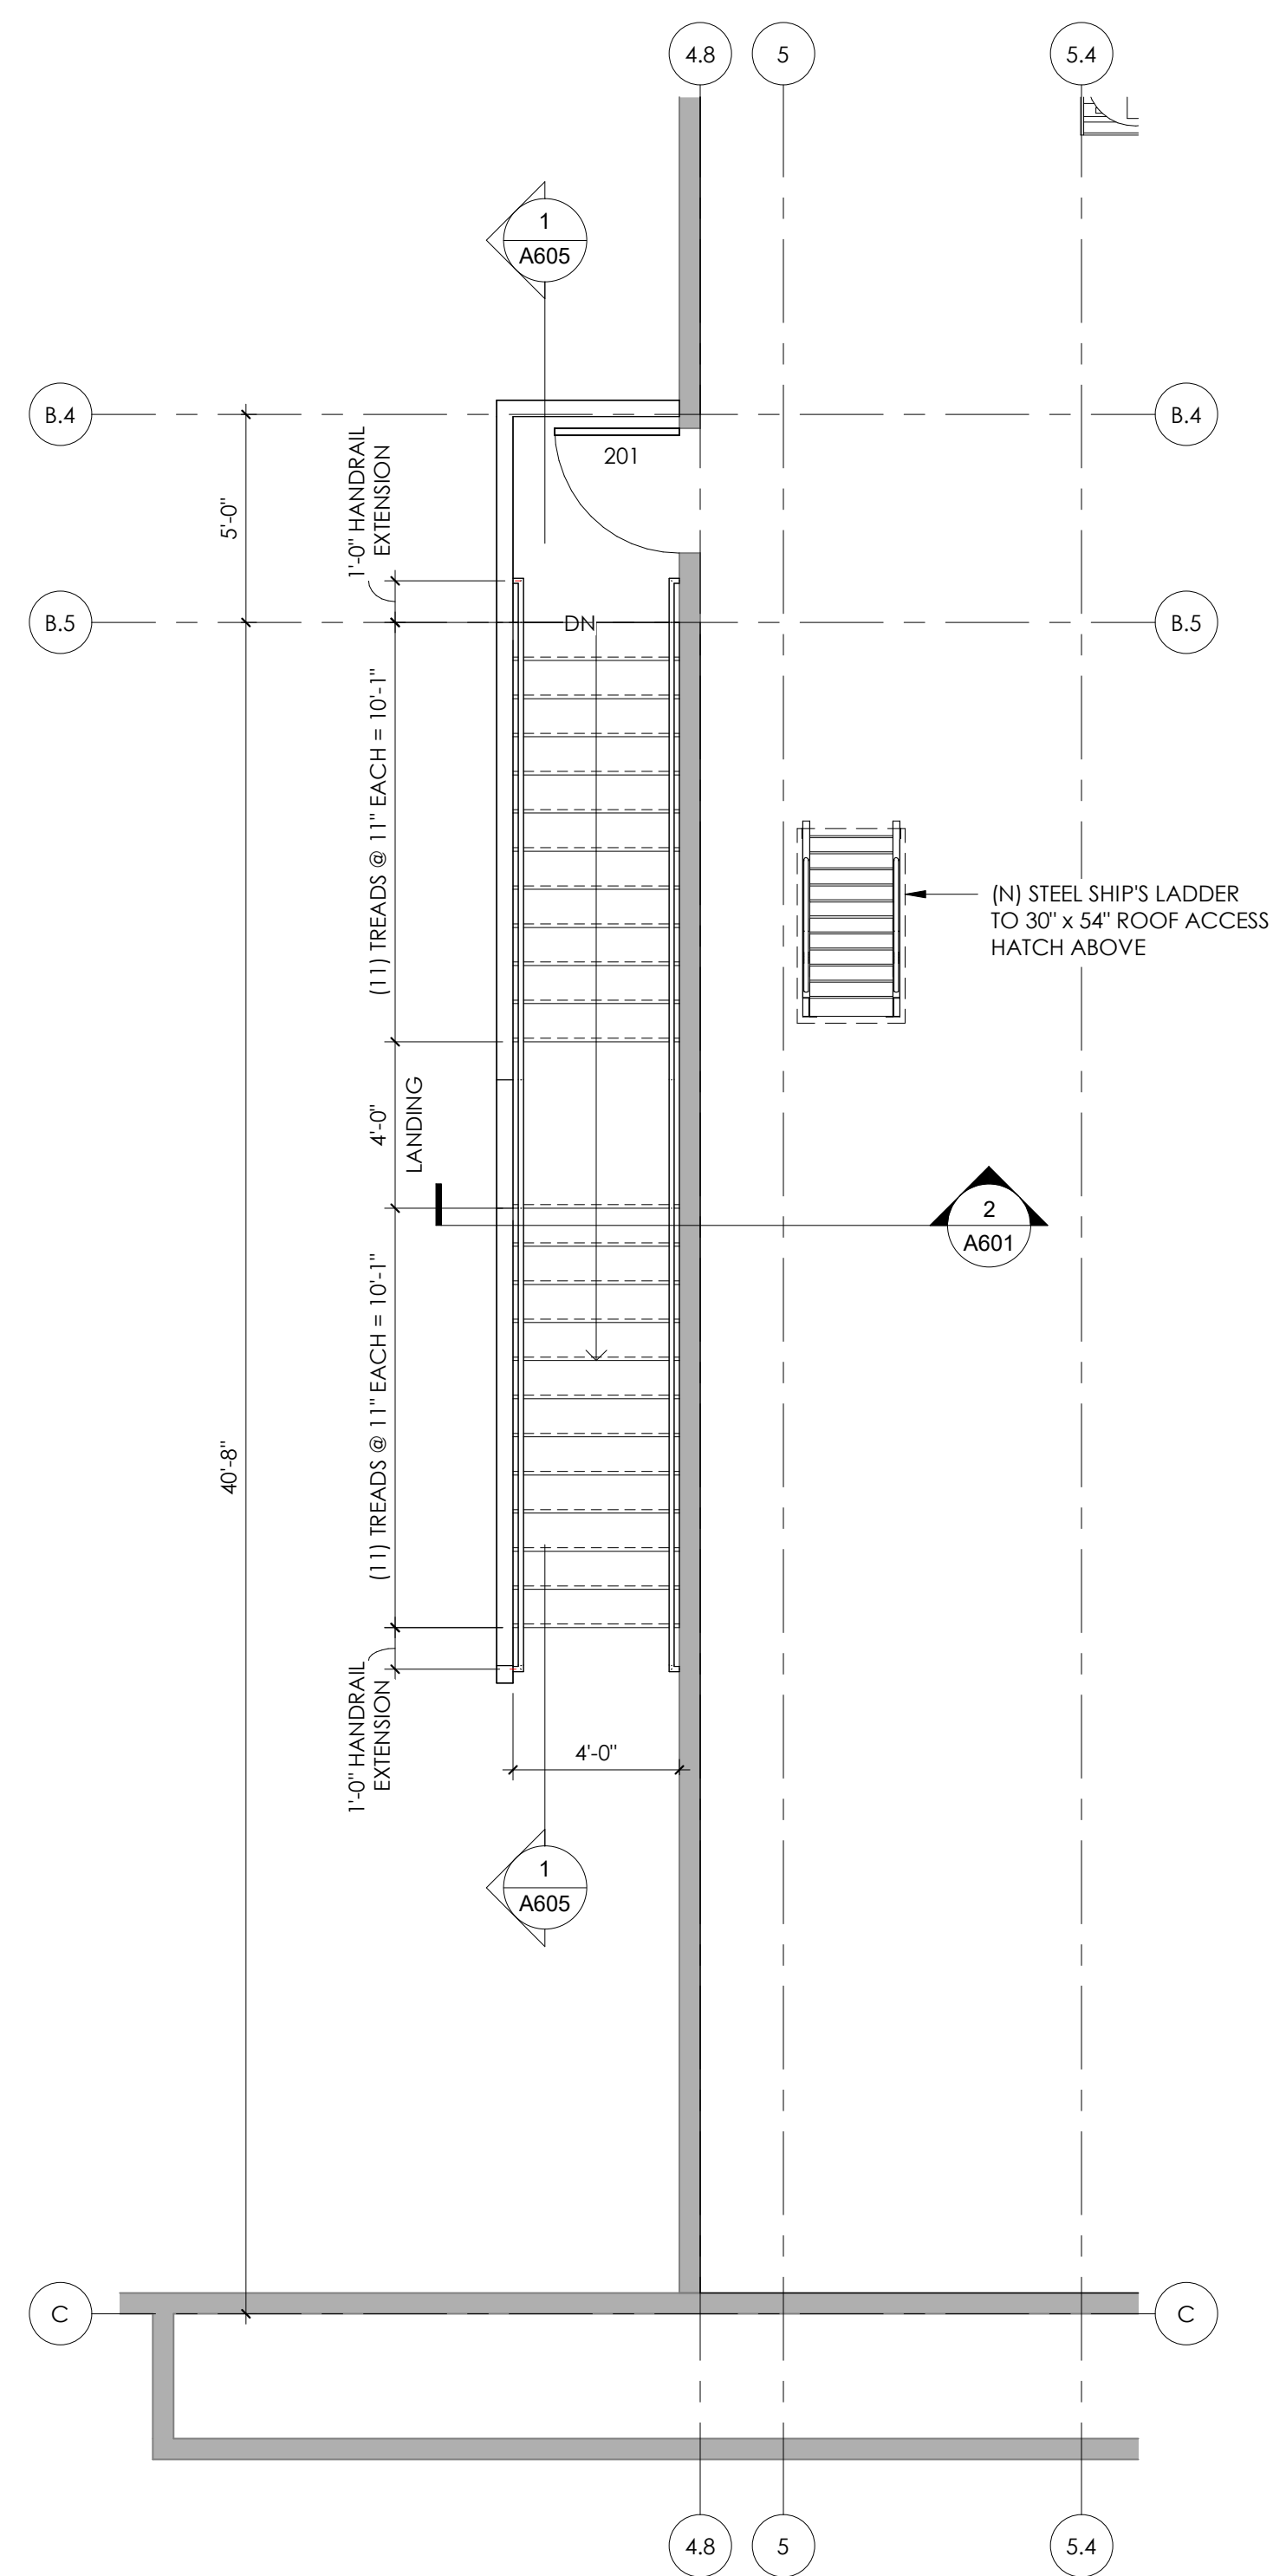


2/ ENLARGED STAIR @ MECH PLATFORM

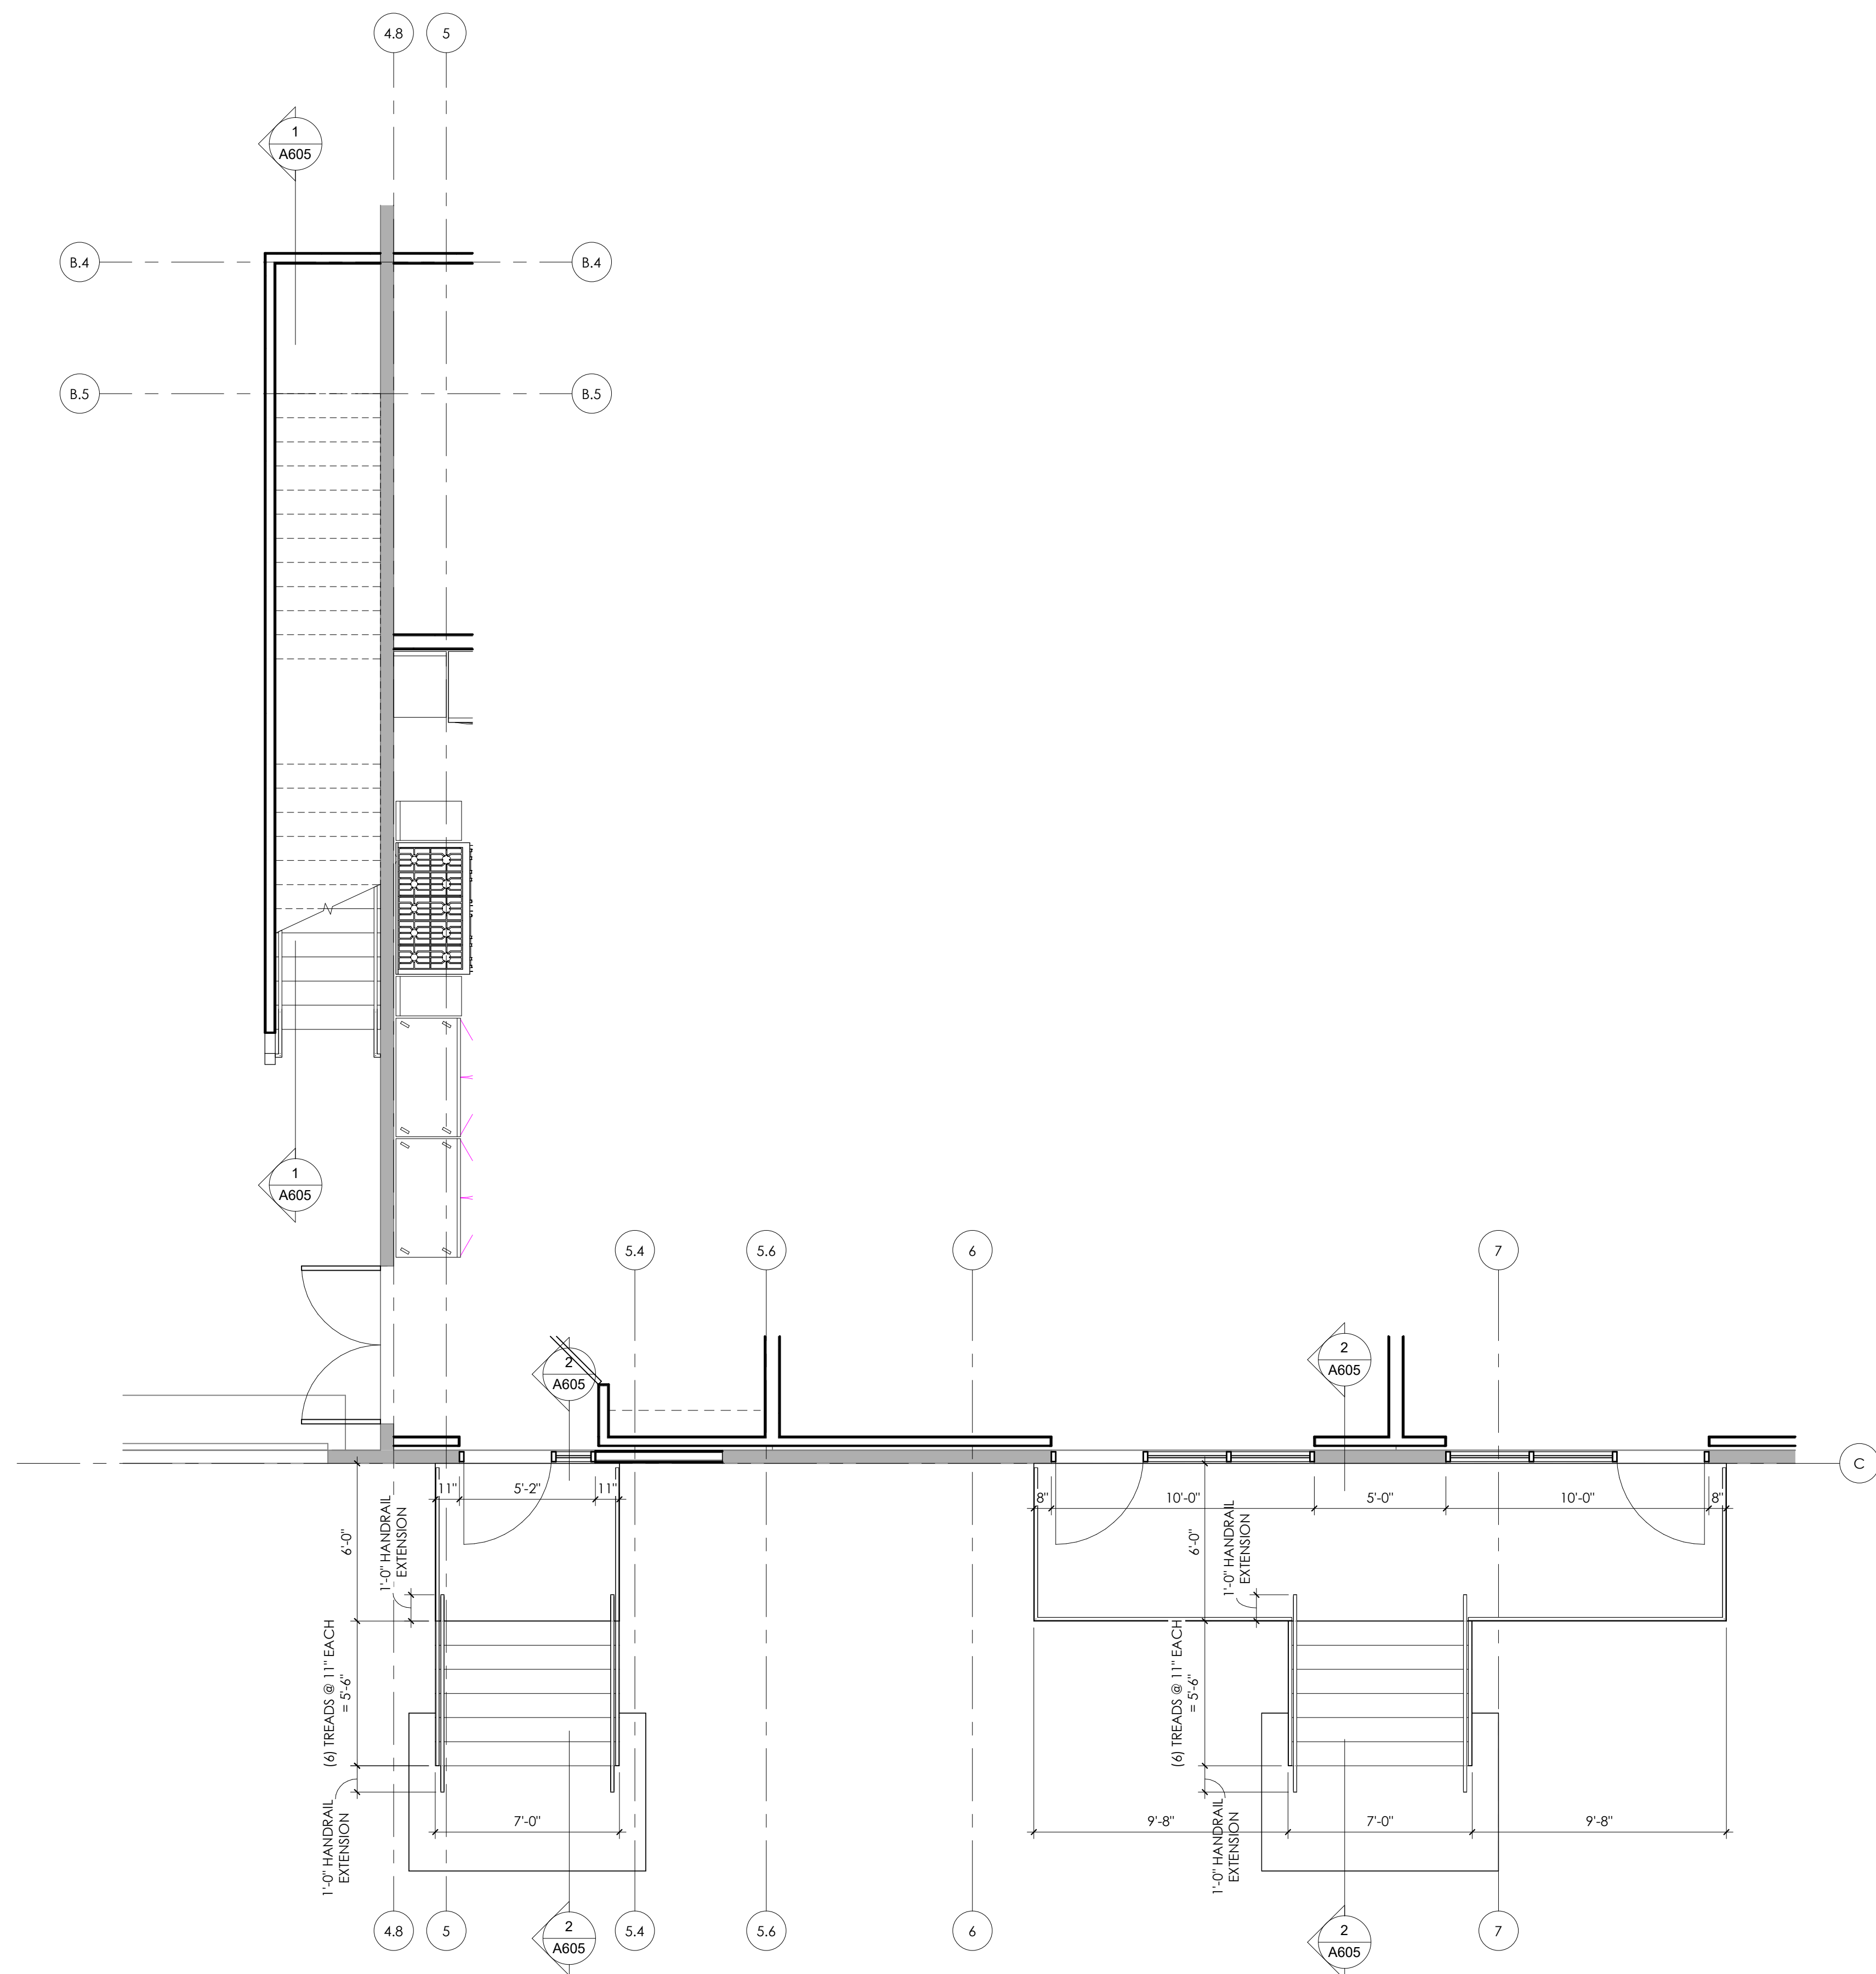

1 / ENLARGED STAIRS PLAN

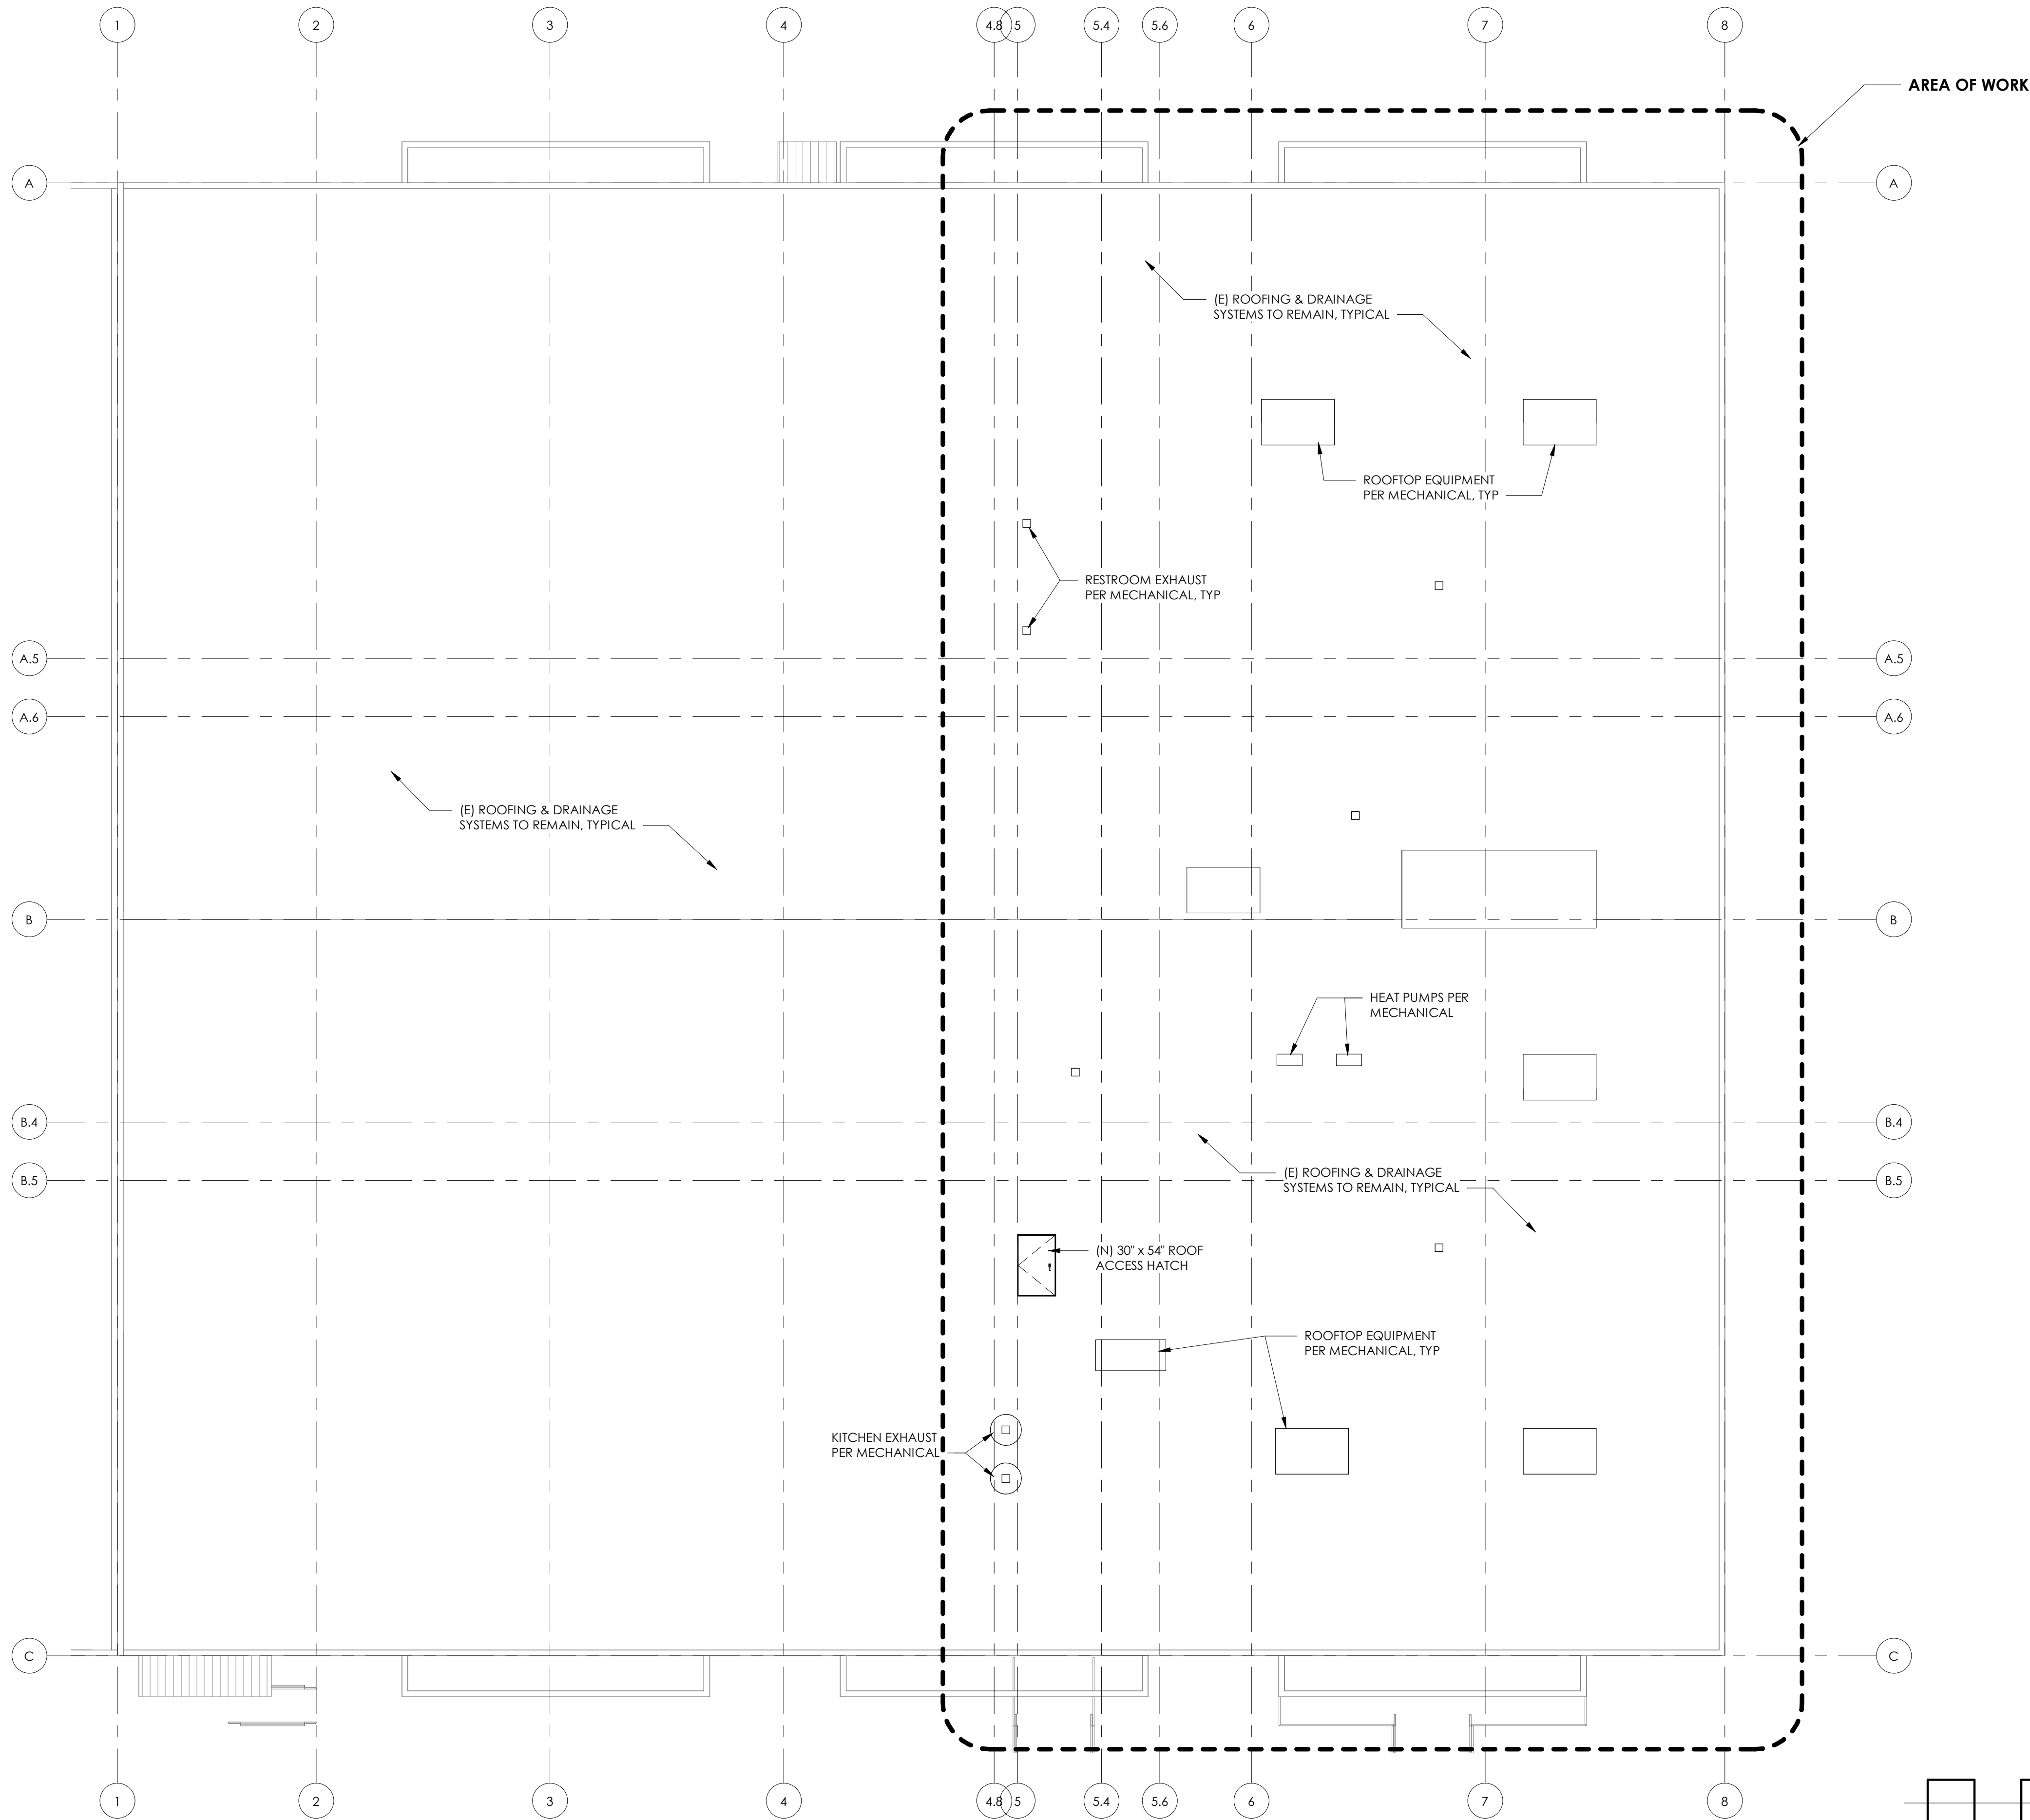

1 / ROOF PLAN
scale: 1/8" = 1'-0"

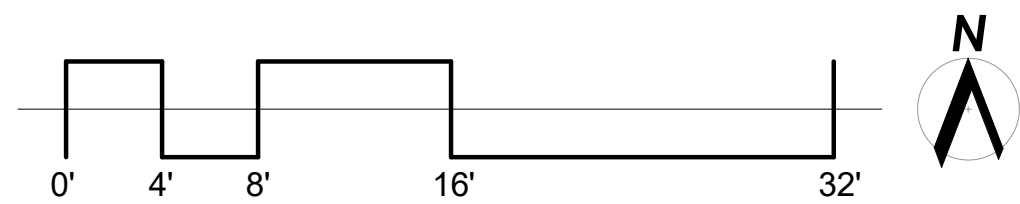





CEILING PLAN LEGEND

- SUSPENDED GYPSUM BOARD CEILING
- 2' x 4' SUSPENDED ACOUSTICAL CEILING TILES
MFR: ARMSTRONG
MODEL: FINE FISSURED
ANGULAR TEGULAR, 15/16" GRID
RECESSED T-BAR, 2x4 "SECOND LOOK"
- CEILING TYPE (IF SHOWN)
CEILING HEIGHT
(DIMENSION INDICATES ABOVE FINISHED FLOOR, UNO)
11'-0"
- EXIT SIGN
- SMOKE ALARM
- CARBON MONOXIDE DETECTOR
- SURFACE MOUNT DOWNLIGHT
- DECORATIVE PENDANT LIGHT
- EXTERIOR DECORATIVE WALL SCONCE
- SURFACE MOUNT LINEAR FIXTURE
- WALL MOUNT LINEAR FIXTURE
- UNDER CABINET FIXTURE
- WALL-MOUNT VANITY FIXTURE
- LINEAR DIRECT / INDIRECT
WALL-MOUNT UP/DOWN FIXTURE
- EXHAUST FAN
- RANGE EXHAUST HOOD
- 2x4 LED LIGHT FIXTURE
- 2x2 LED LIGHT FIXTURE
- 2x2 MECHANICAL SUPPLY
- 2x2 MECHANICAL RETURN

1 / REFLECTED CEILING PLAN
scale: 1/8" = 1'-0"

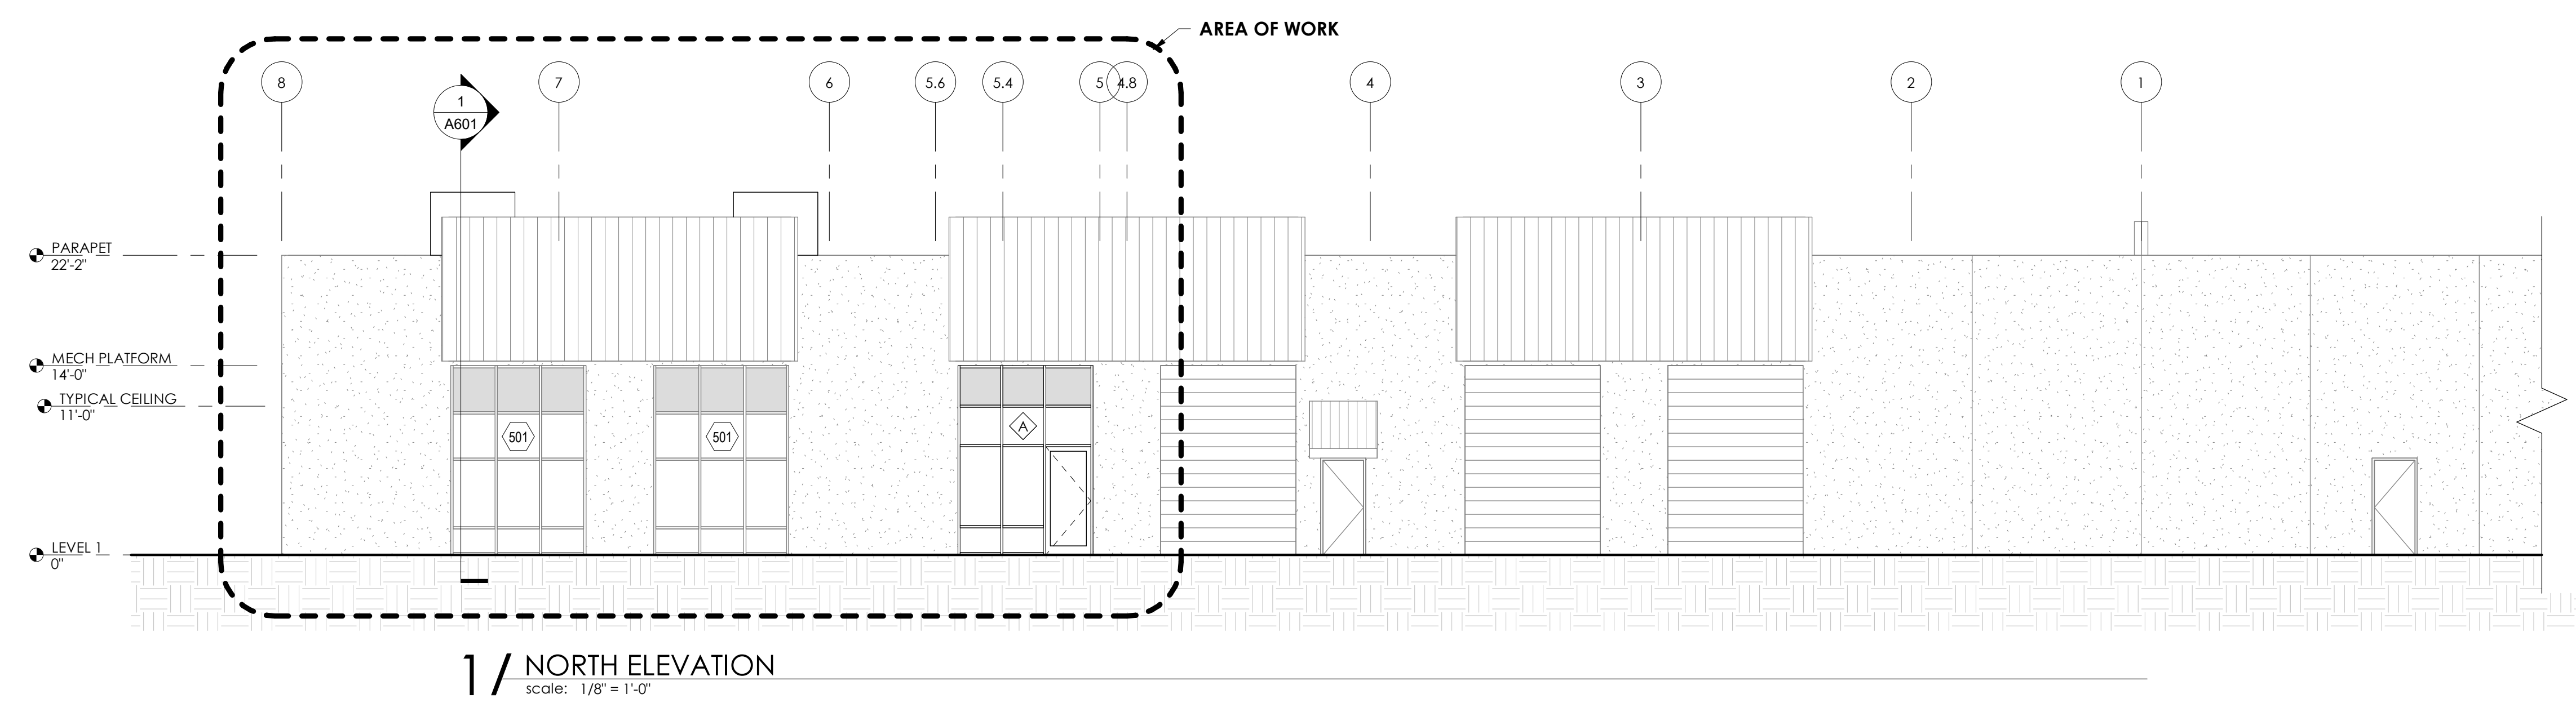

1 / NORTH ELEVATION
scale: 1/8" = 1'-0"

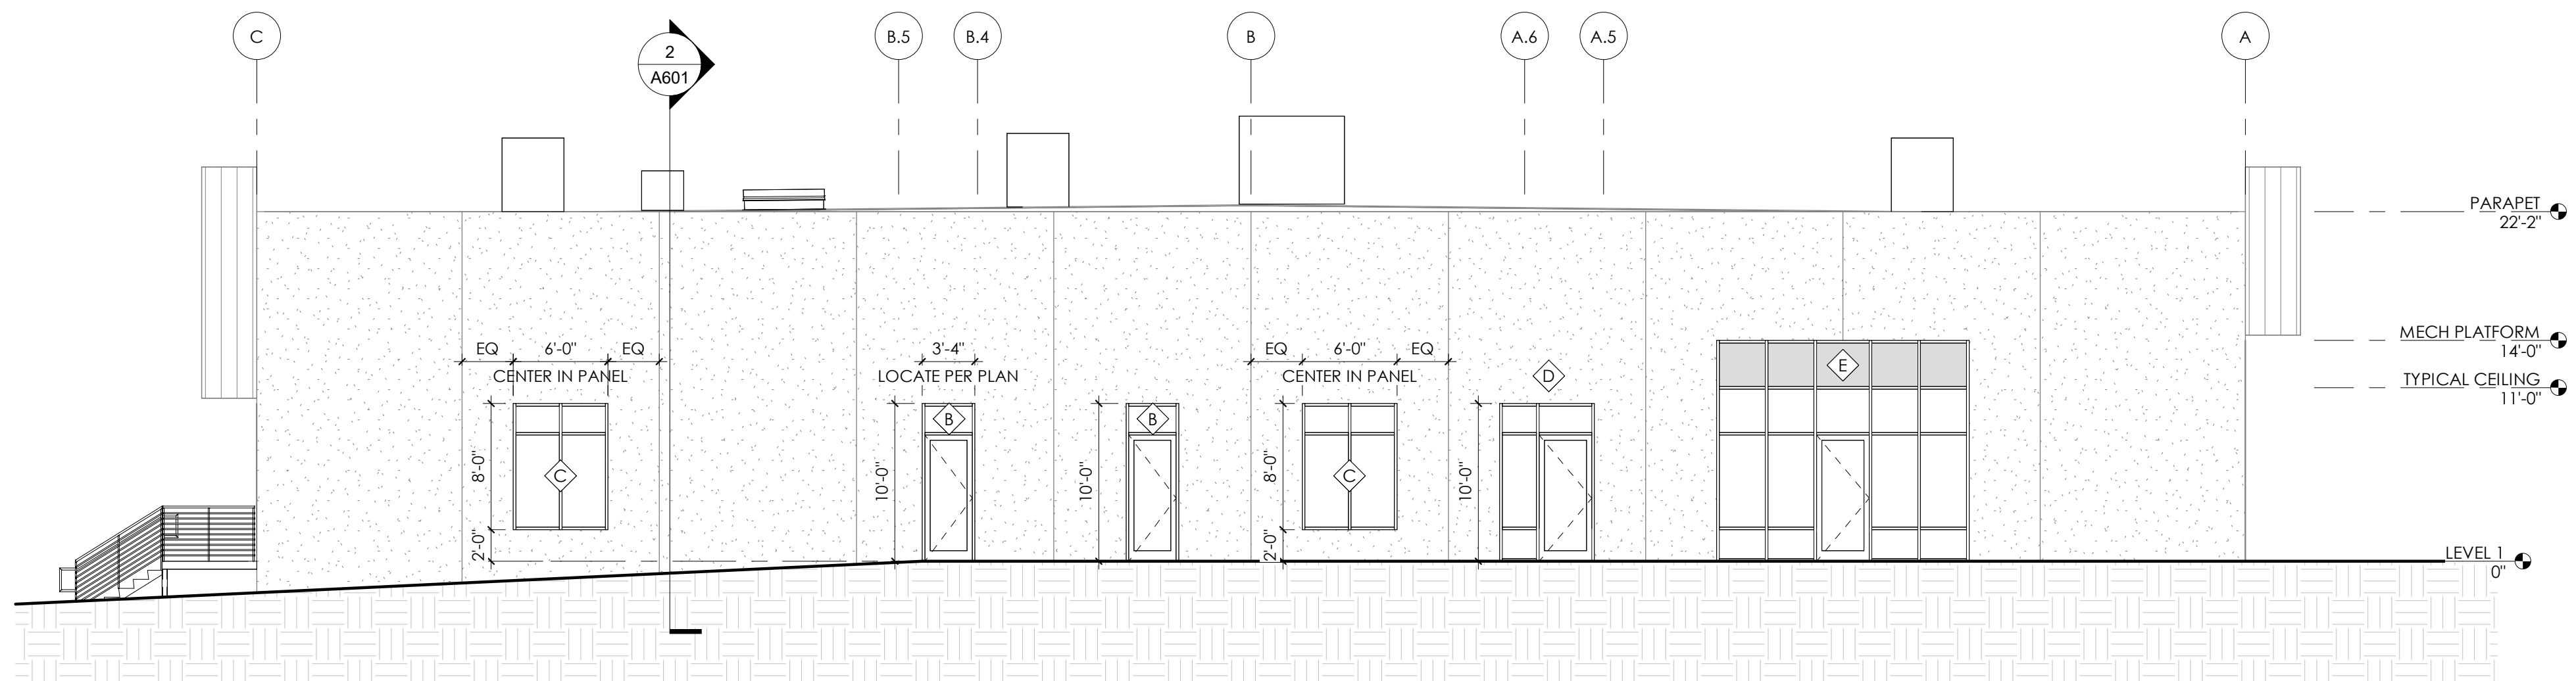


2 / EAST ELEVATION
scale: 1/8" = 1'-0"

ELEVATION GENERAL NOTES


1. SEE SHEET A701 FOR STOREFRONT TYPES

ELEVATION KEY NOTES


501	(E) STOREFRONT SYSTEM TO REMAIN
-----	---------------------------------

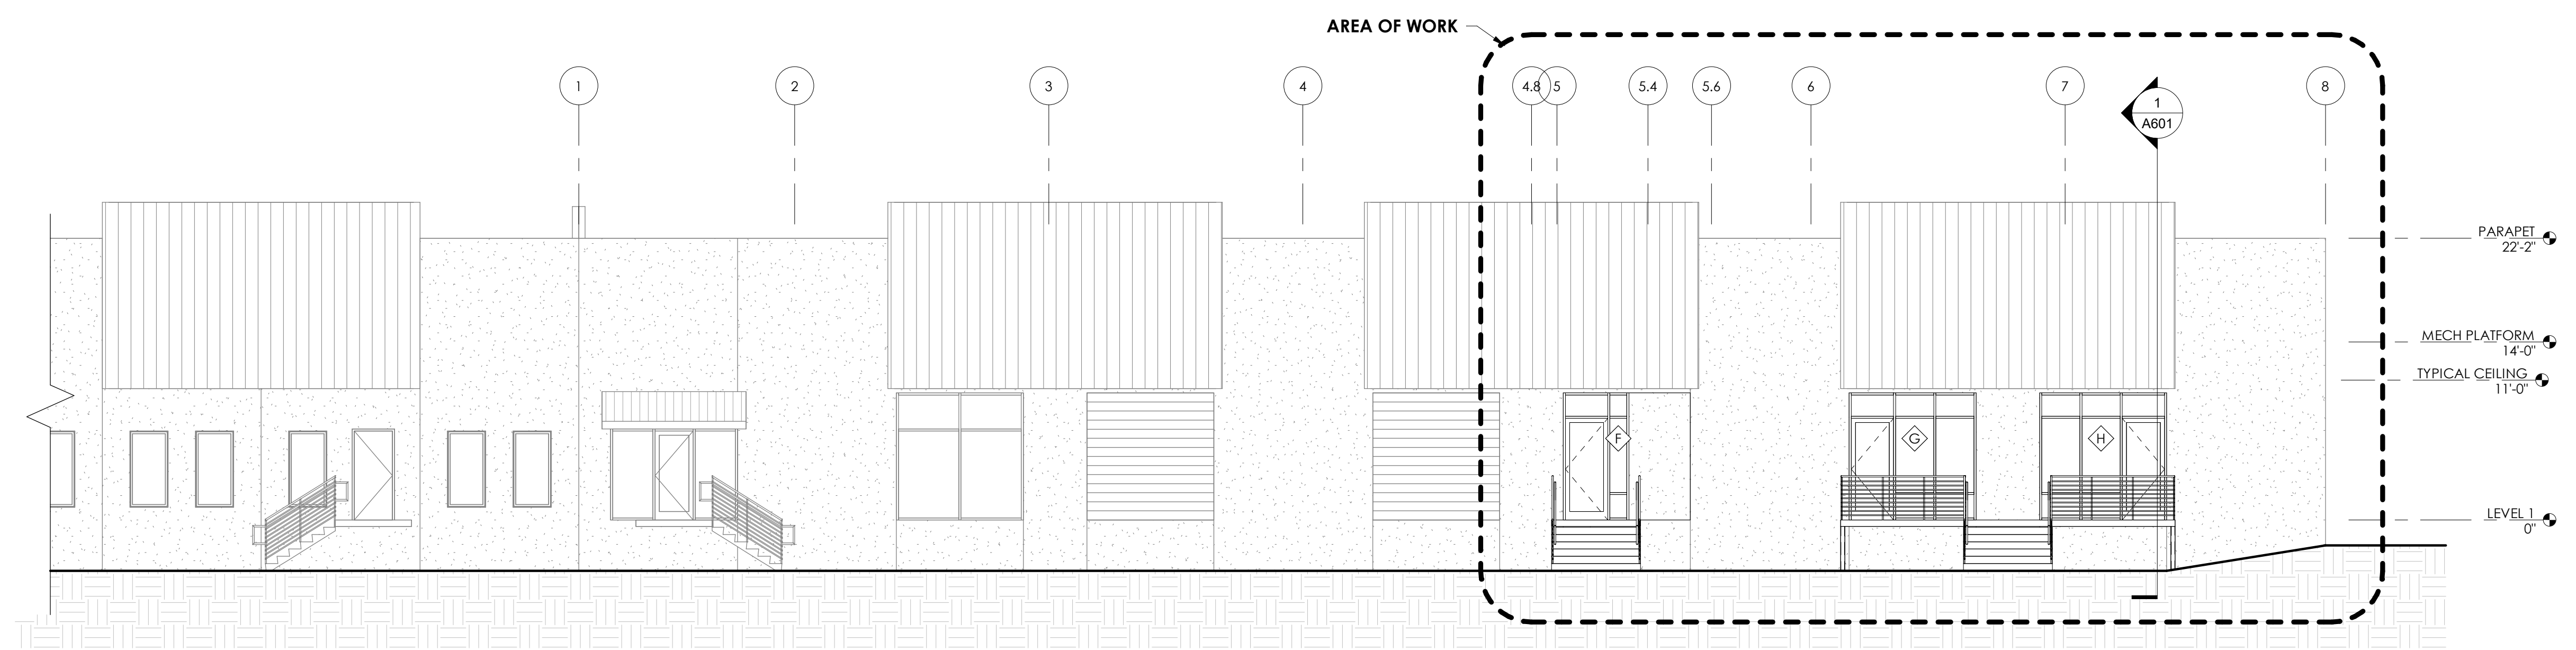


3 / SOUTH ELEVATION
scale: 1/8" = 1'-0"

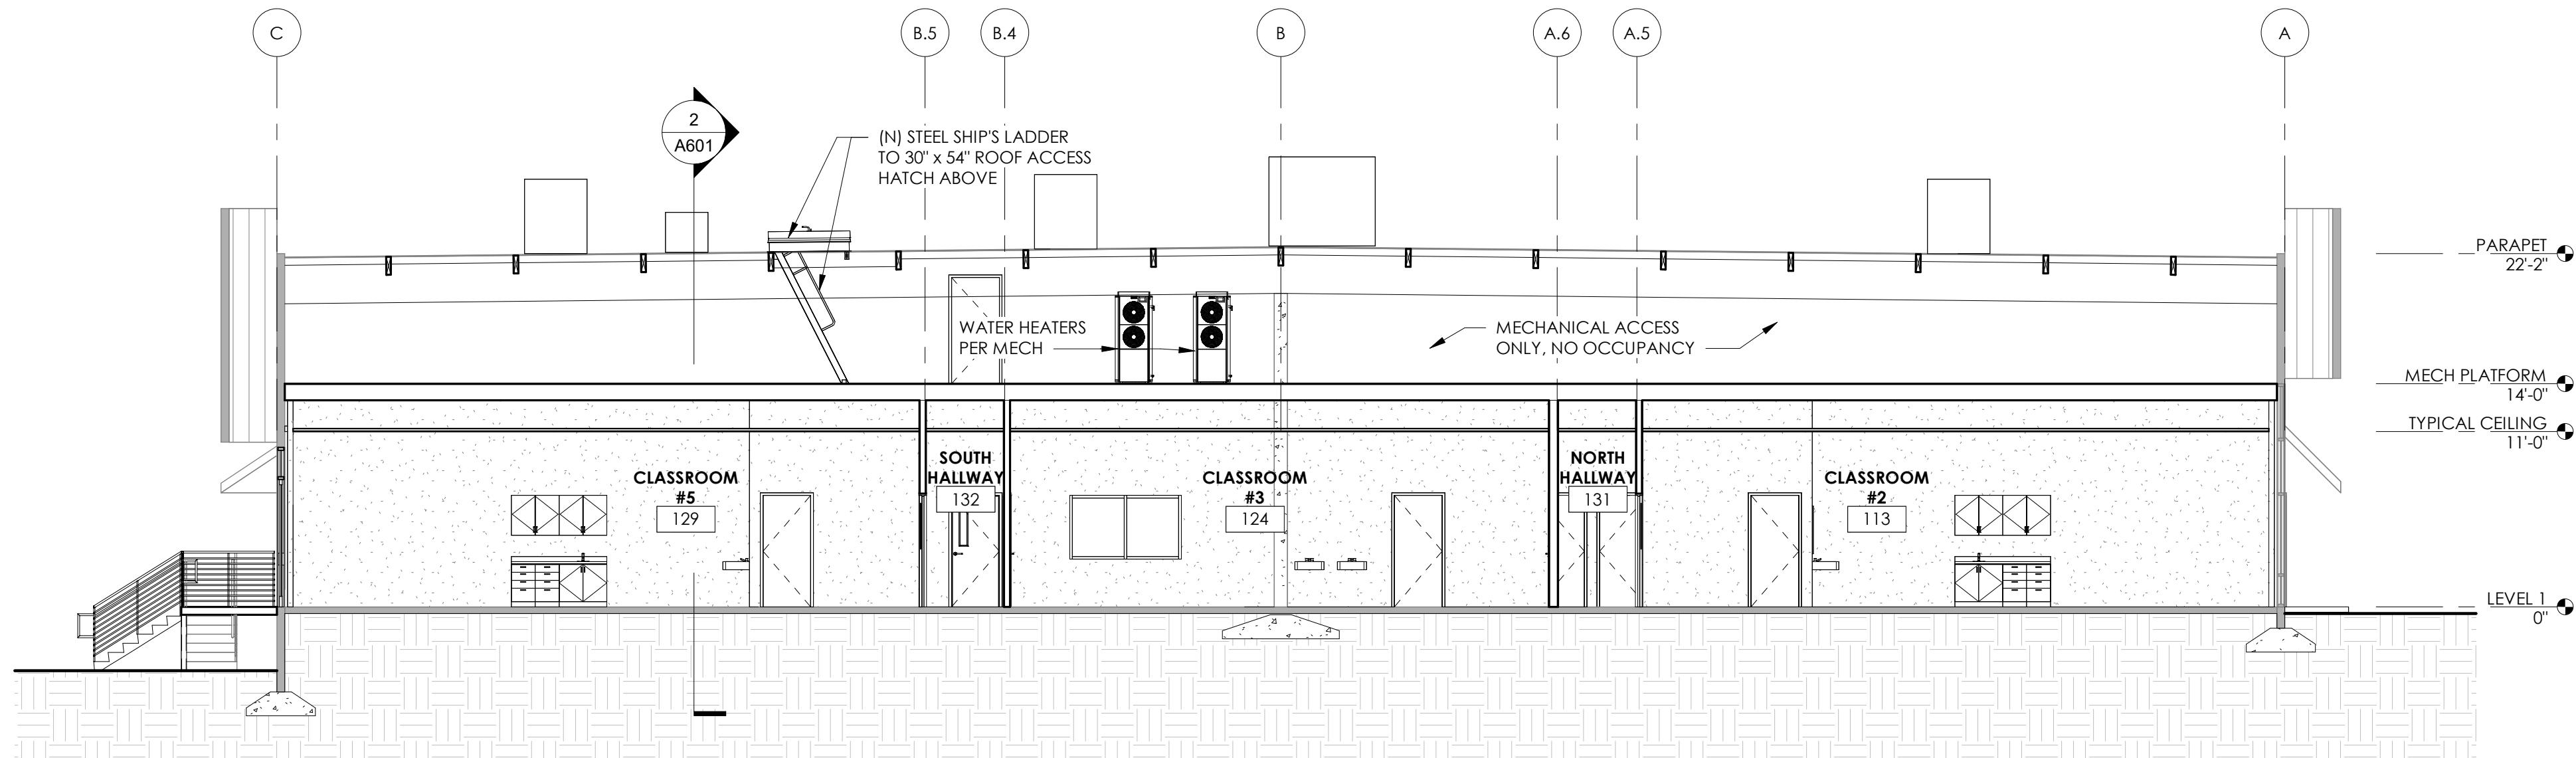


1 / BUILDING SECTION 1
scale: 1/8" = 1'-0"

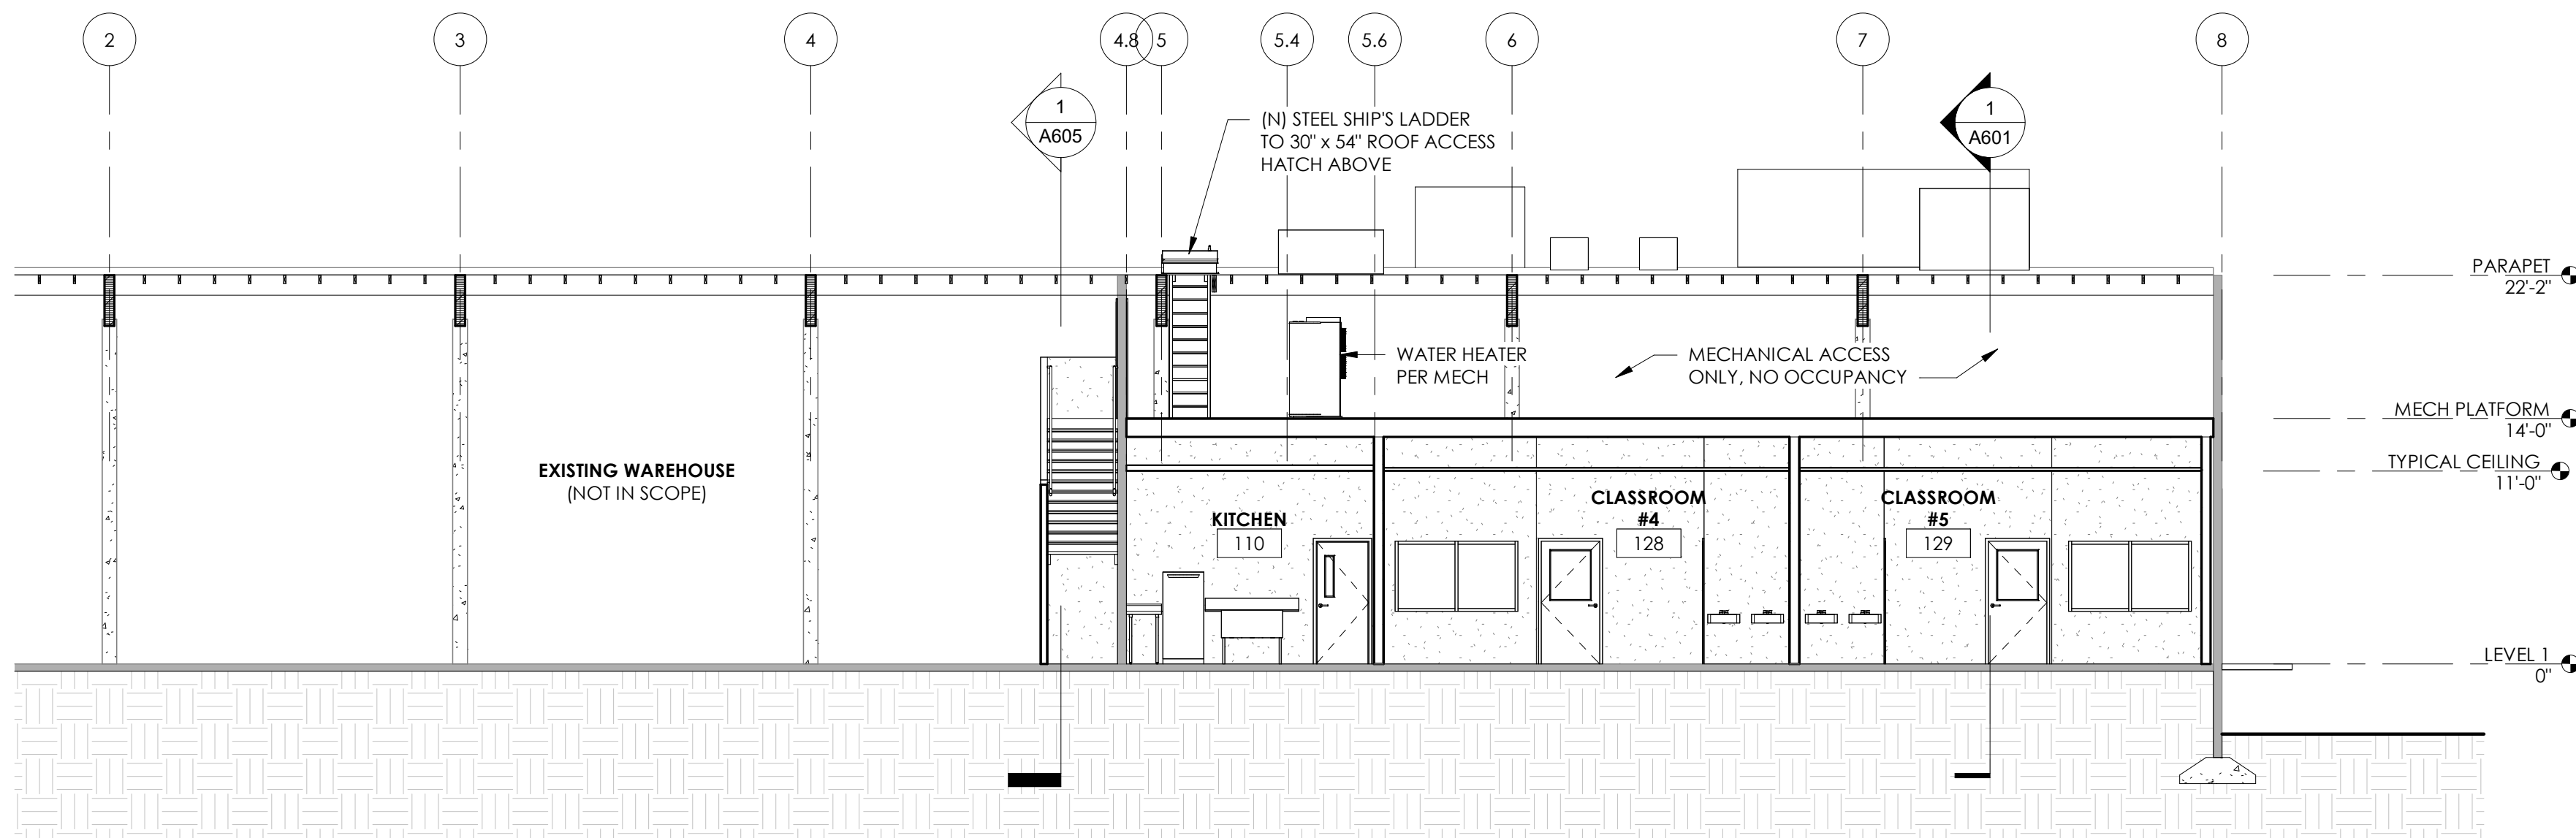


2 / BUILDING SECTION 2
scale: 1/8" = 1'-0"

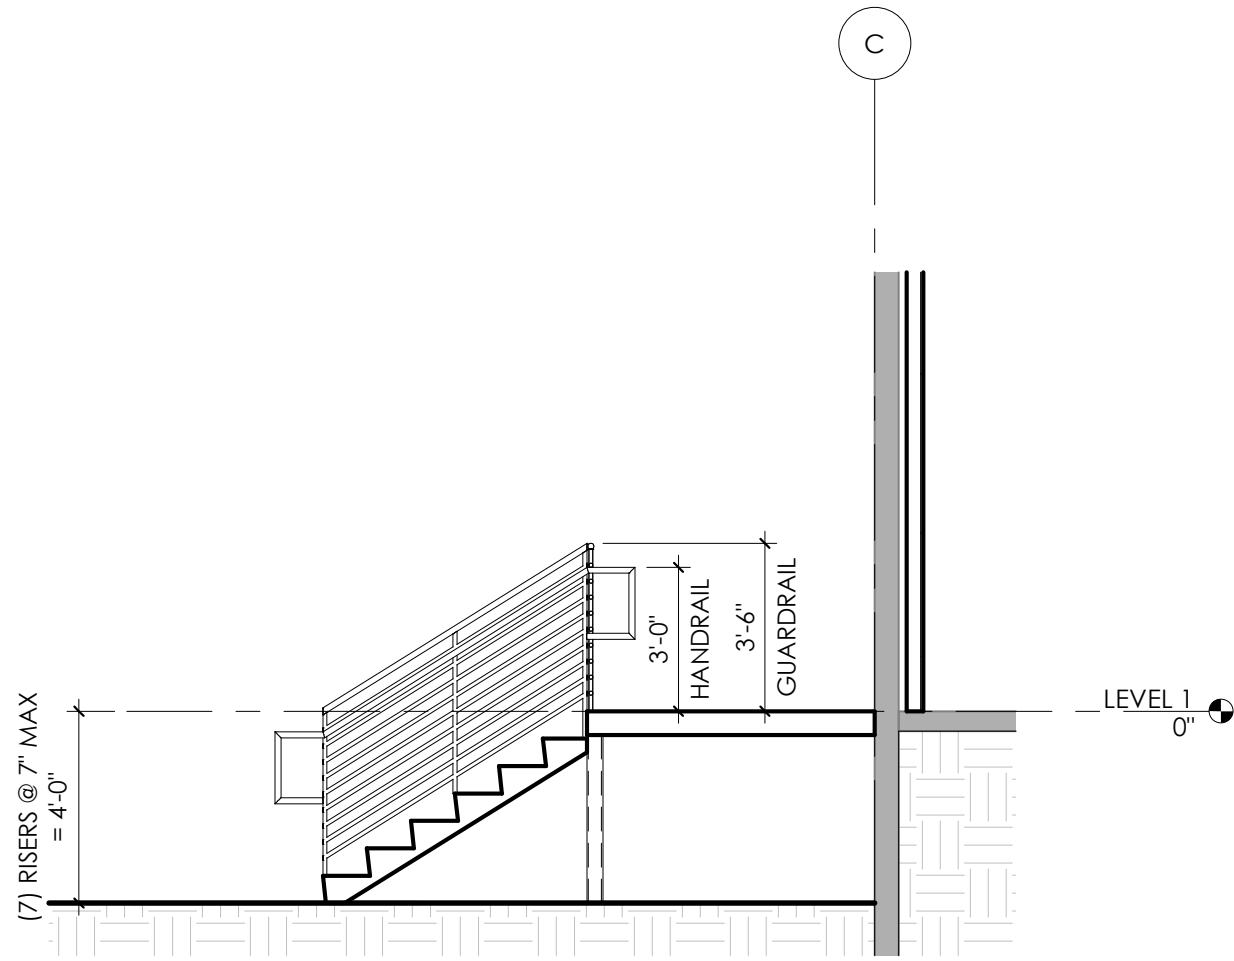

2/ EXTERIOR STAIR SECTION
scale: 1/4" = 1'-0"

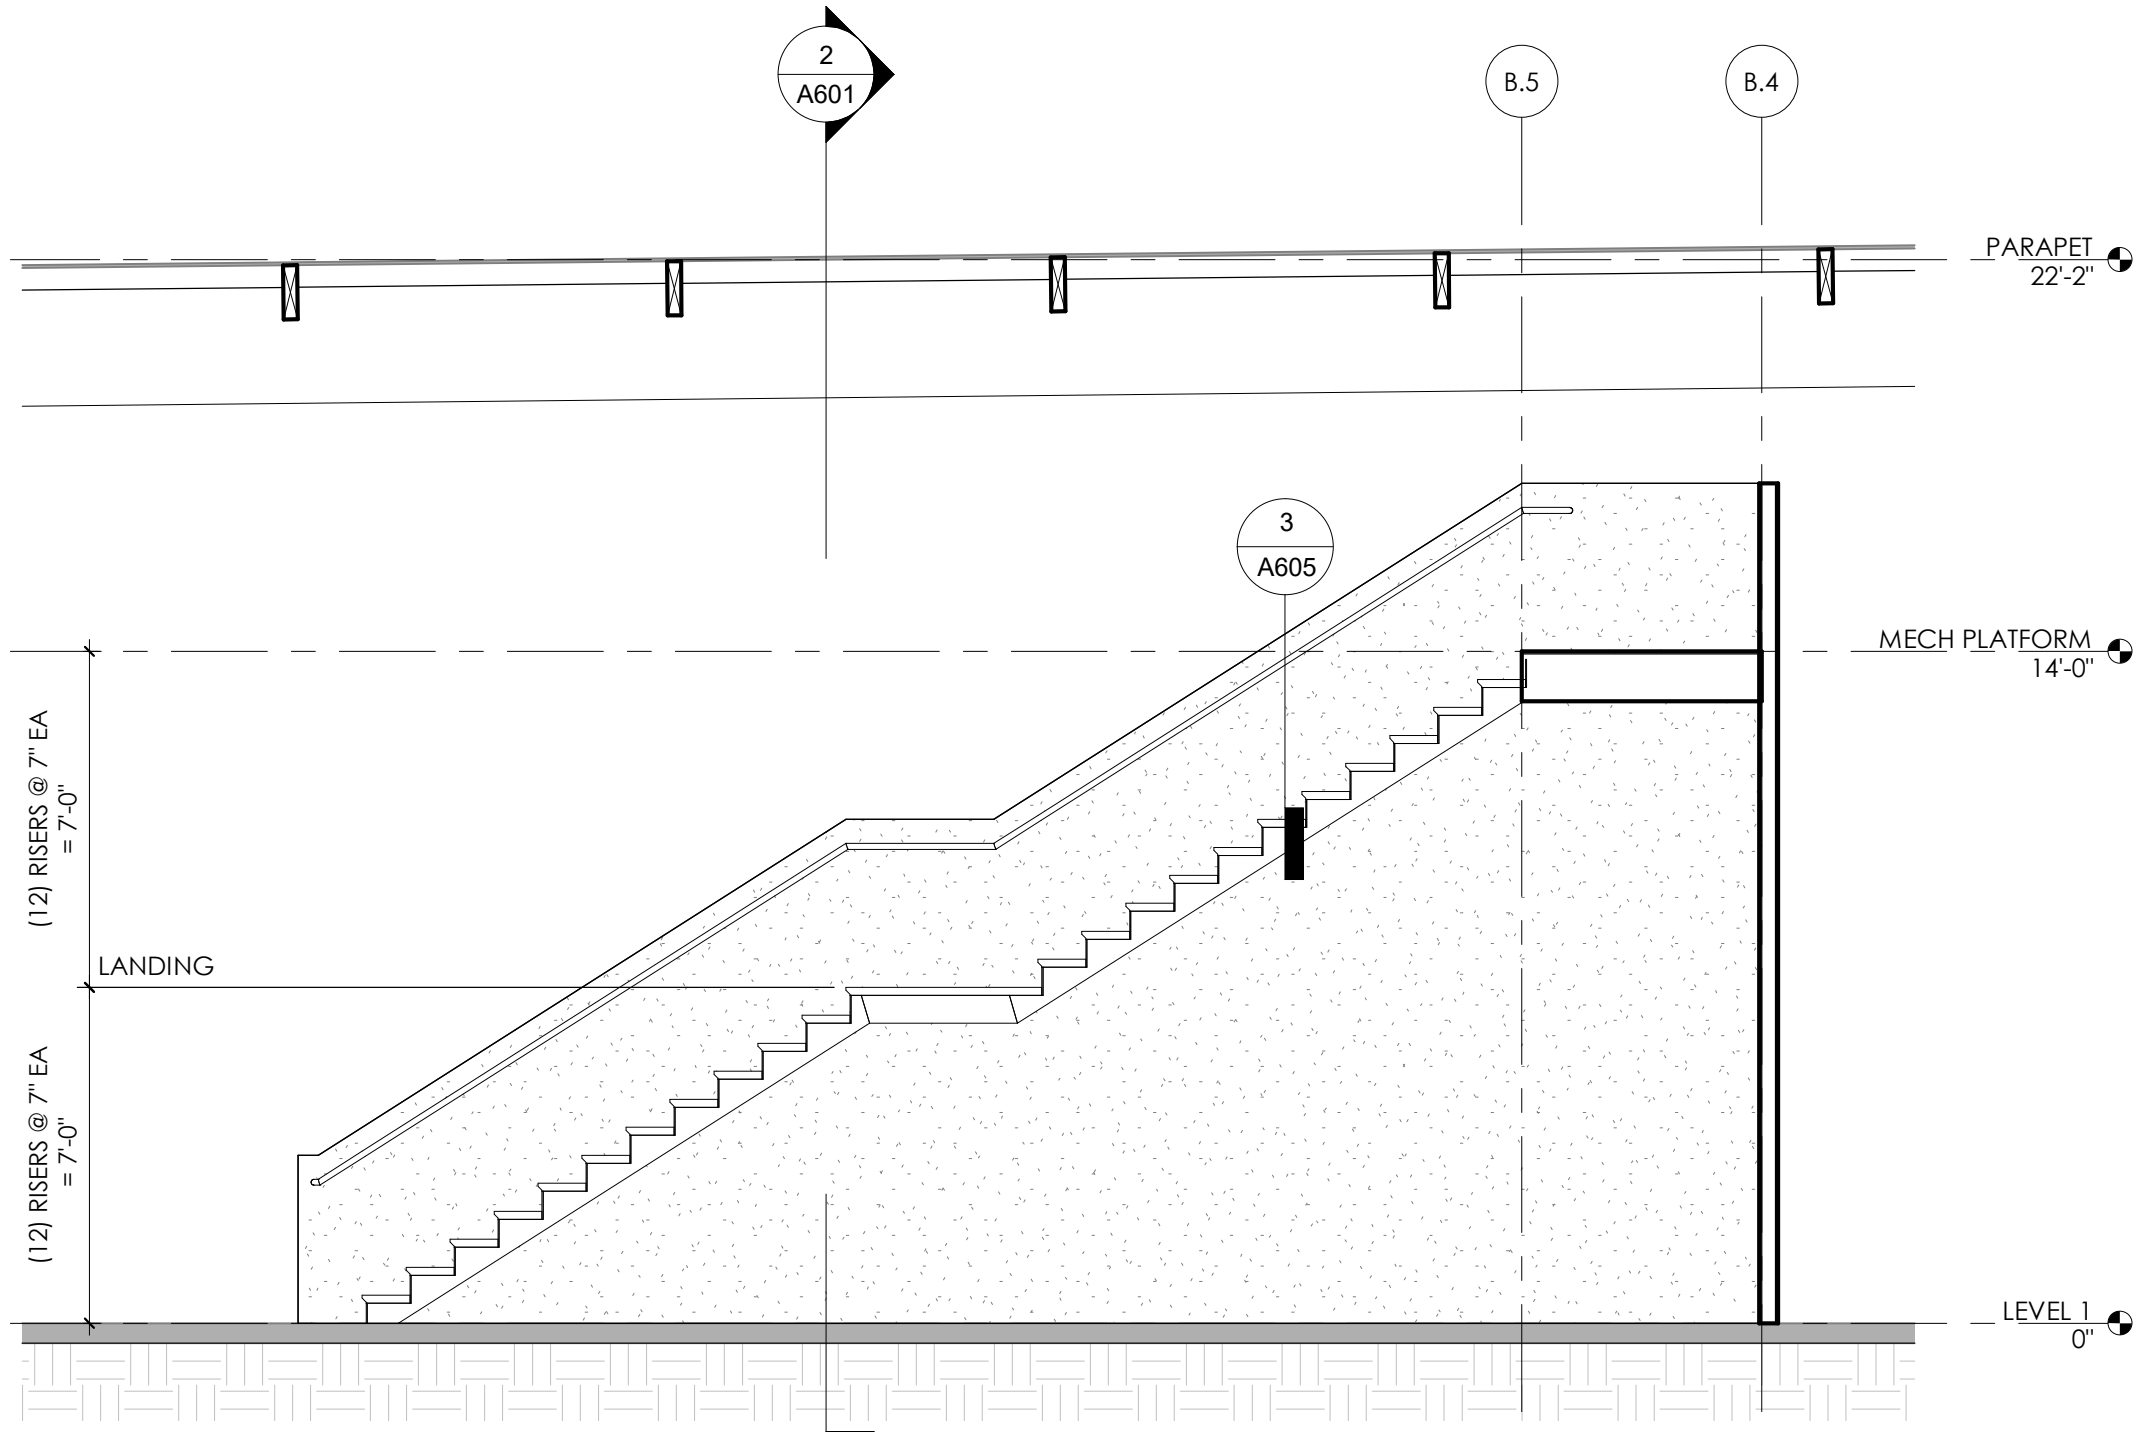

1/ INTERIOR STAIR SECTION
scale: 1/4" = 1'-0"

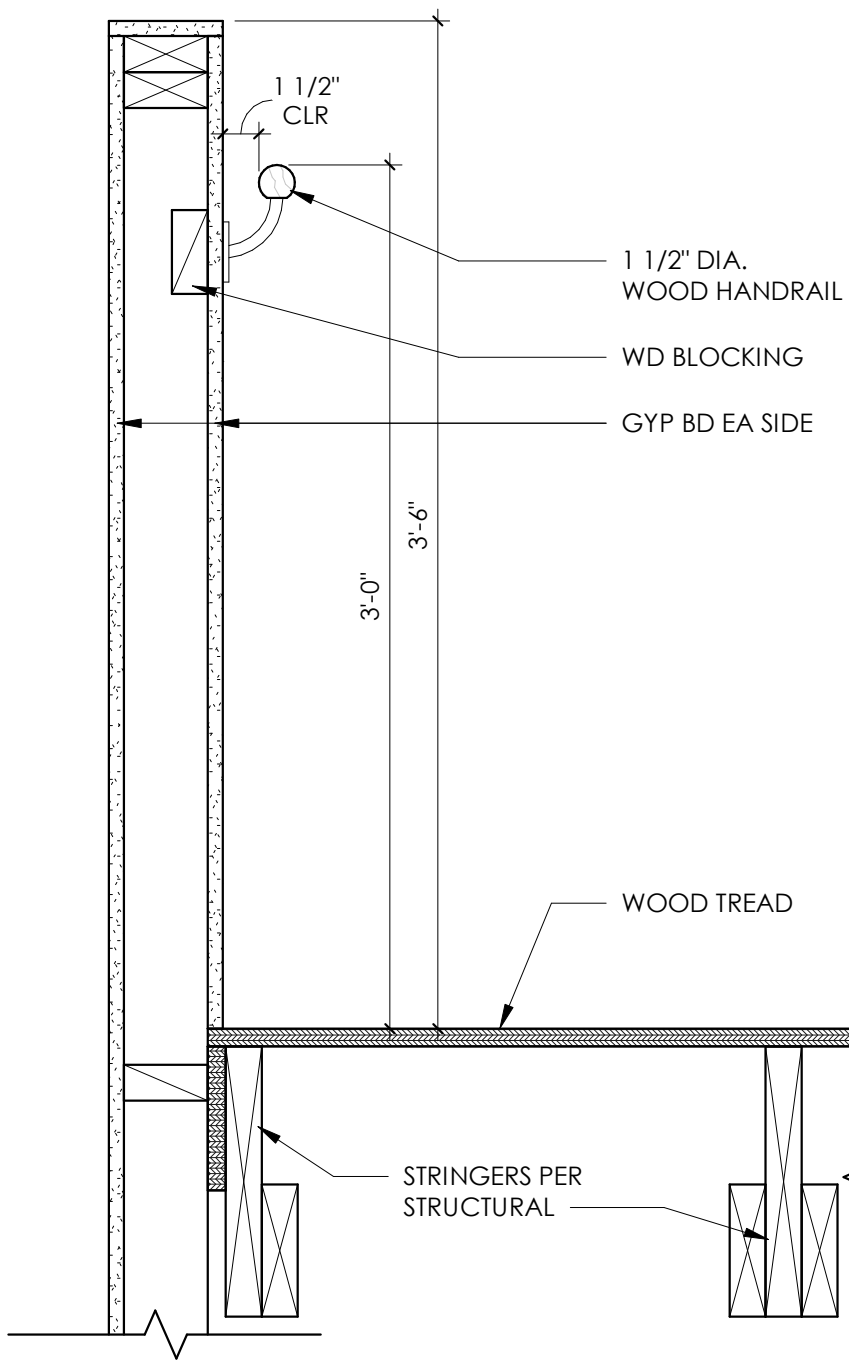


3/ INTERIOR GUARD/HANDRAIL
scale: 1 1/2" = 1'-0"

INTERIOR RELITE TYPES

RELITE NOTES:

1. KNOCK-DOWN FRAMES TO BE 4-PIECE TIMELY "BROWNSTONE"
2. NON-INSULATED, CLEAR GLAZING

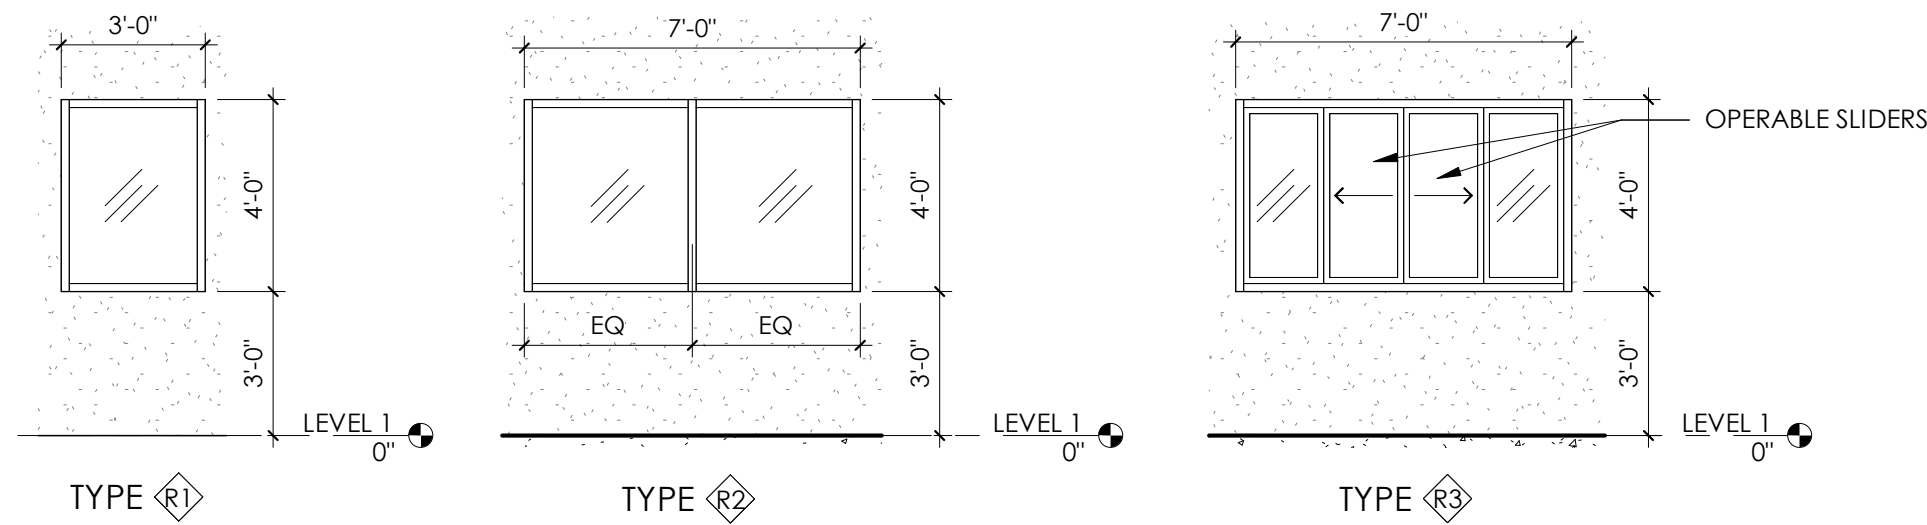


STOREFRONT TYPES

GENERAL STOREFRONT & GLAZING NOTES:

ALUMINUM STOREFRONT SYSTEM, THERMALLY BROKEN W/ LOW-E INSULATED GLAZING AND ARGON GAS. PENETRATION PRODUCTS SHALL BE LABELED WITH NFRC U-FACTOR, SHGC, VT AND LEAKAGE RATING. STOREFRONT FRAMING W/ FACTORY DARK BRONZE ANODIZED FINISH TO MATCH EXISTING BUILDING


FIXED UNITS: U-0.34 SHGC 0.38 MAX
ENTRANCE DOORS: U-0.60 SHGC 0.33 MAX

T = TEMPERED SAFETY GLAZING

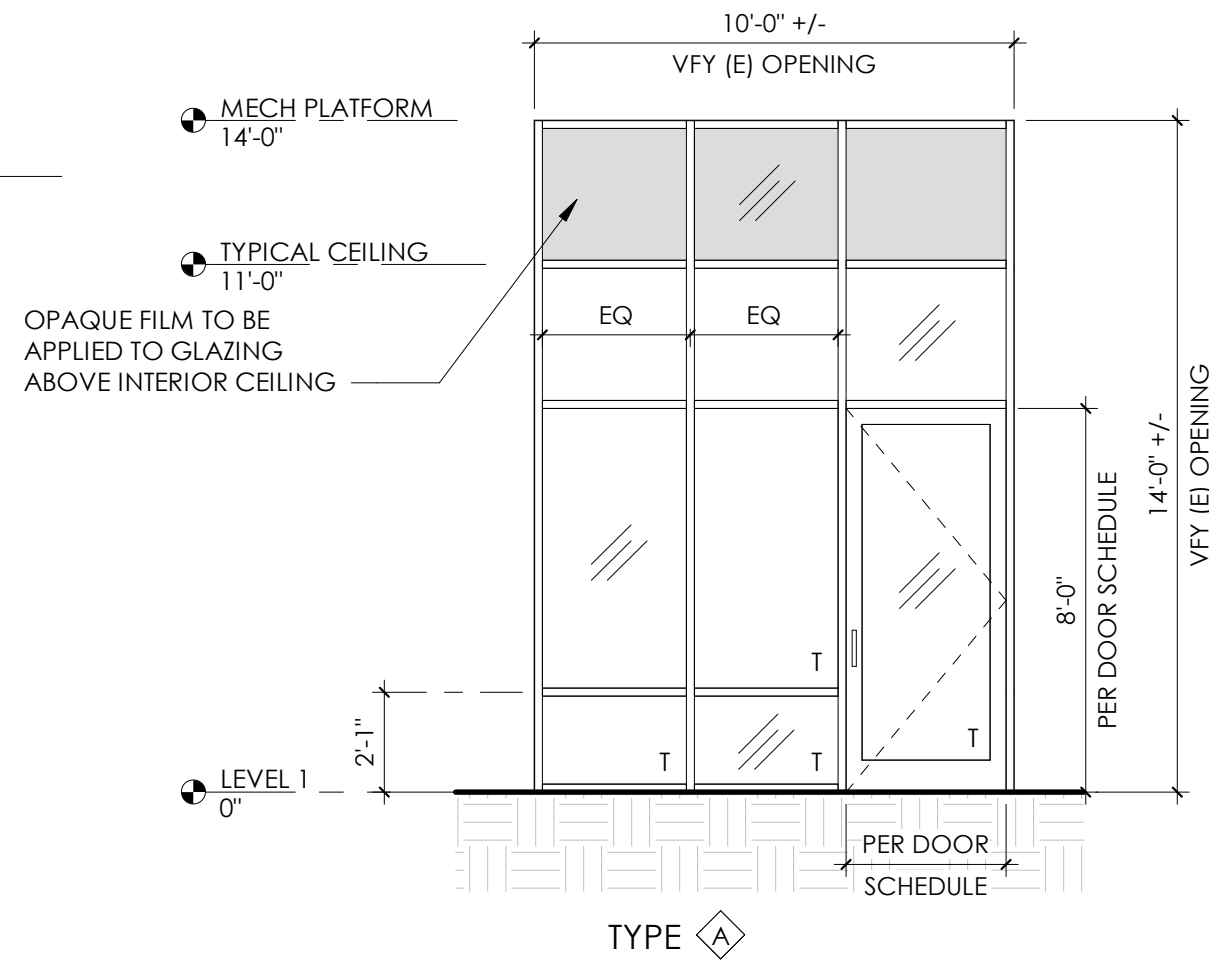


NORTH ELEVATION STOREFRONT

scale: 1/4" = 1'-0"

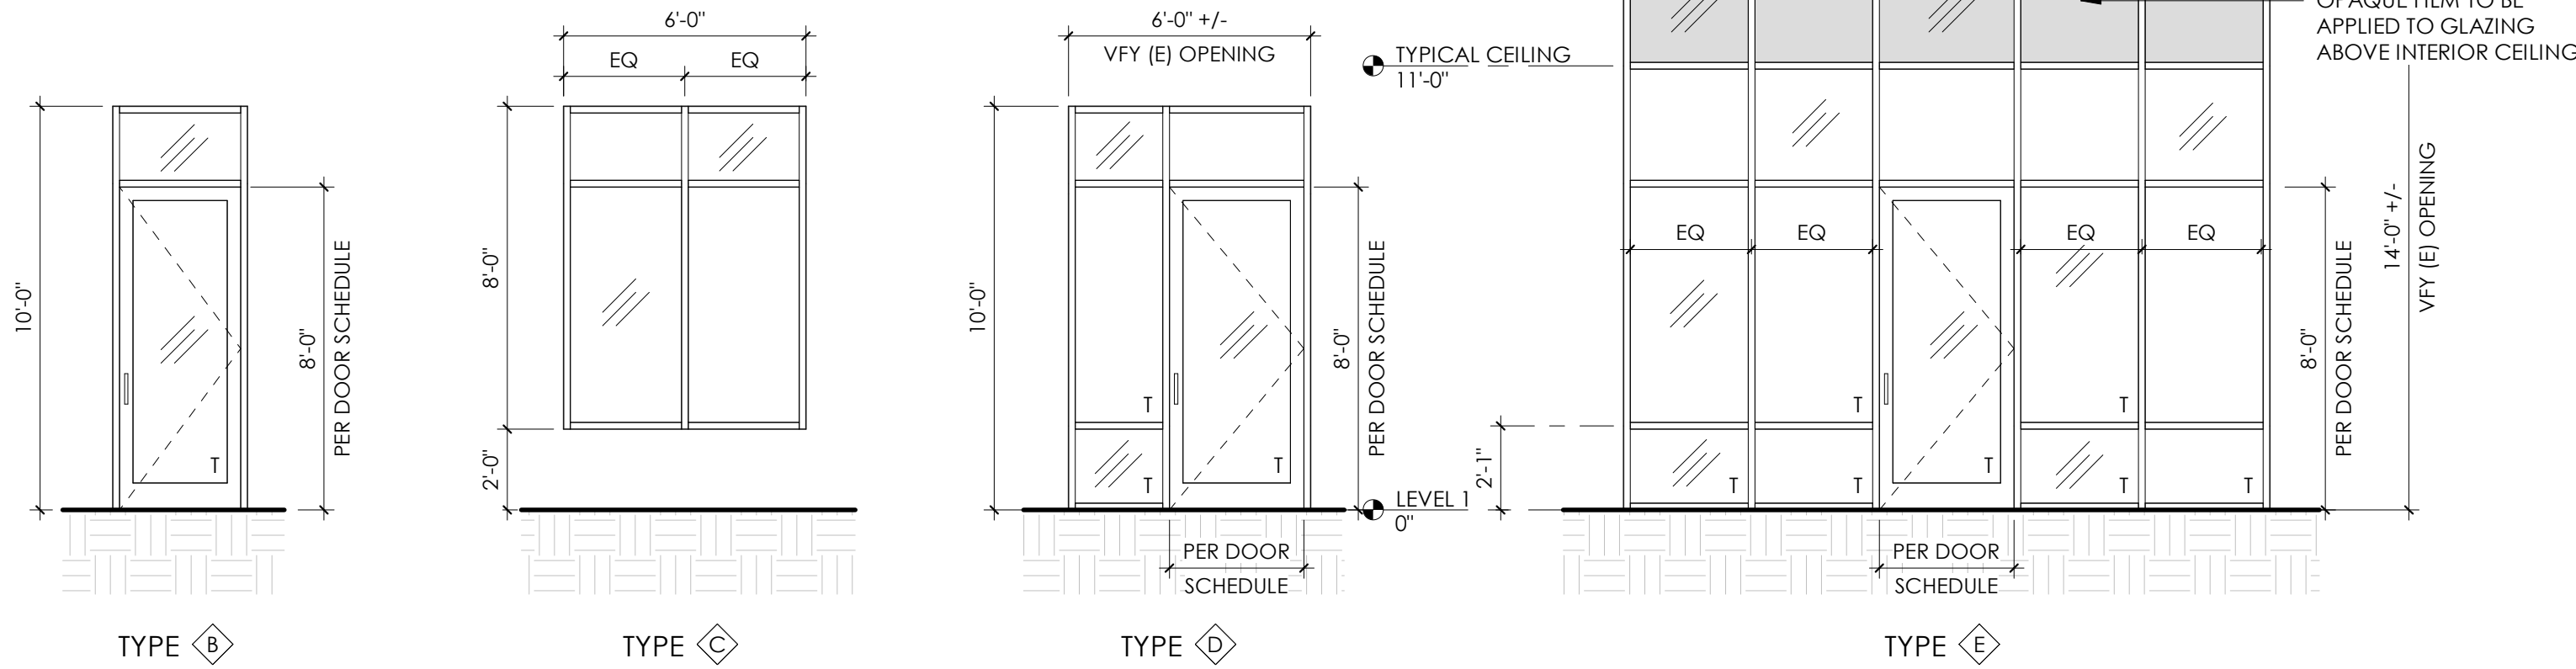

EAST ELEVATION STOREFRONT TYPES

scale: 1/4" = 1'-0"

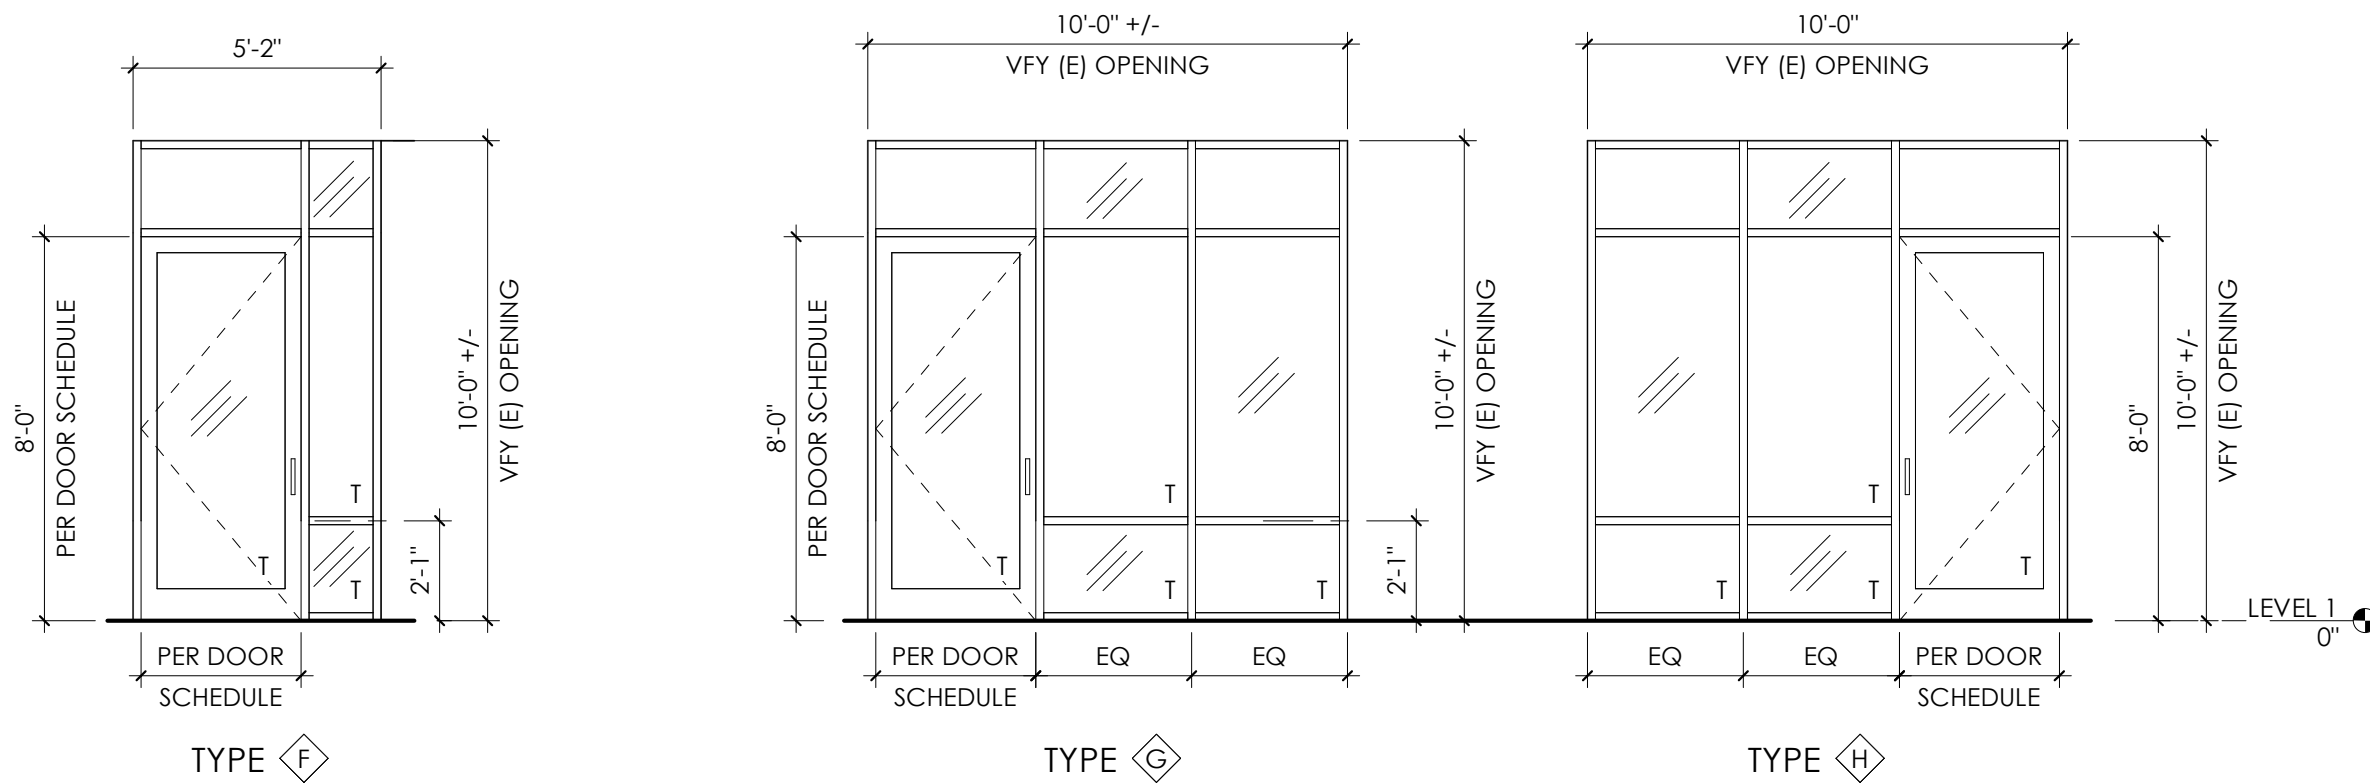

SOUTH ELEVATION STOREFRONT TYPES

scale: 1/4" = 1'-0"

DOOR AND FRAME SCHEDULE											
MARK	LOCATION	TYPE	DOOR				FRAME		RATING	HARDWARE GROUP	NOTE
			WIDTH	HEIGHT	MATERIAL	FINISH	MATERIAL	FINISH			
LEVEL 1											
101A	RECEPTION	FG	3'-4"	8'-0"	ALUM	ANO	ALUM	ANO	-	1	
101B	RECEPTION	VL	3'-4"	7'-0"	WD	CLR	KD	MFR		2	
102	DIRECTOR	VL	3'-0"	7'-0"	WD	CLR	KD	MFR		3	
103	ACCESS. RESTROOM	F	3'-0"	7'-0"	WD	CLR	KD	MFR		4	
104	ACCESS. RESTROOM	F	3'-0"	7'-0"	WD	CLR	KD	MFR		4	
105	STORAGE	F	3'-0"	7'-0"	WD	CLR	KD	MFR		5	
106	OFFICE #1	VL	3'-0"	7'-0"	WD	CLR	KD	MFR		3	
107	OFFICE #2	VL	3'-0"	7'-0"	WD	CLR	KD	MFR		3	
108	LAUNDRY	F	3'-0"	7'-0"	WD	CLR	KD	MFR		3	
109	BREAK ROOM	VL	3'-0"	7'-0"	WD	CLR	KD	MFR		3	
110A	KITCHEN	VL	3'-0"	7'-0"	WD	CLR	KD	MFR		2	
110B	KITCHEN	FP	6'-0"	8'-0"	WD	CLR	KD	MFR	90 MINUTE	6	
110C	KITCHEN	FG	3'-4"	8'-0"	ALUM	ANO	ALUM	ANO	-	1	
111	PANTRY	F	3'-0"	7'-0"	WD	CLR	KD	MFR		8	
112A	CLASSROOM #1	HG	3'-4"	7'-0"	WD	CLR	KD	MFR		9	
112B	CLASSROOM #1	HG	3'-4"	7'-0"	WD	CLR	KD	MFR		9	
113A	CLASSROOM #2	FG	3'-4"	8'-0"	ALUM	ANO	ALUM	ANO	-	1	
113B	CLASSROOM #2	HG	3'-4"	7'-0"	WD	CLR	KD	MFR		9	
114	OBSERVATION	VL	3'-0"	7'-0"	WD	CLR	KD	MFR		7	
115A	KIDS RESTROOM	F	3'-0"	7'-0"	WD	CLR	KD	MFR		10	
115B	KIDS RESTROOM	F	3'-0"	7'-0"	WD	CLR	KD	MFR		10	
116	OBSERVATION	VL	3'-0"	7'-0"	WD	CLR	KD	MFR		7	
117	OFFICE #3	VL	3'-0"	7'-0"	WD	CLR	KD	MFR		3	
118	OFFICE #4	VL	3'-0"	7'-0"	WD	CLR	KD	MFR		3	
119	CONFERENCE	VL	3'-0"	7'-0"	WD	CLR	KD	MFR		3	
120	CLOSET	F	3'-0"	7'-0"	WD	CLR	KD	MFR		5	
121	KIDS RESTROOM	F	3'-0"	7'-0"	WD	CLR	KD	MFR		10	
122	I.T.	F	3'-0"	7'-0"	WD	CLR	KD	MFR		5	
123	OBSERVATION/FLEX	VL	3'-0"	7'-0"	WD	CLR	KD	MFR		3	
124A	CLASSROOM #3	HG	3'-4"	7'-0"	WD	CLR	KD	MFR		9	
124B	CLASSROOM #3	HG	3'-4"	7'-0"	WD	CLR	KD	MFR		9	
124C	CLASSROOM #3	FG	3'-0"	8'-0"	ALUM	ANO	ALUM	ANO	-	1	
125	OBSERVATION	VL	3'-0"	7'-0"	WD	CLR	KD	MFR		7	
126A	KIDS RESTROOM	F	3'-0"	7'-0"	WD	CLR	KD	MFR		10	
126B	KIDS RESTROOM	F	3'-0"	7'-0"	WD	CLR	KD	MFR		10	
127	OBSERVATION	VL	3'-0"	7'-0"	WD	CLR	KD	MFR		7	
128A	CLASSROOM #4	HG	3'-4"	7'-0"	WD	CLR	KD	MFR		9	
128B	CLASSROOM #4	FG	3'-4"	8'-0"	ALUM	ANO	ALUM	ANO	-	1	
129A	CLASSROOM #5	HG	3'-4"	7'-0"	WD	CLR	KD	MFR		9	
129B	CLASSROOM #5	FG	3'-4"	8'-0"	ALUM	ANO	ALUM	ANO	-	1	
131	NORTH HALLWAY	FG	3'-4"	8'-0"	ALUM	ANO	ALUM	ANO	-	1	
132	SOUTH HALLWAY	FG	3'-0"	8'-0"	ALUM	ANO	ALUM	ANO	-	1	

MECH PLATFORM

201	MECH PLATFORM	F	3'-0"	6'-8"	WD	CLR	KD	MFR	90 MINUTE	5	
TOTAL: 43											


DOOR MATERIAL LEGEND

HM	HOLLOW METAL	KD	KNOCK-DOWN FRAME
MFR	BY MANUFACTURER	T	CLEAR, TEMPERED SAFETY GLAZING
PT	PAINT	ALUM	ALUMINUM STOREFRONT
STL	STEEL	ANO	ANODIZED
WD	WOOD	CLR	CLEAR FINISH

DOOR TYPES LEGEND

DOOR NOTES:

1. ALL INTERIOR DOORS TO BE 1-3/4" THICK, SOLID CORE, WITH PLAIN-SLICED, WHITE MAPLE VENEER, CLEAR FINISH.
2. KNOCK-DOWN FRAMES TO BE 3-PIECE TIMELY "BROWNSTONE"
3. VERIFY SWING DIRECTIONS ARE PER PLAN, TYPICAL
4. **SEE DOOR HARDWARE GROUPS ON SHEET A702**

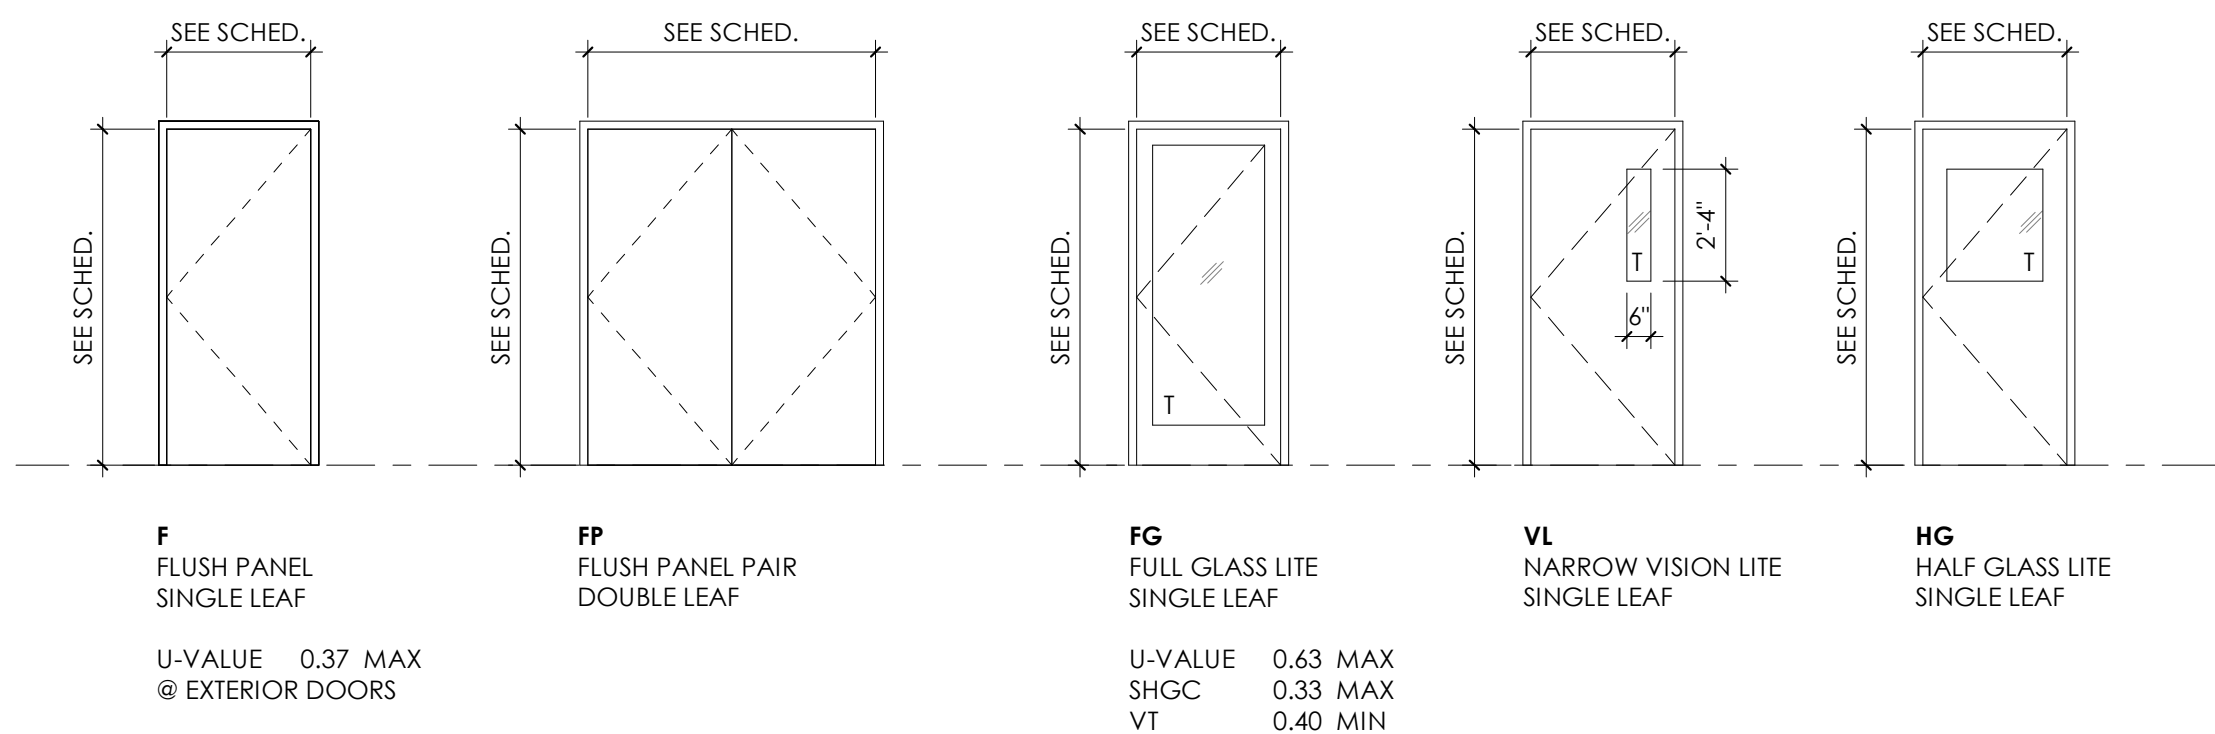



DOOR HARDWARE GROUPS

HARDWARE GROUP # 1 - STOREFRONT ENTRIES

QTY	DESCRIPTION	CATALOG NUMBER	FINISH	MFR
4 EA	HINGE	5BB1HW 5 X 5 NRP	630	IVE
1 EA	PANIC HARDWARE		626	VON
1 EA	RIM CYLINDER	20-057 ICX	626	SCH
1 EA	FSIC CORE	23-030	626	SCH
1 EA	OVERHEAD STOP	100S ADJ	630	GLY
1 EA	SURFACE CLOSER	DCN300	689	ARROW
1 EA	RAIN DRIP	142D	D	ZER
1 EA	DOOR SWEEP	8198D	D	ZER
1 EA	WEATHERSTRIPPING			
1 EA	THERMAL THRESHOLD	8726D	D	ZER

HARDWARE GROUP # 2 - RECEPTION, KITCHEN

QTY	DESCRIPTION	CATALOG NUMBER	FINISH	MFR
3 EA	HINGE	5BB1HW 4.5 X 4.5	652	IVE
1 EA	ENTRANCE/OFFICE LOCK	ND50P6D ATH	626	SCH
1 EA	SURFACE CLOSER	DCN300	689	ARROW
1 EA	KICK PLATE	8400 10" X 2" LDW B-CS	630	IVE
1 EA	WALL STOP	WS406/407CVX	630	IVE
3 EA	SILENCER	SR64	GRY	IVE

HARDWARE GROUP # 3 - OFFICES

QTY	DESCRIPTION	CATALOG NUMBER	FINISH	MFR
3 EA	HINGE	5BB1 4.5 X 4.5	652	IVE
1 EA	ENTRANCE/OFFICE LOCK	ND50P6D ATH	626	SCH
1 EA	WALL STOP	WS406/407CCV	630	IVE
1 EA	GASKETING	488SBK PSA (FOR SOUND)	BK	ZER

HARDWARE GROUP # 4 - ACCESSIBLE RESTROOMS

QTY	DESCRIPTION	CATALOG NUMBER	FINISH	MFR
3 EA	HINGE	5BB1HW 4.5 X 4.5	652	IVE
1 EA	PRIVACY W/INDICATOR	L9456T 07A L583-363 L283-722	626	SCH
1 EA	FSIC CORE	23-030	626	SCH
1 EA	SURFACE CLOSER	DCN300	689	ARROW
1 EA	KICK PLATE	8400 10" X 2" LDW B-CS	630	IVE
1 EA	WALL STOP	WS406/407CVX	630	IVE
1 EA	GASKETING	488SBK PSA (FOR SOUND)	BK	ZER

HARDWARE GROUP # 5 - STORAGE & IT

QTY	DESCRIPTION	CATALOG NUMBER	FINISH	MFR
3 EA	HINGE	5BB1 4.5 X 4.5	652	IVE
1 EA	STOREROOM LOCK	ND80P6D ATH	626	SCH
1 EA	WALL STOP	WS406/407CVX	630	IVE
3 EA	SILENCER	SR64	GRY	IVE

HARDWARE GROUP # 6 - WAREHOUSE DOUBLE DOOR

QTY	DESCRIPTION	CATALOG NUMBER	FINISH	MFR
6 EA	HINGE	5BB1 4.5 X 4.5	652	IVE
1 SET	CONST LATCHING BOLT	FB61P	630	IVE
1 EA	DUST PROOF STRIKE	DP2	626	IVE
1 EA	CONFIRM LOCKSET		626	SCH
2 EA	OH STOP	90S	630	GLY
1 EA	EDGE/ASTRAGAL	552	630	NGP
2 EA	SILENCER	SR64	GRY	IVE

HARDWARE GROUP # 7 - OBSERVATION ROOMS

QTY	DESCRIPTION	CATALOG NUMBER	FINISH	MFR
3 EA	HINGE	5BB1 4.5 X 4.5	652	IVE
1 EA	PASSAGE SET	ND10S ATH	626	SCH
1 EA	WALL STOP	WS406/407CVX	630	IVE
1 EA	GASKETING	488SBK PSA (FOR SOUND)	BK	ZER

HARDWARE GROUP # 8 - PANTRY

QTY	DESCRIPTION	CATALOG NUMBER	FINISH	MFR
3 EA	HINGE	5BB1 4.5 X 4.5	652	IVE
1 EA	PASSAGE SET	ND10S ATH	626	SCH
1 EA	OH STOP	90S	630	GLY
3 EA	SILENCER	SR64	GRY	IVE

HARDWARE GROUP # 9 - CLASSROOMS

QTY	DESCRIPTION	CATALOG NUMBER	FINISH	MFR
3 EA	HINGE	5BB1HW 4.5 X 4.5	652	IVE
1 EA	CLASSROOM SEC LOCK	ND75P6D ATH XN12-035	626	SCH
	W/INDIC. ROSE			
1 EA	WALL STOP	WS406/407CVX	630	IVE
1 EA	GASKETING	488SBK PSA (FOR SOUND)	BK	ZER

HARDWARE GROUP # 10 - KIDS RESTROOMS

QTY	DESCRIPTION	CATALOG NUMBER	FINISH	MFR
3 EA	HINGE	5BB1HW 4.5 X 4.5	652	IVE
1 EA	PUSH PLATE	8200 4" X 16"	630	IVE
1 EA	PULL PLATE	8302 8" 4" X 16" G	630	IVE
1 EA	SURFACE CLOSER	DCN300	689	ARROW
1 EA	KICK PLATE	8400 10" X 2" LDW B-CS	630	IVE
1 EA	WALL STOP	WS406/407CVX	630	IVE
1 EA	GASKETING	488SBK PSA (FOR SOUND)	BK	ZER



ESD 112 - 2200 Building
Education Facility Renovation
2200 NE 65th Ave.
Vancouver, WA 98661


DATE: 08.07.2026
DRAWN BY: KR
JOB NO: 26-004
REV NO:

DETAILS


A810

PERMIT SET


© 2026

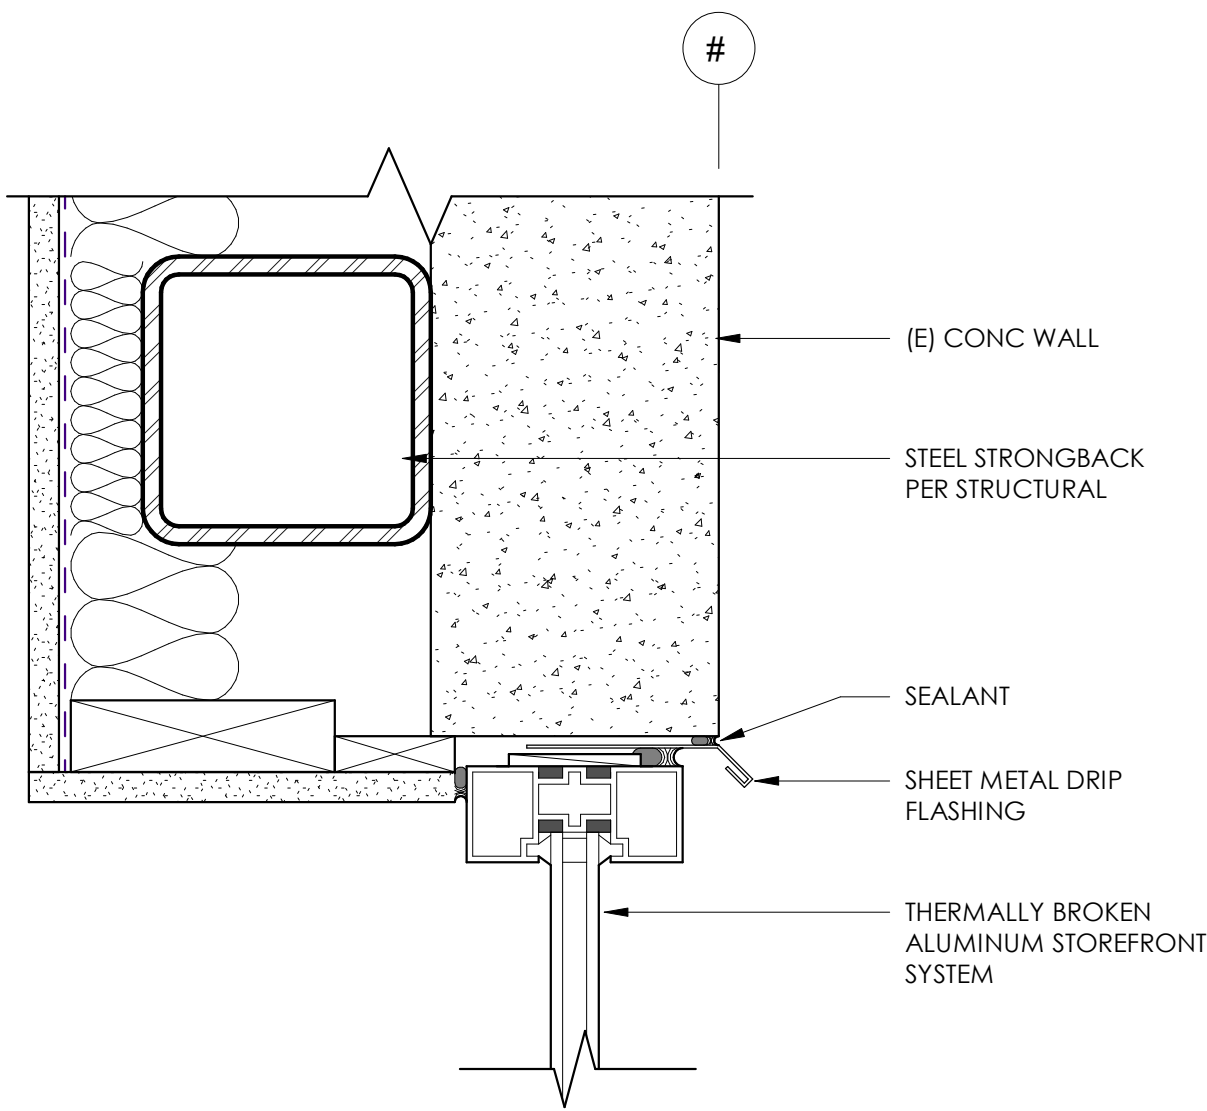

1 / TYPICAL STOREFRONT HEAD
scale: 3" = 1'-0"

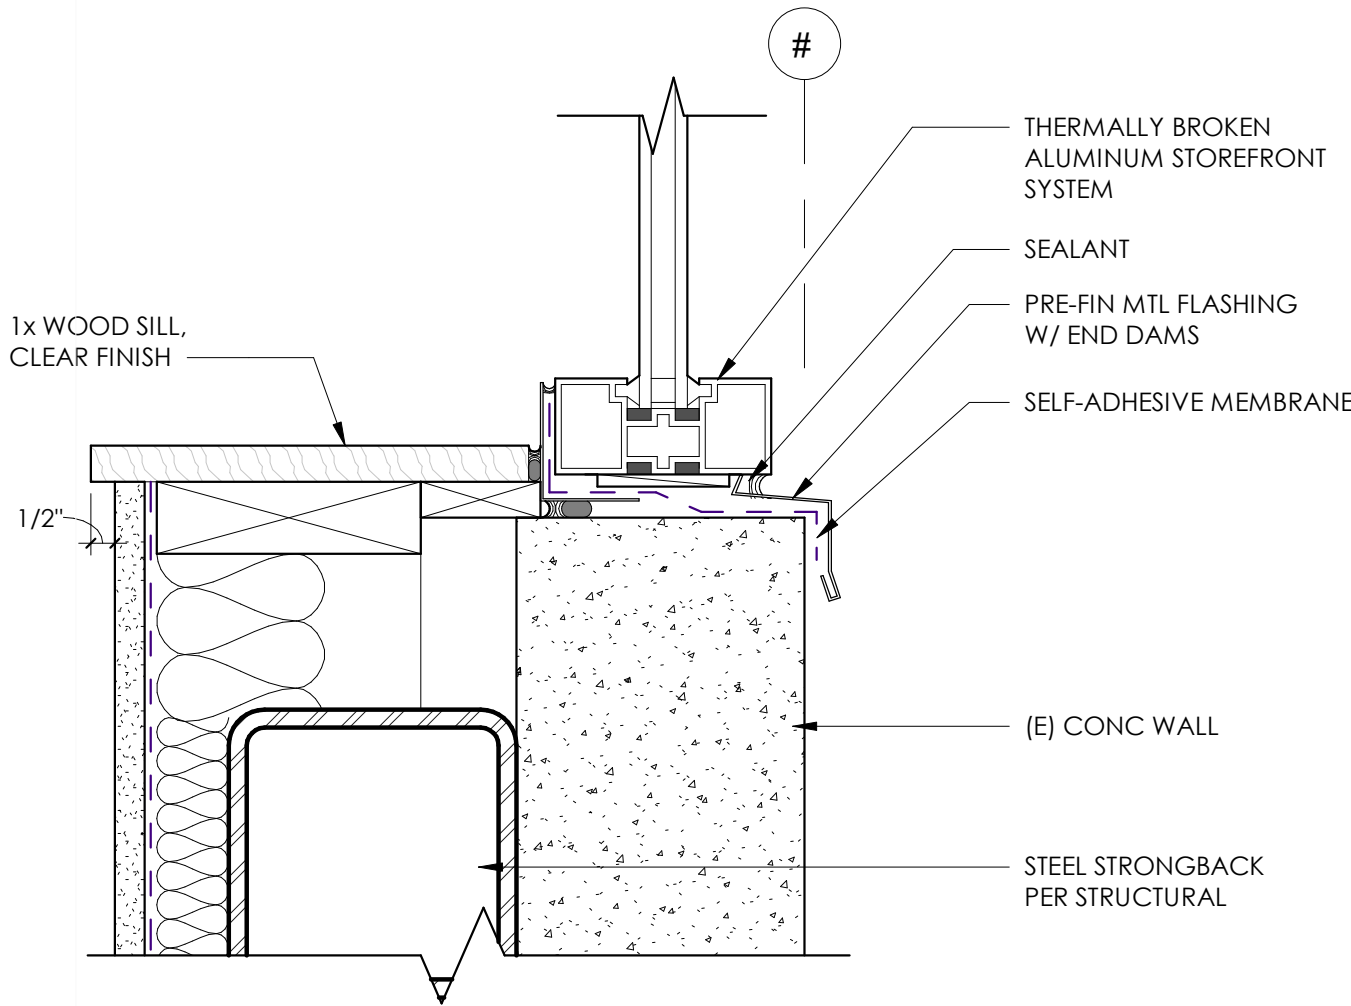

2 / TYPICAL STOREFRONT SILL
scale: 3" = 1'-0"

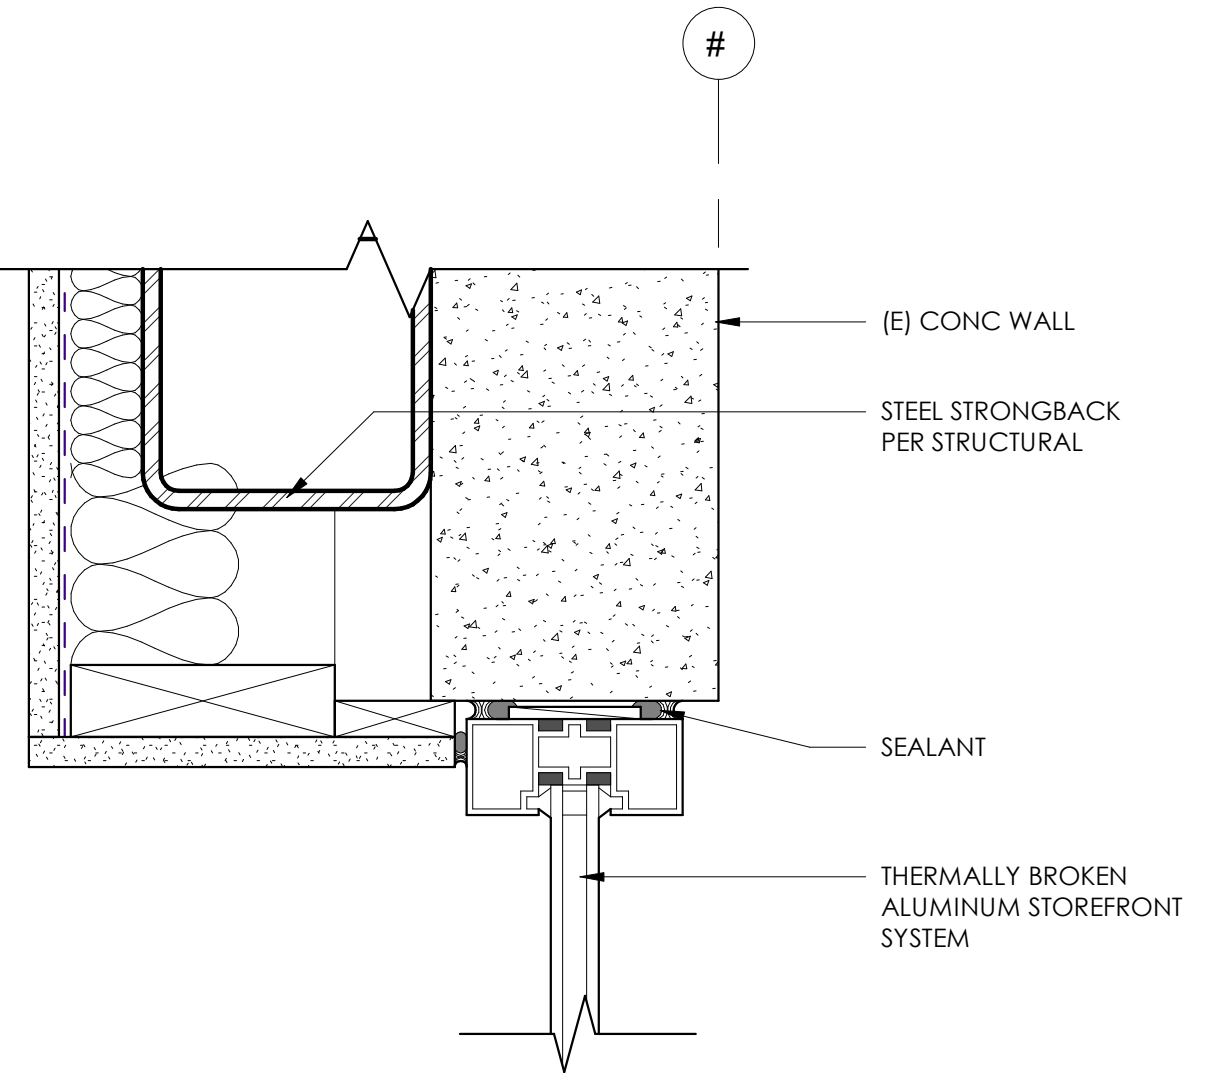

3 / TYPICAL STOREFRONT JAMB
scale: 3" = 1'-0"


ROOM FINISH SCHEDULE													
ROOM NO.	ROOM NAME	FLOOR FINISH	BASE FINISH	CEILING FINISH	WALL FINISH				CASEWORK FINISH			PARTITION FINISH	REMARKS
					WEST	NORTH	EAST	SOUTH	BASE CABINET	COUNTERTOP	UPPER CABINET		
LEVEL 1													
101	RECEPTION	WM-1	RB-1	ACT-1	P-1	P-1	P-1	P-1					WAIN-1 UP TO 3'-6" AF
102	DIRECTOR	CPT-1	RB-1	ACT-1	P-1	P-1	P-1	P-1					
103	ACCESSIBLE RESTROOM	CONC-1	RB-2	PT-1	P-1	P-1	P-1	P-1	PLAM-1	PLAM-3	PLAM-1		WAIN-2 UP TO 5'-0" AFF
104	ACCESSIBLE RESTROOM	CONC-1	RB-2	PT-1	P-1	P-1	P-1	P-1	PLAM-1	PLAM-3	PLAM-1		WAIN-2 UP TO 5'-0" AFF
105	STORAGE	CPT-1	RB-1	ACT-1	P-1	P-1	P-1	P-1					
106	OFFICE #1	CPT-1	RB-1	ACT-1	P-1	P-1	P-1	P-1					
107	OFFICE #2	CPT-1	RB-1	ACT-1	P-1	P-1	P-1	P-1					
108	LAUNDRY	CONC-1	RB-2	ACT-1	P-1	P-1	P-1	P-1					
109	BREAK ROOM	CPT-1	RB-1	ACT-1	P-1	P-1	P-1	P-1					
110	KITCHEN	CONC-1	RB-2	PT-1	P-1	P-1	P-1	P-1	-	SS-1	-		
111	PANTRY	CONC-1	RB-2	PT-1	P-1	P-1	P-1	P-1					
112	CLASSROOM #1	LVT-1	RB-1	ACT-1	P-1	P-1	P-1	P-1	PLAM-1	PLAM-3	PLAM-1		
113	CLASSROOM #2	LVT-1	RB-1	ACT-1	P-1	P-1	P-1	P-1	PLAM-1	PLAM-3	PLAM-1		
114	OBSERVE	CPT-1	RB-1	ACT-1	P-1	P-1	P-1	P-1					
115	KIDS RR	CONC-1	RB-2	PT-1	P-1	P-1	P-1	P-1	PLAM-1	PLAM-3	PLAM-1	PLAM-2	WAIN-2 UP TO 5'-0" AFF
116	OBSERVE	CPT-1	RB-1	ACT-1	P-1	P-1	P-1	P-1					
117	OFFICE #3	CPT-1	WB-1	ACT-1	P-1	P-1	P-1	P-1					
118	OFFICE #4	CPT-1	WB-1	ACT-1	P-1	P-1	P-1	P-1					
119	CONFERENCE	CPT-1	WB-1	ACT-1	P-1	P-1	P-1	P-1					
120	CLOSET	CPT-1	RB-1	ACT-1	P-1	P-1	P-1	P-1					
121	KIDS RR	CONC-1	RB-2	PT-1	P-1	P-1	P-1	P-1	PLAM-1	PLAM-3	PLAM-1	PLAM-2	WAIN-2 UP TO 5'-0" AFF
122	I.T.	CPT-1	RB-1	ACT-1	P-1	P-1	P-1	P-1					
123	OBSERVE/FLEX	CPT-1	RB-1	ACT-1	P-1	P-1	P-1	P-1					
124	CLASSROOM #3	LVT-1	RB-1	ACT-1	P-1	P-1	P-1	P-1	PLAM-1	PLAM-3	PLAM-1		
125	OBSERVE	CPT-1	RB-1	ACT-1	P-1	P-1	P-1	P-1					
126	KIDS RR	CONC-1	RB-2	PT-1	P-1	P-1	P-1	P-1	PLAM-1	PLAM-3	PLAM-1	PLAM-2	WAIN-2 UP TO 5'-0" AFF
127	OBSERVE	CPT-1	RB-1	ACT-1	P-1	P-1	P-1	P-1					
128	CLASSROOM #4	LVT-1	RB-1	ACT-1	P-1	P-1	P-1	P-1	PLAM-1	PLAM-3	PLAM-1		
129	CLASSROOM #5	LVT-1	RB-1	ACT-1	P-1	P-1	P-1	P-1	PLAM-1	PLAM-3	PLAM-1		
130	WEST HALLWAY	CPT-1	RB-1	ACT-1	P-1	P-1	P-1	P-1					WAIN-1 UP TO 3'-6" AF
131	NORTH HALLWAY	CPT-1/WM-1	RB-1	ACT-1	P-1	P-1	P-1	P-1					WAIN-1 UP TO 3'-6" AFF WHERE INDICATED, SEE FINISH FLOOR PLAN
132	SOUTH HALLWAY	CPT-1/WM-1	RB-1	ACT-1	P-1	P-1	P-1	P-1					WAIN-1 UP TO 3'-6" AFF WHERE INDICATED, SEE FINISH FLOOR PLAN

INTERIOR FINISH LEGEND									
ID	MATERIAL TYPE	LOCATION	MANUFACTURER	COLLECTION / SERIES	STYLE / PATTERN	COLOR	SIZE	PRODUCT	COMMENTS
ACT-1	ACOUSTIC CEILING TILE	CEILING	ARMSTRONG	FINE FISSURED	ANGLED TEGULAR 15/16"	WHITE	24" x 48" - VFY		RECESSED T-BAR. 2'X2' & 2'x4' SECOND LOOK
CONC-1	SEALED CONCRETE (EPOXY)	FLOORING	COLOR GRANULES	PENNTEK	EPOXY, FLAKES IN 1/4", AND GRIT FOR WET AREAS	TIDAL WAVE	-	FB-807	TIDAL WAVE' FLAKES IN 1/4" - BROADCAST INTO THIS FIRST LAYER, SECOND-LAYER OF CLEAR FINISH COAT IN SATIN SHEEN, AND 40-S GRIT QUARTZ GRANULES FOR GRIP IN A LITE-BROADCAST INTO THIS SECOND LAYER CLEAR FINISH COAT.
CPT-1	CARPET TILE	FLOORING	INTERFACE	PRIMARY STITCH	MONOLITHIC - PARALLEL TO HALLWAY. 1462102500	102419 PURL / ACCENT	50CM x 50CM	1462102500	
LVP-1	LUXURY VINYL PLANK	FLOORING	SIX DEGREES FLOOR SOLUTIONS	SIX DEGREES COMPASS	SAN FRANCISCO	MEDIUM-GRAY	6" x 48" x 3mm	CP221-C36	
P-1	PAINT - GENERAL	WALL / CEILING	SHERWIN-WILLIAMS	PROMAR 200 ZERO VOC	EG-SHEL SHEEN	FONDANT	-	B20W12650	
PLAM-1	PLASTIC LAMINATE	CASEWORK	-	-	-	-	-	-	
PLAM-2	PLASTIC LAMINATE	RESTROOM PARTITIONS	WILSONART	WILSONART LAMINATE	STANDARD LAMINATE, MATTE FINISH	MISTED ZEPHYR	-	4843-60	EDGE BANDING: BLACK 3/4" FLEXIBLE T-MOLDING TRIM , PLASTIC CENTER BARB TEE MOULDING.
PLAM-3	PLASTIC LAMINATE	COUNTERTOPS	-	-	-	-	-	-	
RB-1	RUBBER BASE - 4 -1/2"	WALL	FLEXCO			CHARCOAL	4 - 1/2"	C45CW1P003	
RB-2	RUBBER BASE - 6"	WALL	FLEXCO			CHARCOAL	6"	C60CW1P003	
SS-1	STAINLESS STEEL	KITCHEN COUNTERTOPS	-	-	-	-	-	-	
WAIN-1	WAINSCOTTING	WALL	-	-	-	-	-	-	
WAIN-2	WAINSCOTTING	RESTROOM WALL	-	-	-	-	-	-	
WM-1	WALK-OFF MAT	FLOORING	INTERFACE	STEP RETREAT	SR999	MIDNIGHT	-	1388702500	



INTERIOR FINISH GENERAL NOTES

1. PATCH SLAB THROUGHOUT, UNO. BEAD BLAST EXISTING CONCRETE PREP FOR FINISH AS SCHEDULED.
2. PATCH, LEVEL AND OTHERWISE PREPARE SUB FLOORING IN ACCORDANCE WITH MANUFACTURER'S WRITTEN INSTRUCTIONS.
3. GRIND, FILL, OR OTHERWISE LEVEL SUBSTRATES TO MEET MAX. ALLOWABLE TOLERANCE — 1/4' OVER 10' IN ANY DIRECTION.
4. PROVIDE CARPET, VCT, SHEET LINOLEUM, SHEET VINYL AND RUBBER BASE AS SCHEDULED
5. PROVIDE RUBBER-REDUCING STRIPS IN COLOR TO MATCH SPECIFIED BASE, REDUCING STRIPS TO OCCUR AT ALL AREAS OF FLOOR MATERIAL TRANSITION.
6. INSTALL BASE IN LONGEST AVAILABLE LENGTH WITH NO PIECE LESS THAN 12". DO NOT LOCATE JOINTS AT OUTSIDE CORNERS OR WITHIN 6" OF INSIDE CORNERS.
7. PROVIDE __% OR BOX OF FLOORING FOR ATTIC STOCK.



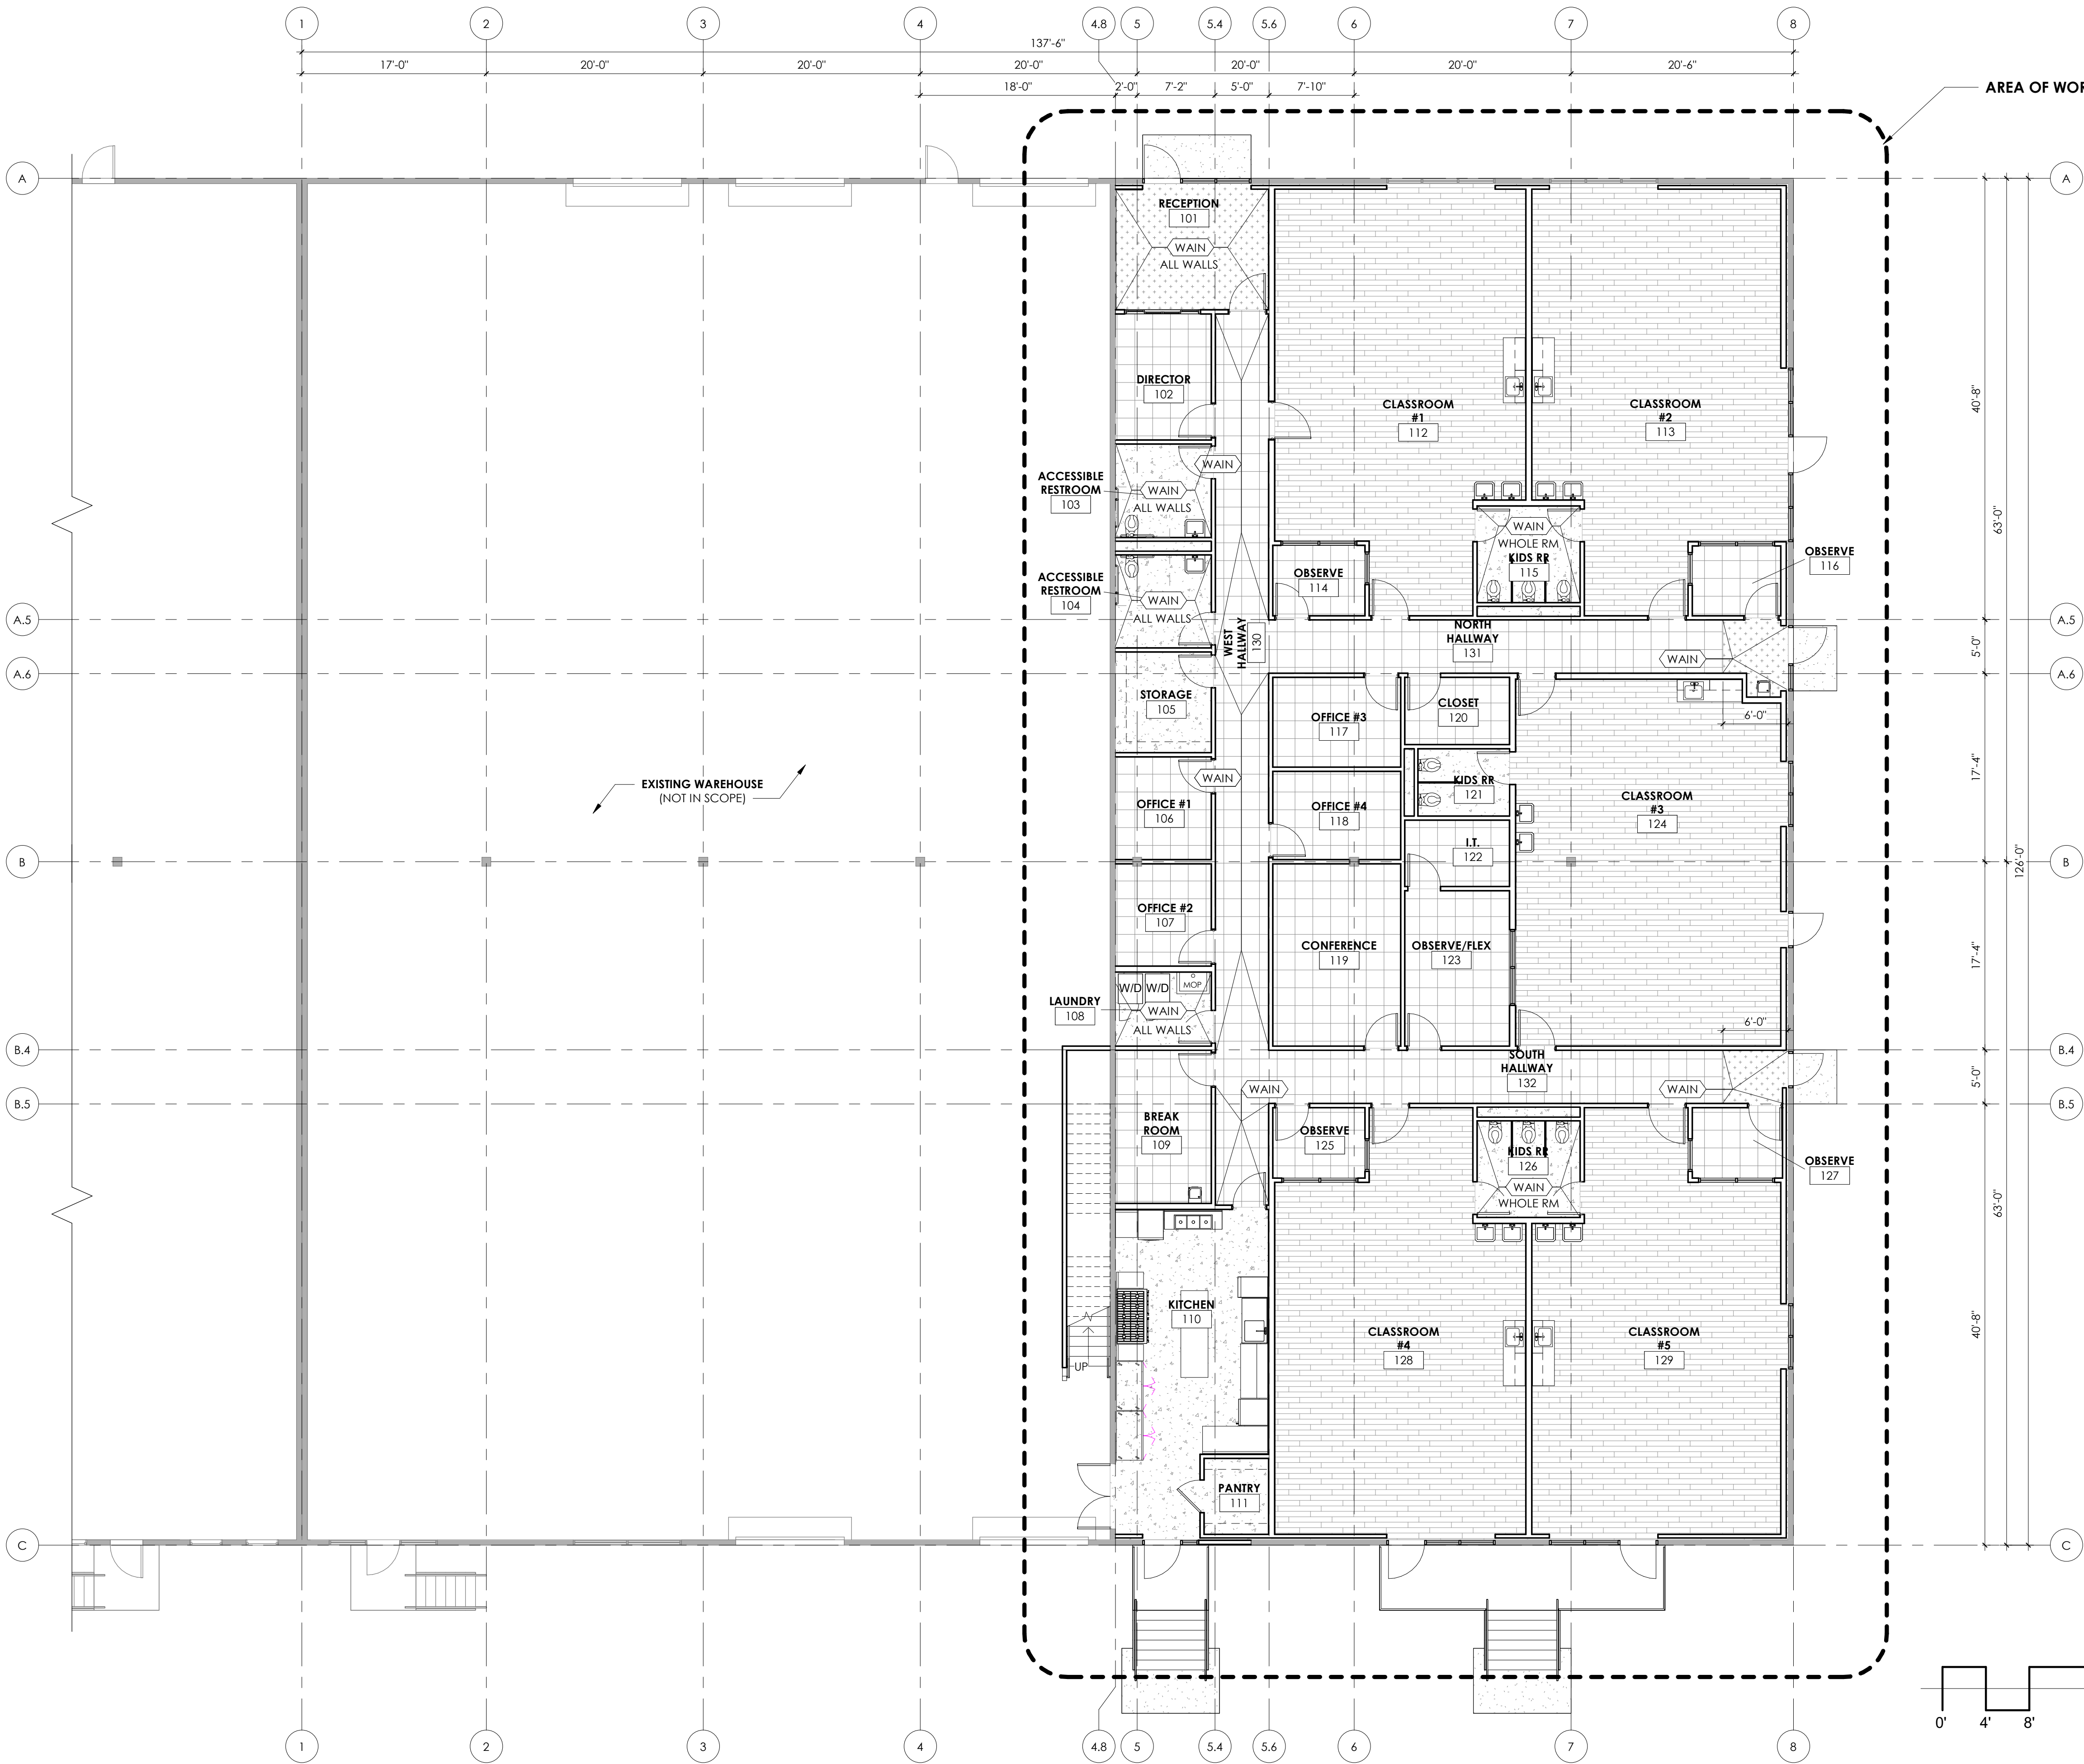


FINISH FLOOR PLAN LEGEND

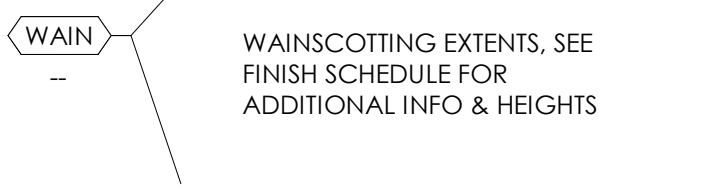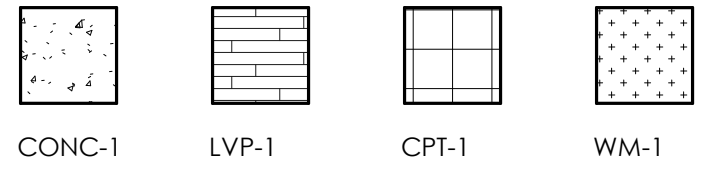


1 / FINISH FLOOR PLAN


scale: 1/8" = 1'-0"

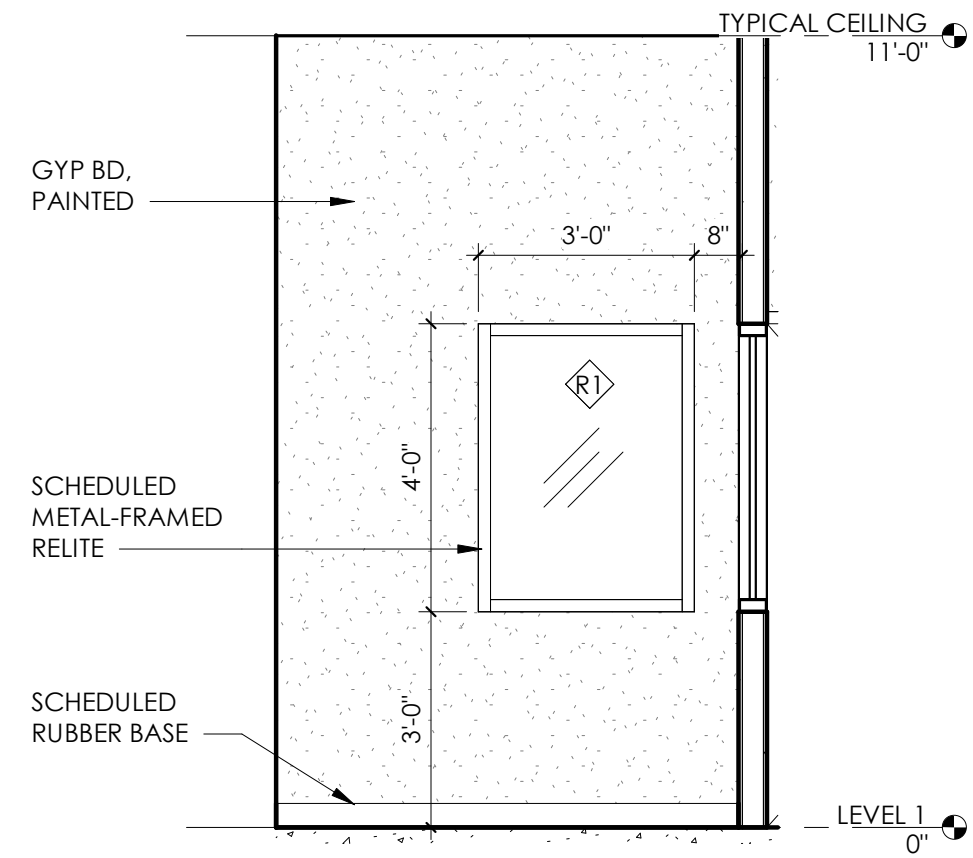


4/ TYPICAL OBSERV. ROOM - SIDE
scale: 3/8" = 1'-0"

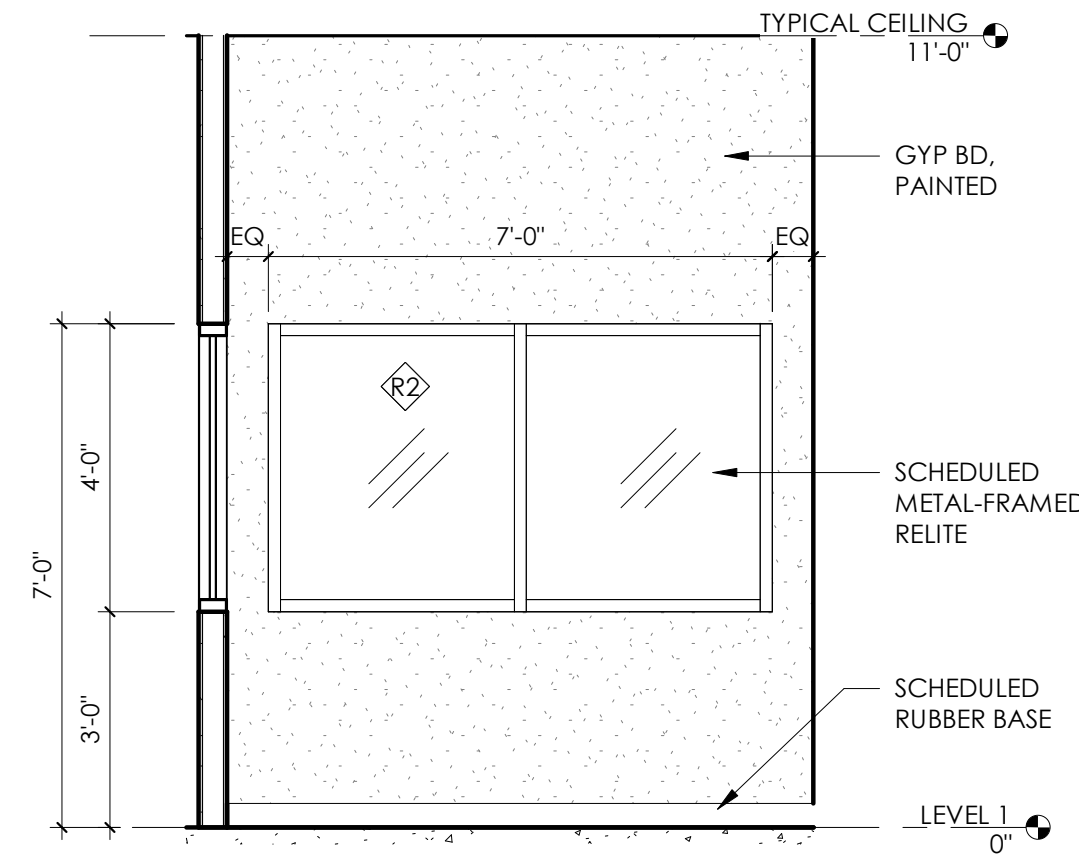


3/ TYPICAL OBSERV. ROOM - FRONT
scale: 3/8" = 1'-0"

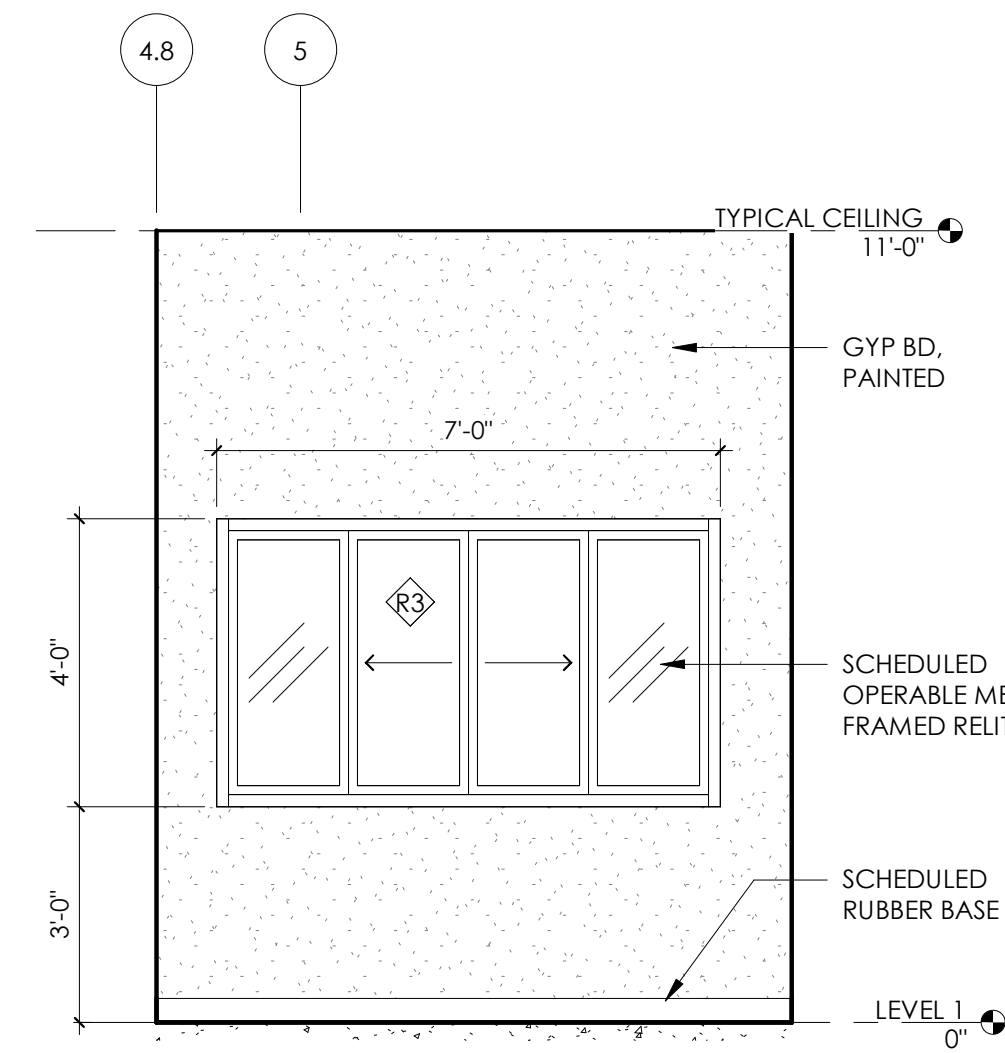


2/ DIRECTOR'S OFFICE - NORTH
scale: 3/8" = 1'-0"

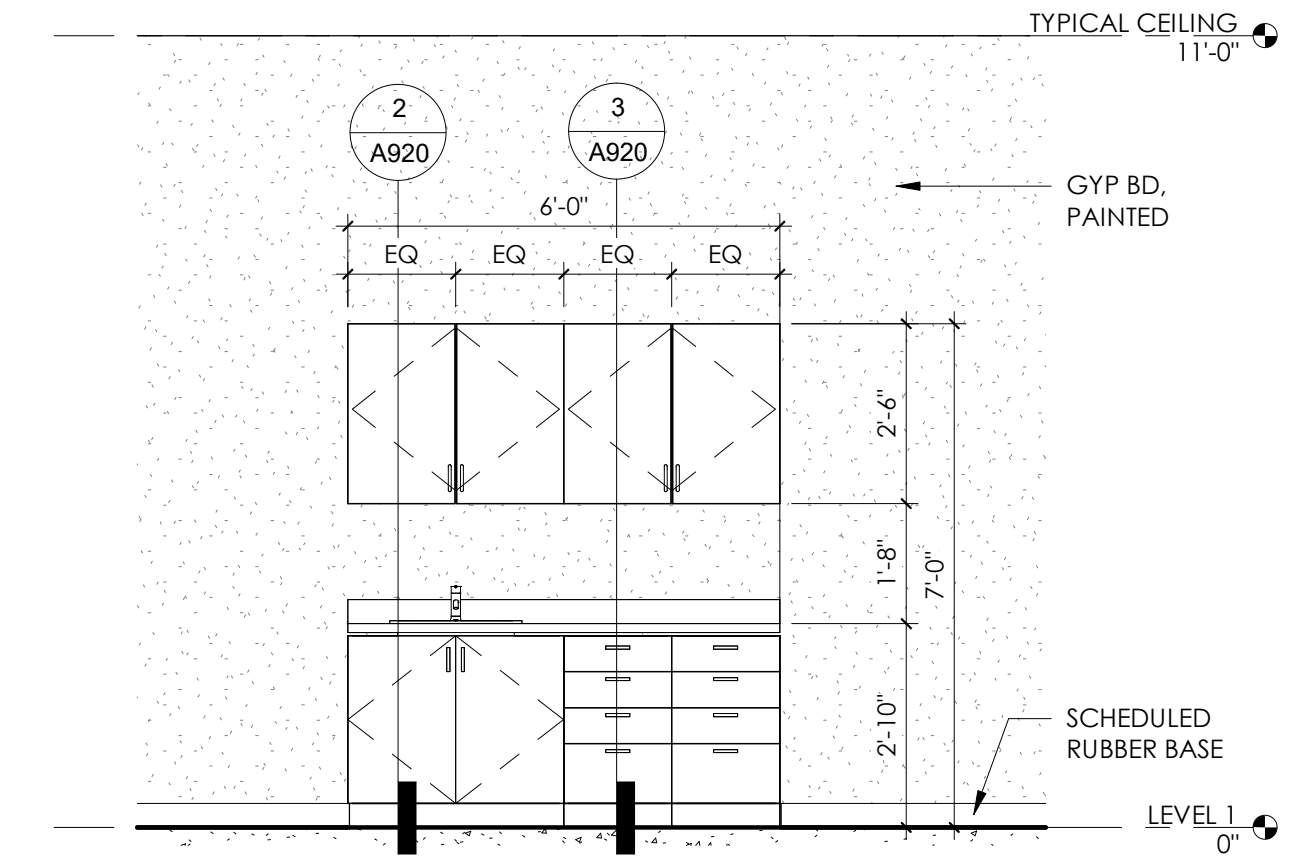


1/ TYPICAL CLASSROOM CASEWORK
scale: 3/8" = 1'-0"

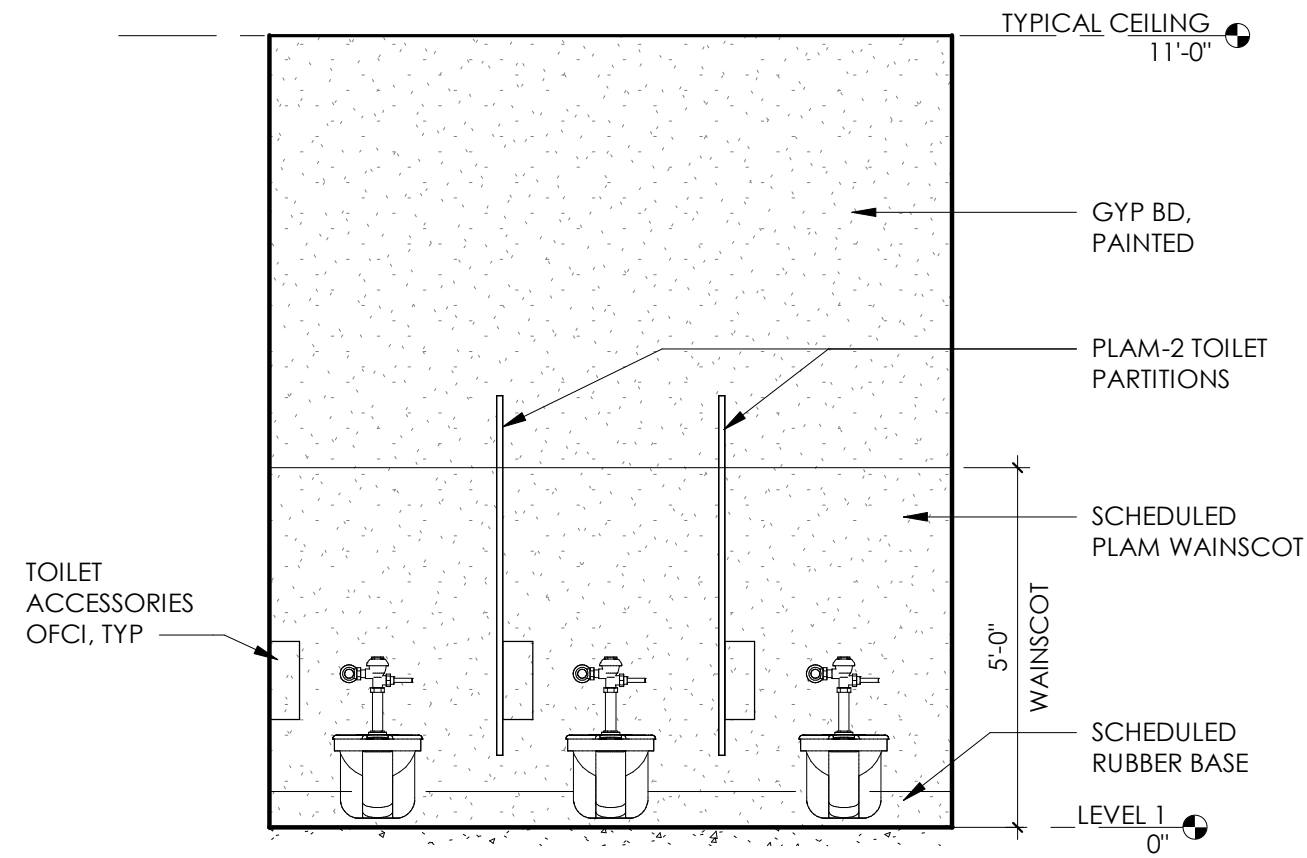


8/ TYPICAL KIDS RESTROOM
scale: 3/8" = 1'-0"

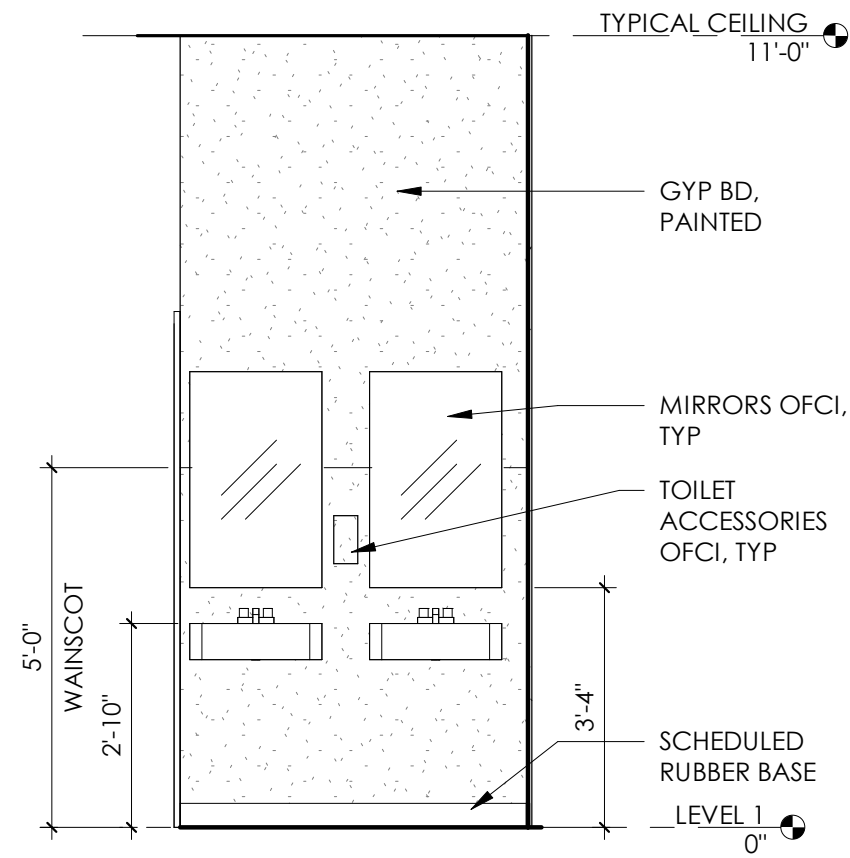


7/ TYPICAL CLASSROOM LAV
scale: 3/8" = 1'-0"

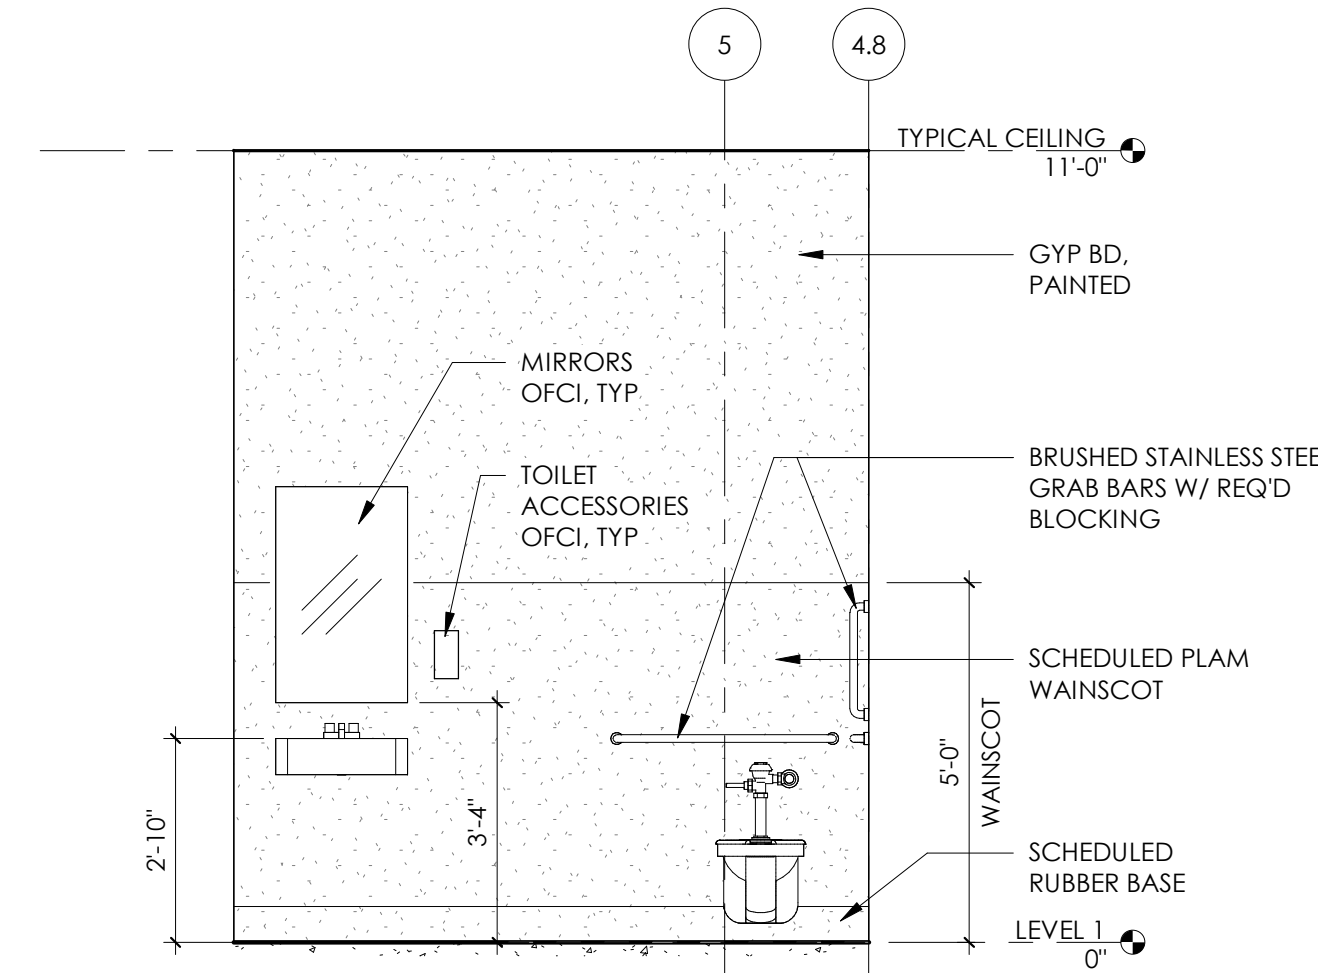


6/ TYP ACCESSIBLE RESTROOM
scale: 3/8" = 1'-0"

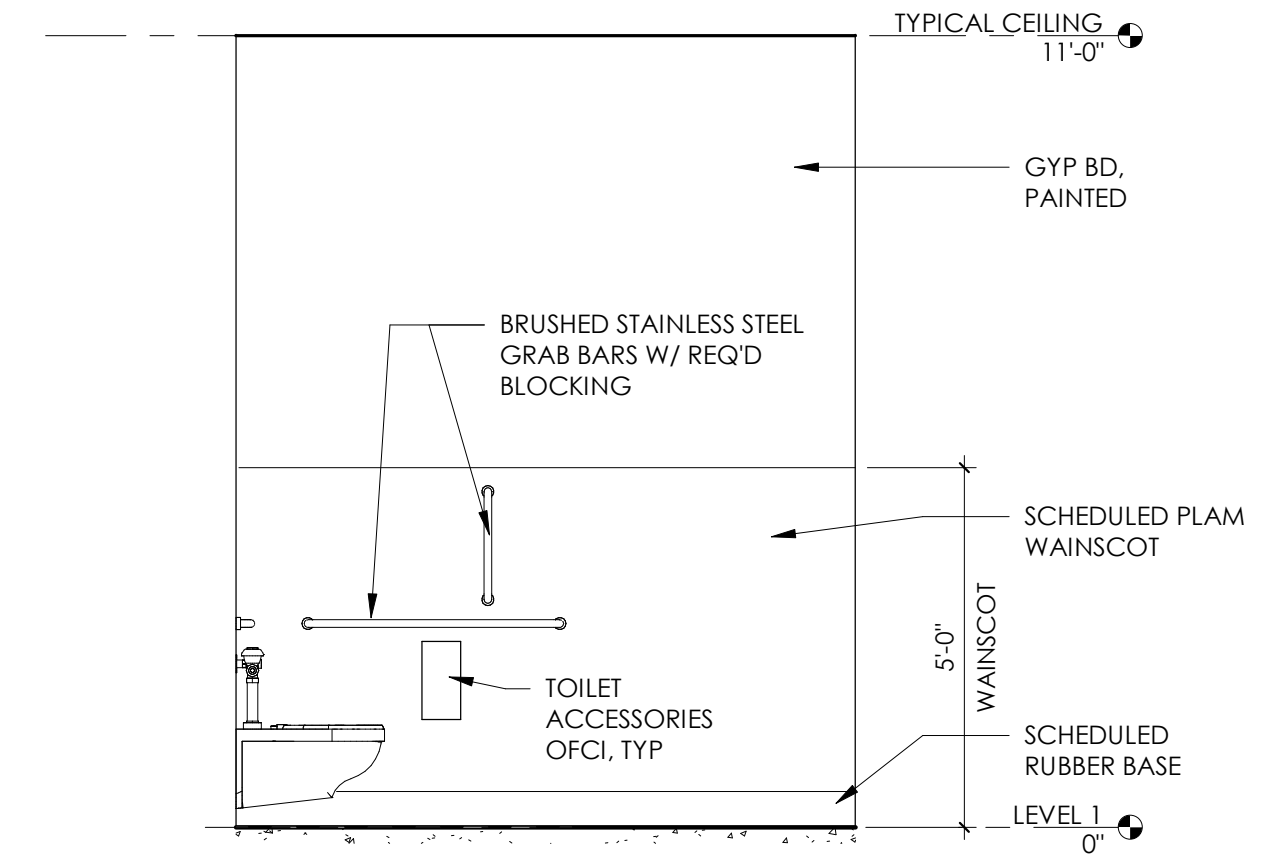


5/ TYP ACCESSIBLE RESTROOM - SIDE
scale: 3/8" = 1'-0"

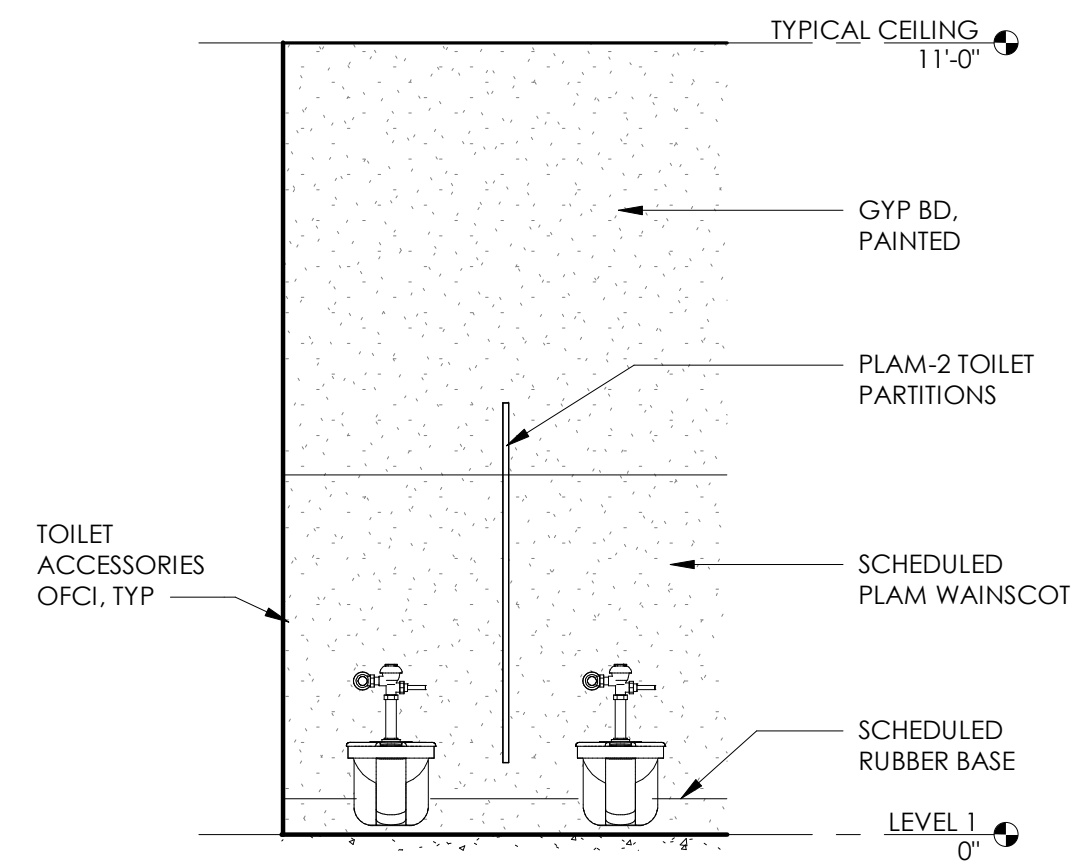


10/ KIDS RESTROOM #121
scale: 3/8" = 1'-0"

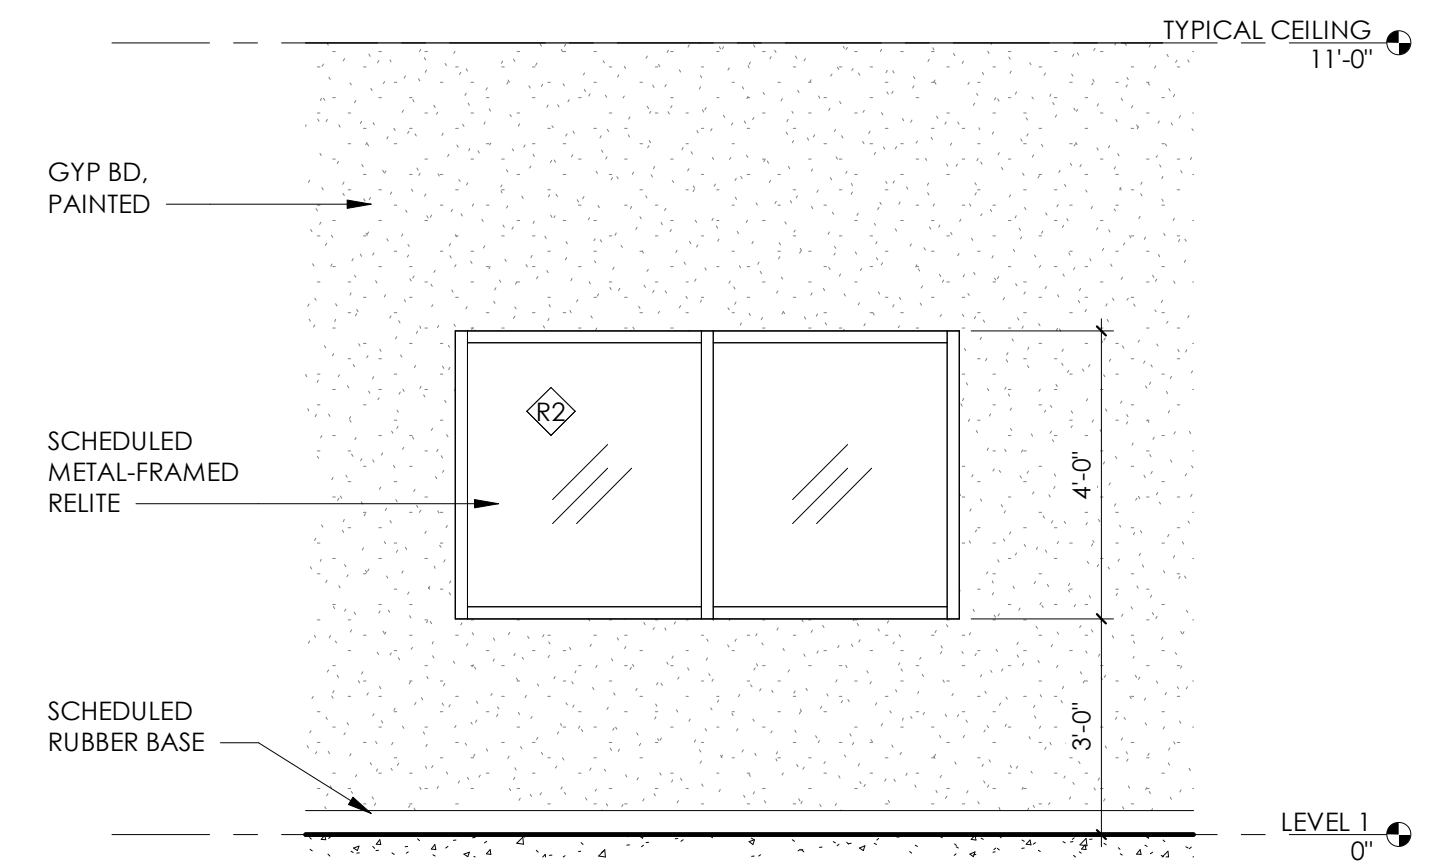


9/ OBSERVE/FLEX #123
scale: 3/8" = 1'-0"

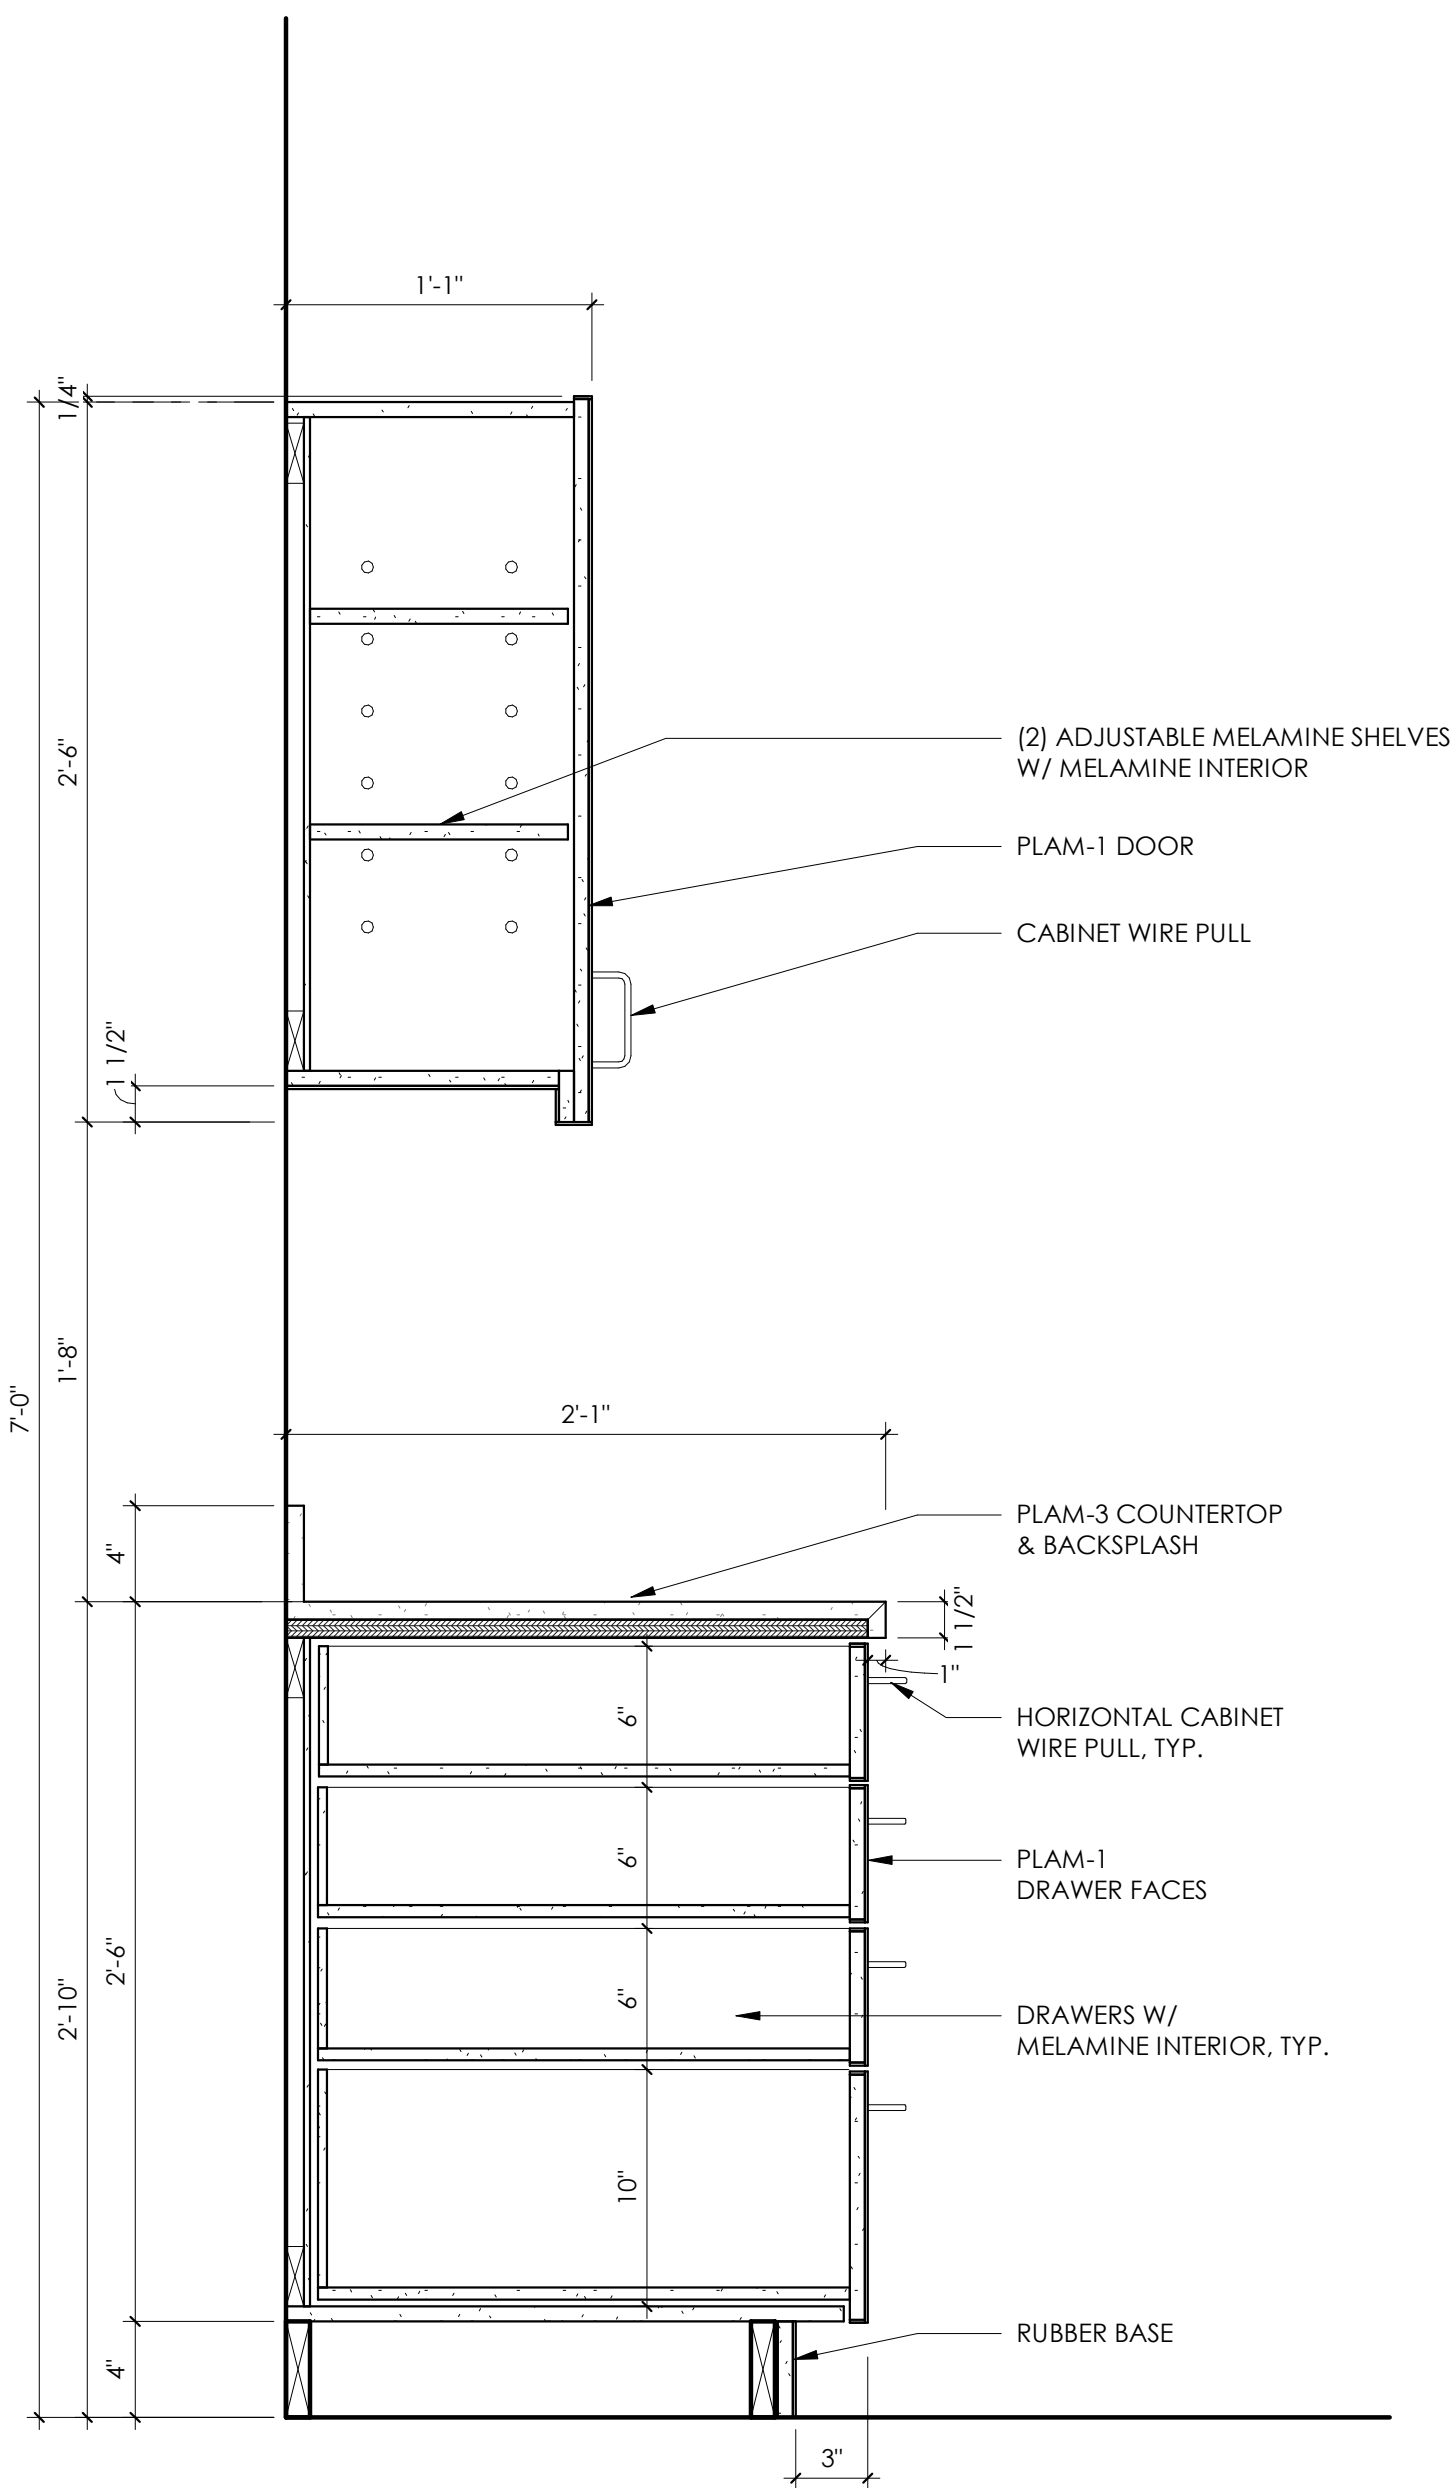

3/ LOWER DRAWER CASEWORK
scale: 1 1/2" = 1'-0"

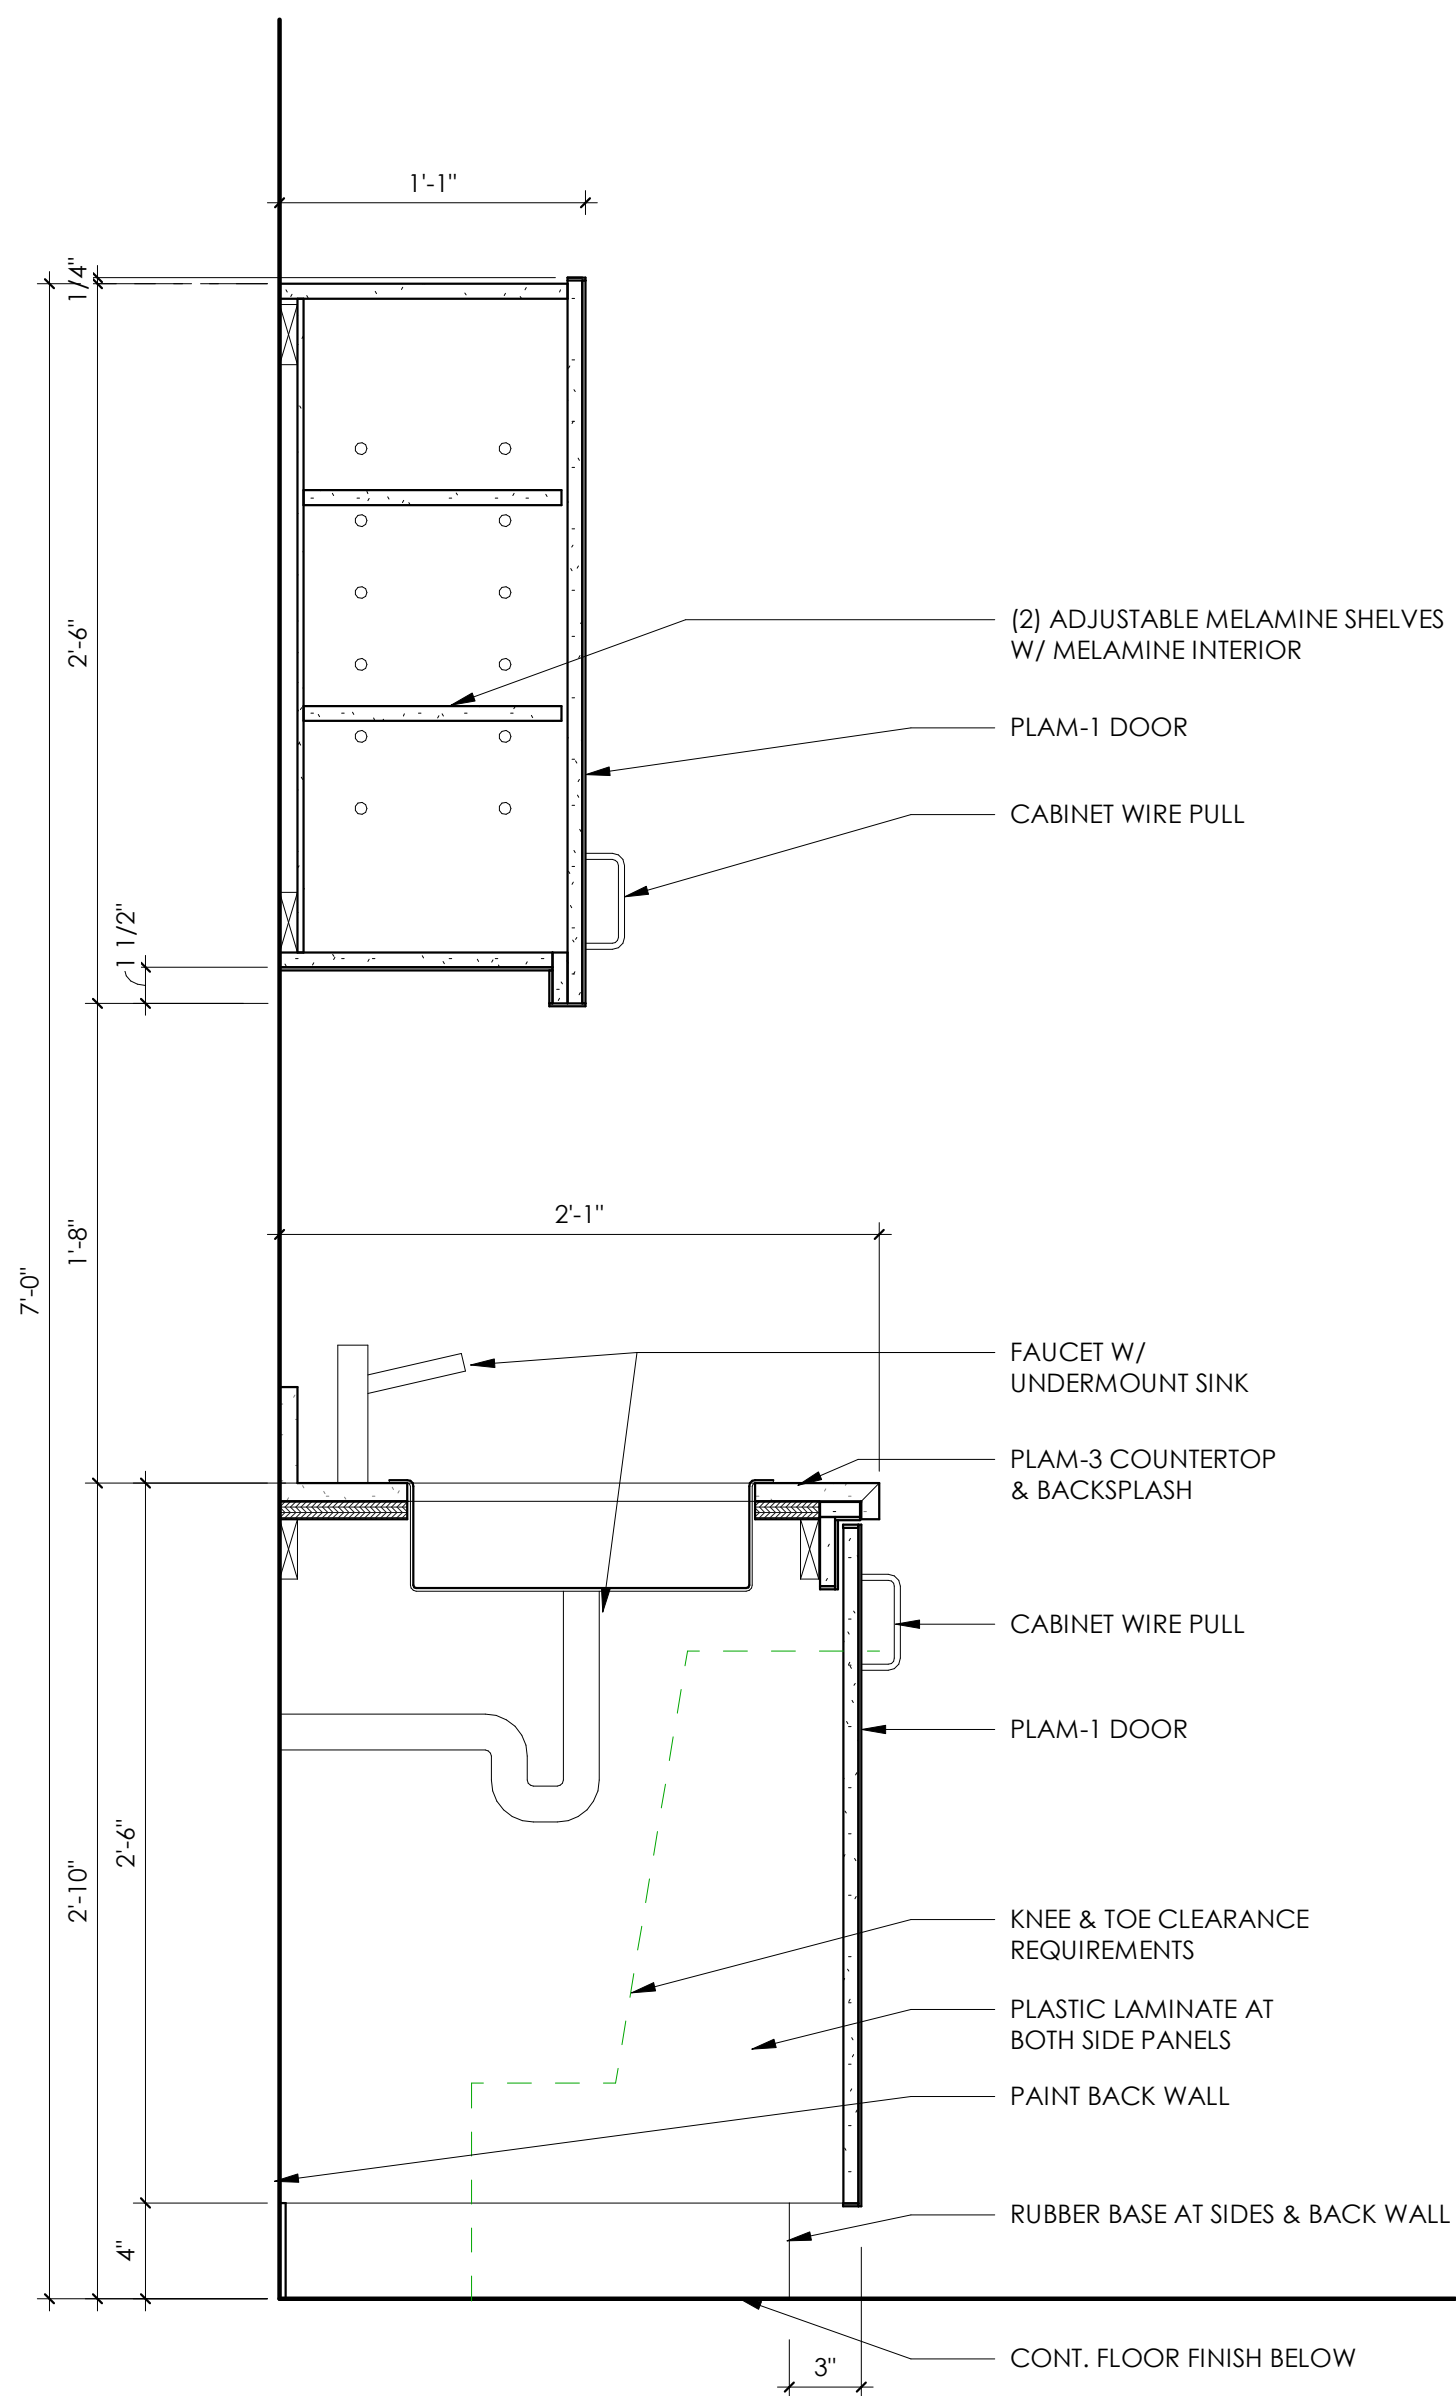

2/ UPPER & LOWER CASEWORK AT SINK
scale: 1 1/2" = 1'-0"

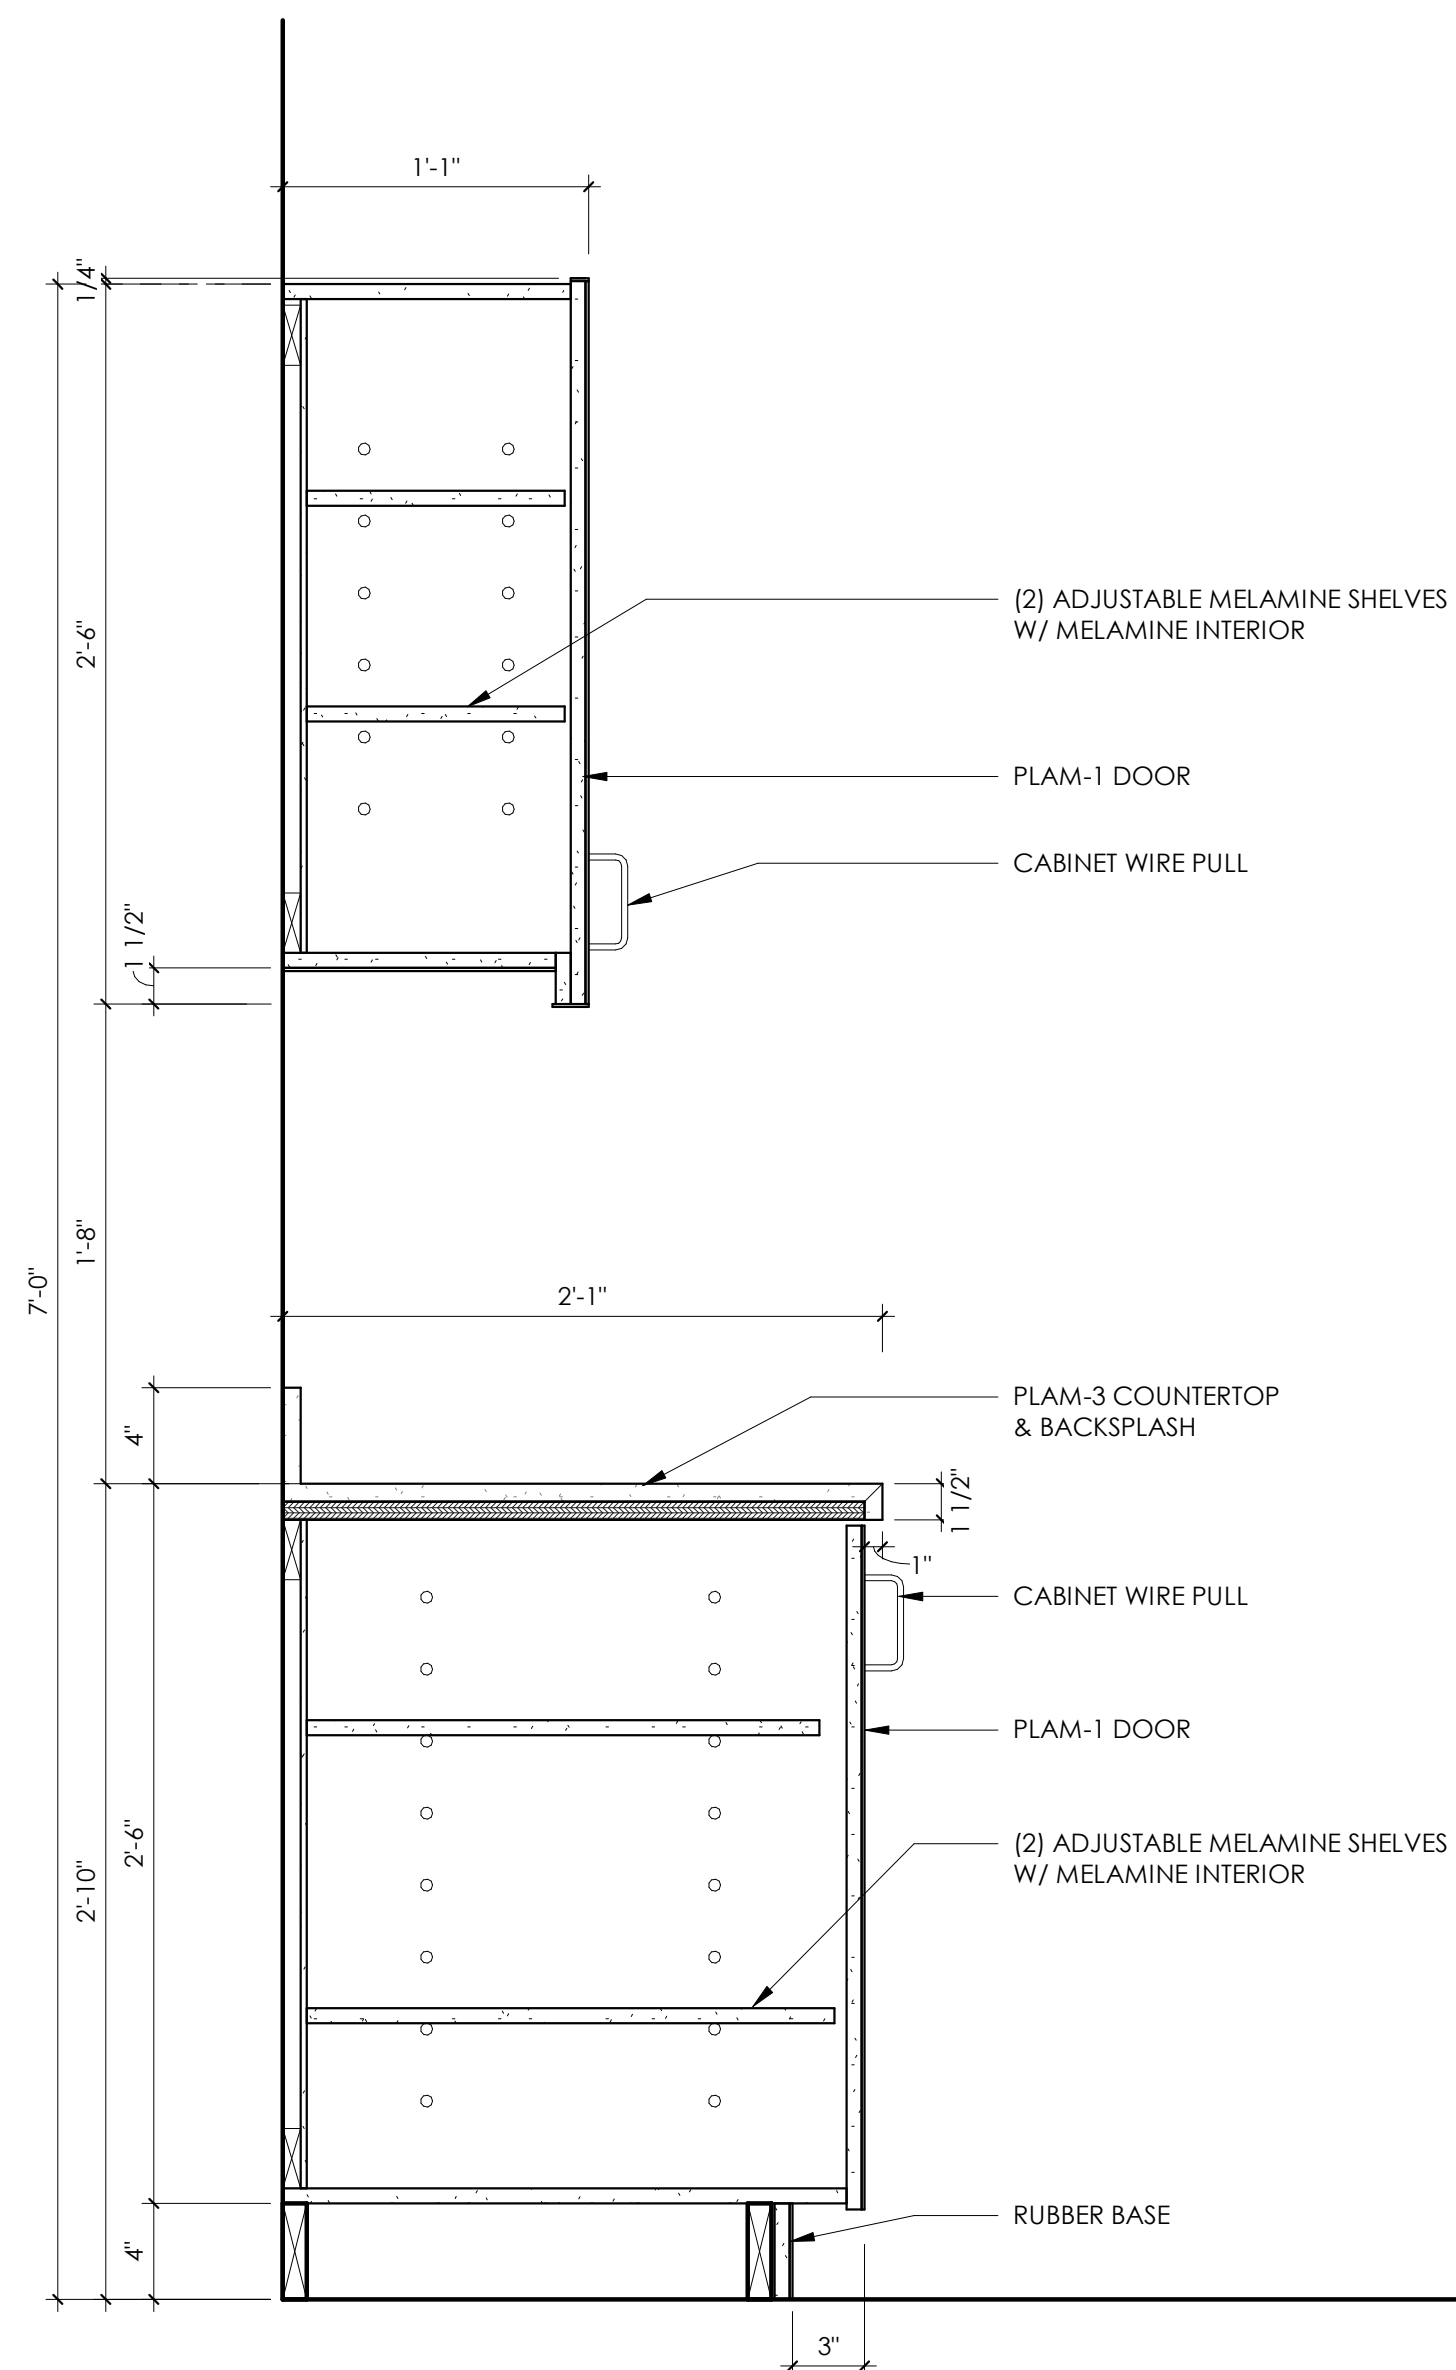

1/ UPPER & LOWER CASEWORK, TYP.
scale: 1 1/2" = 1'-0"