
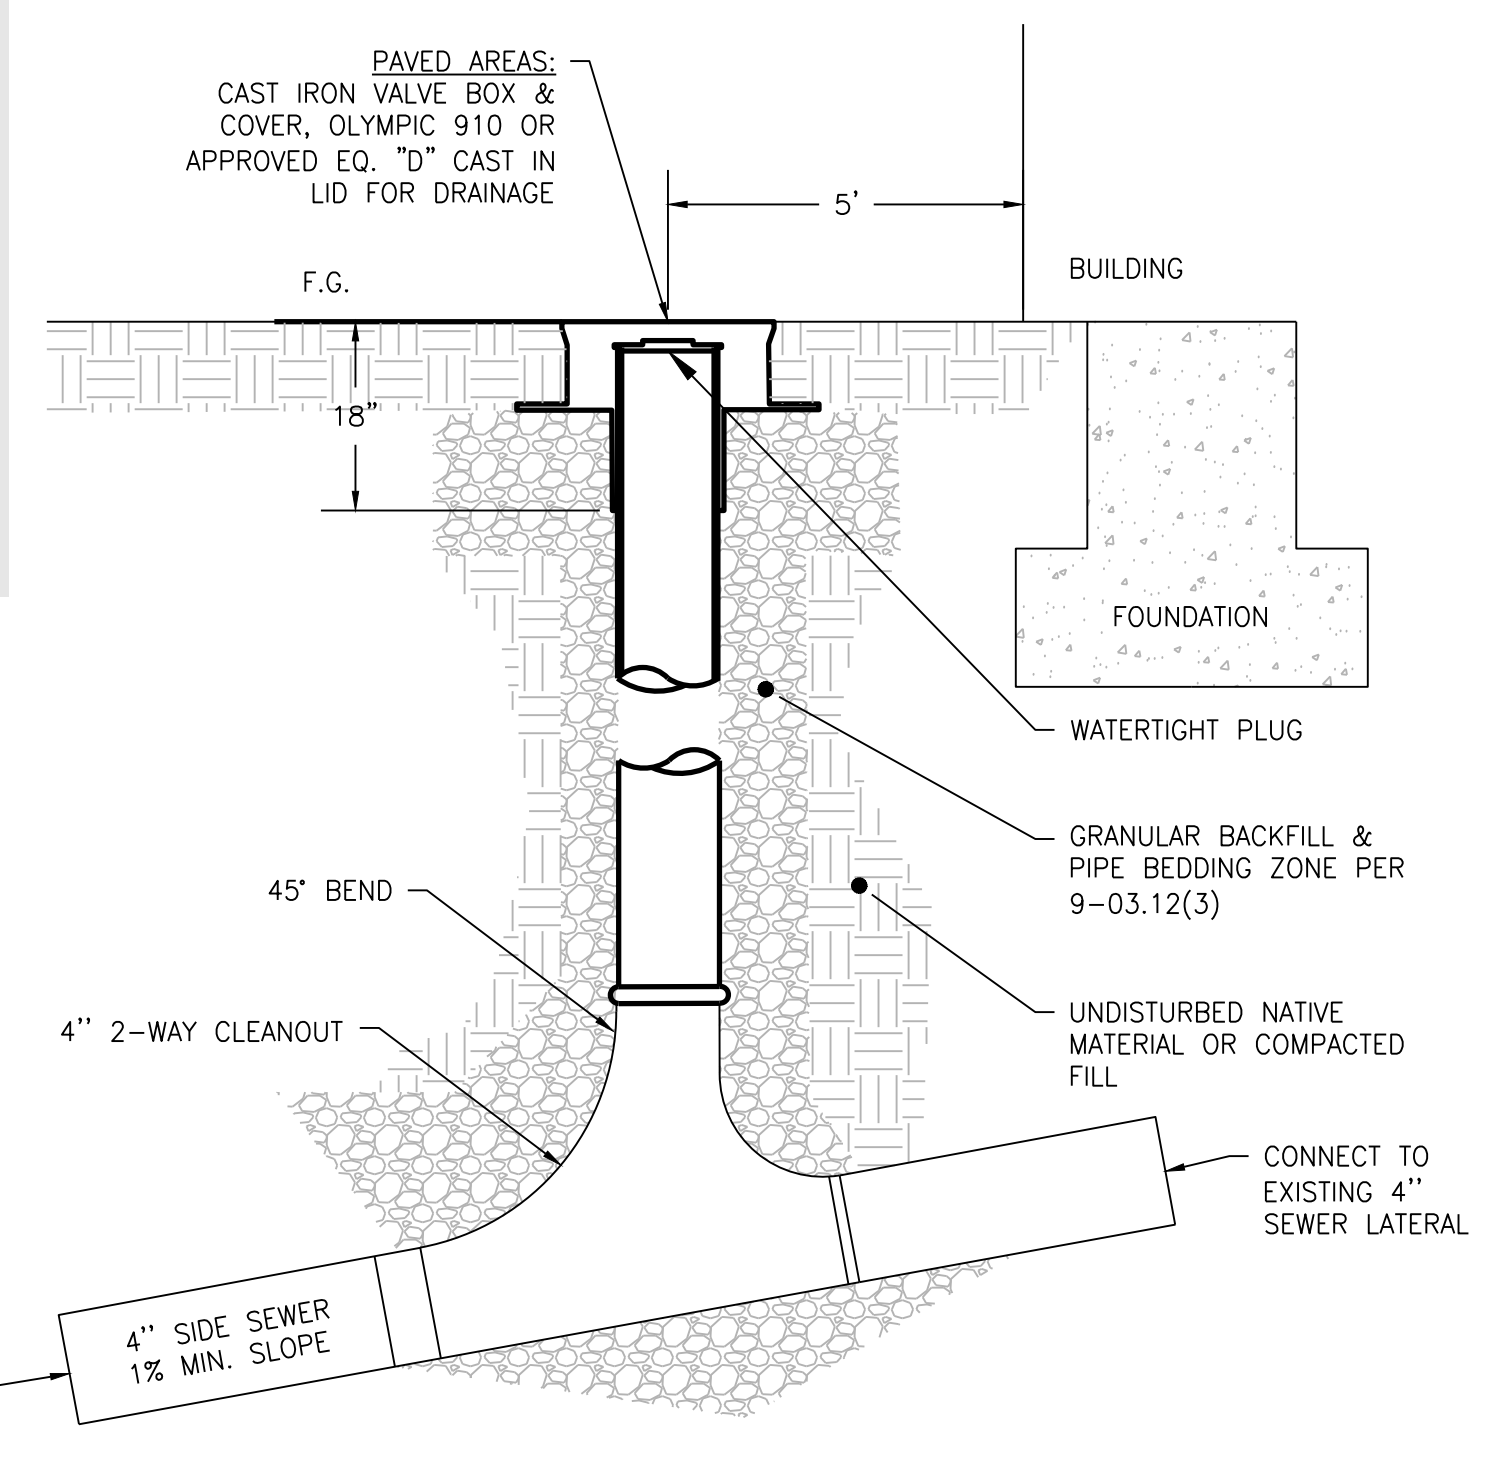
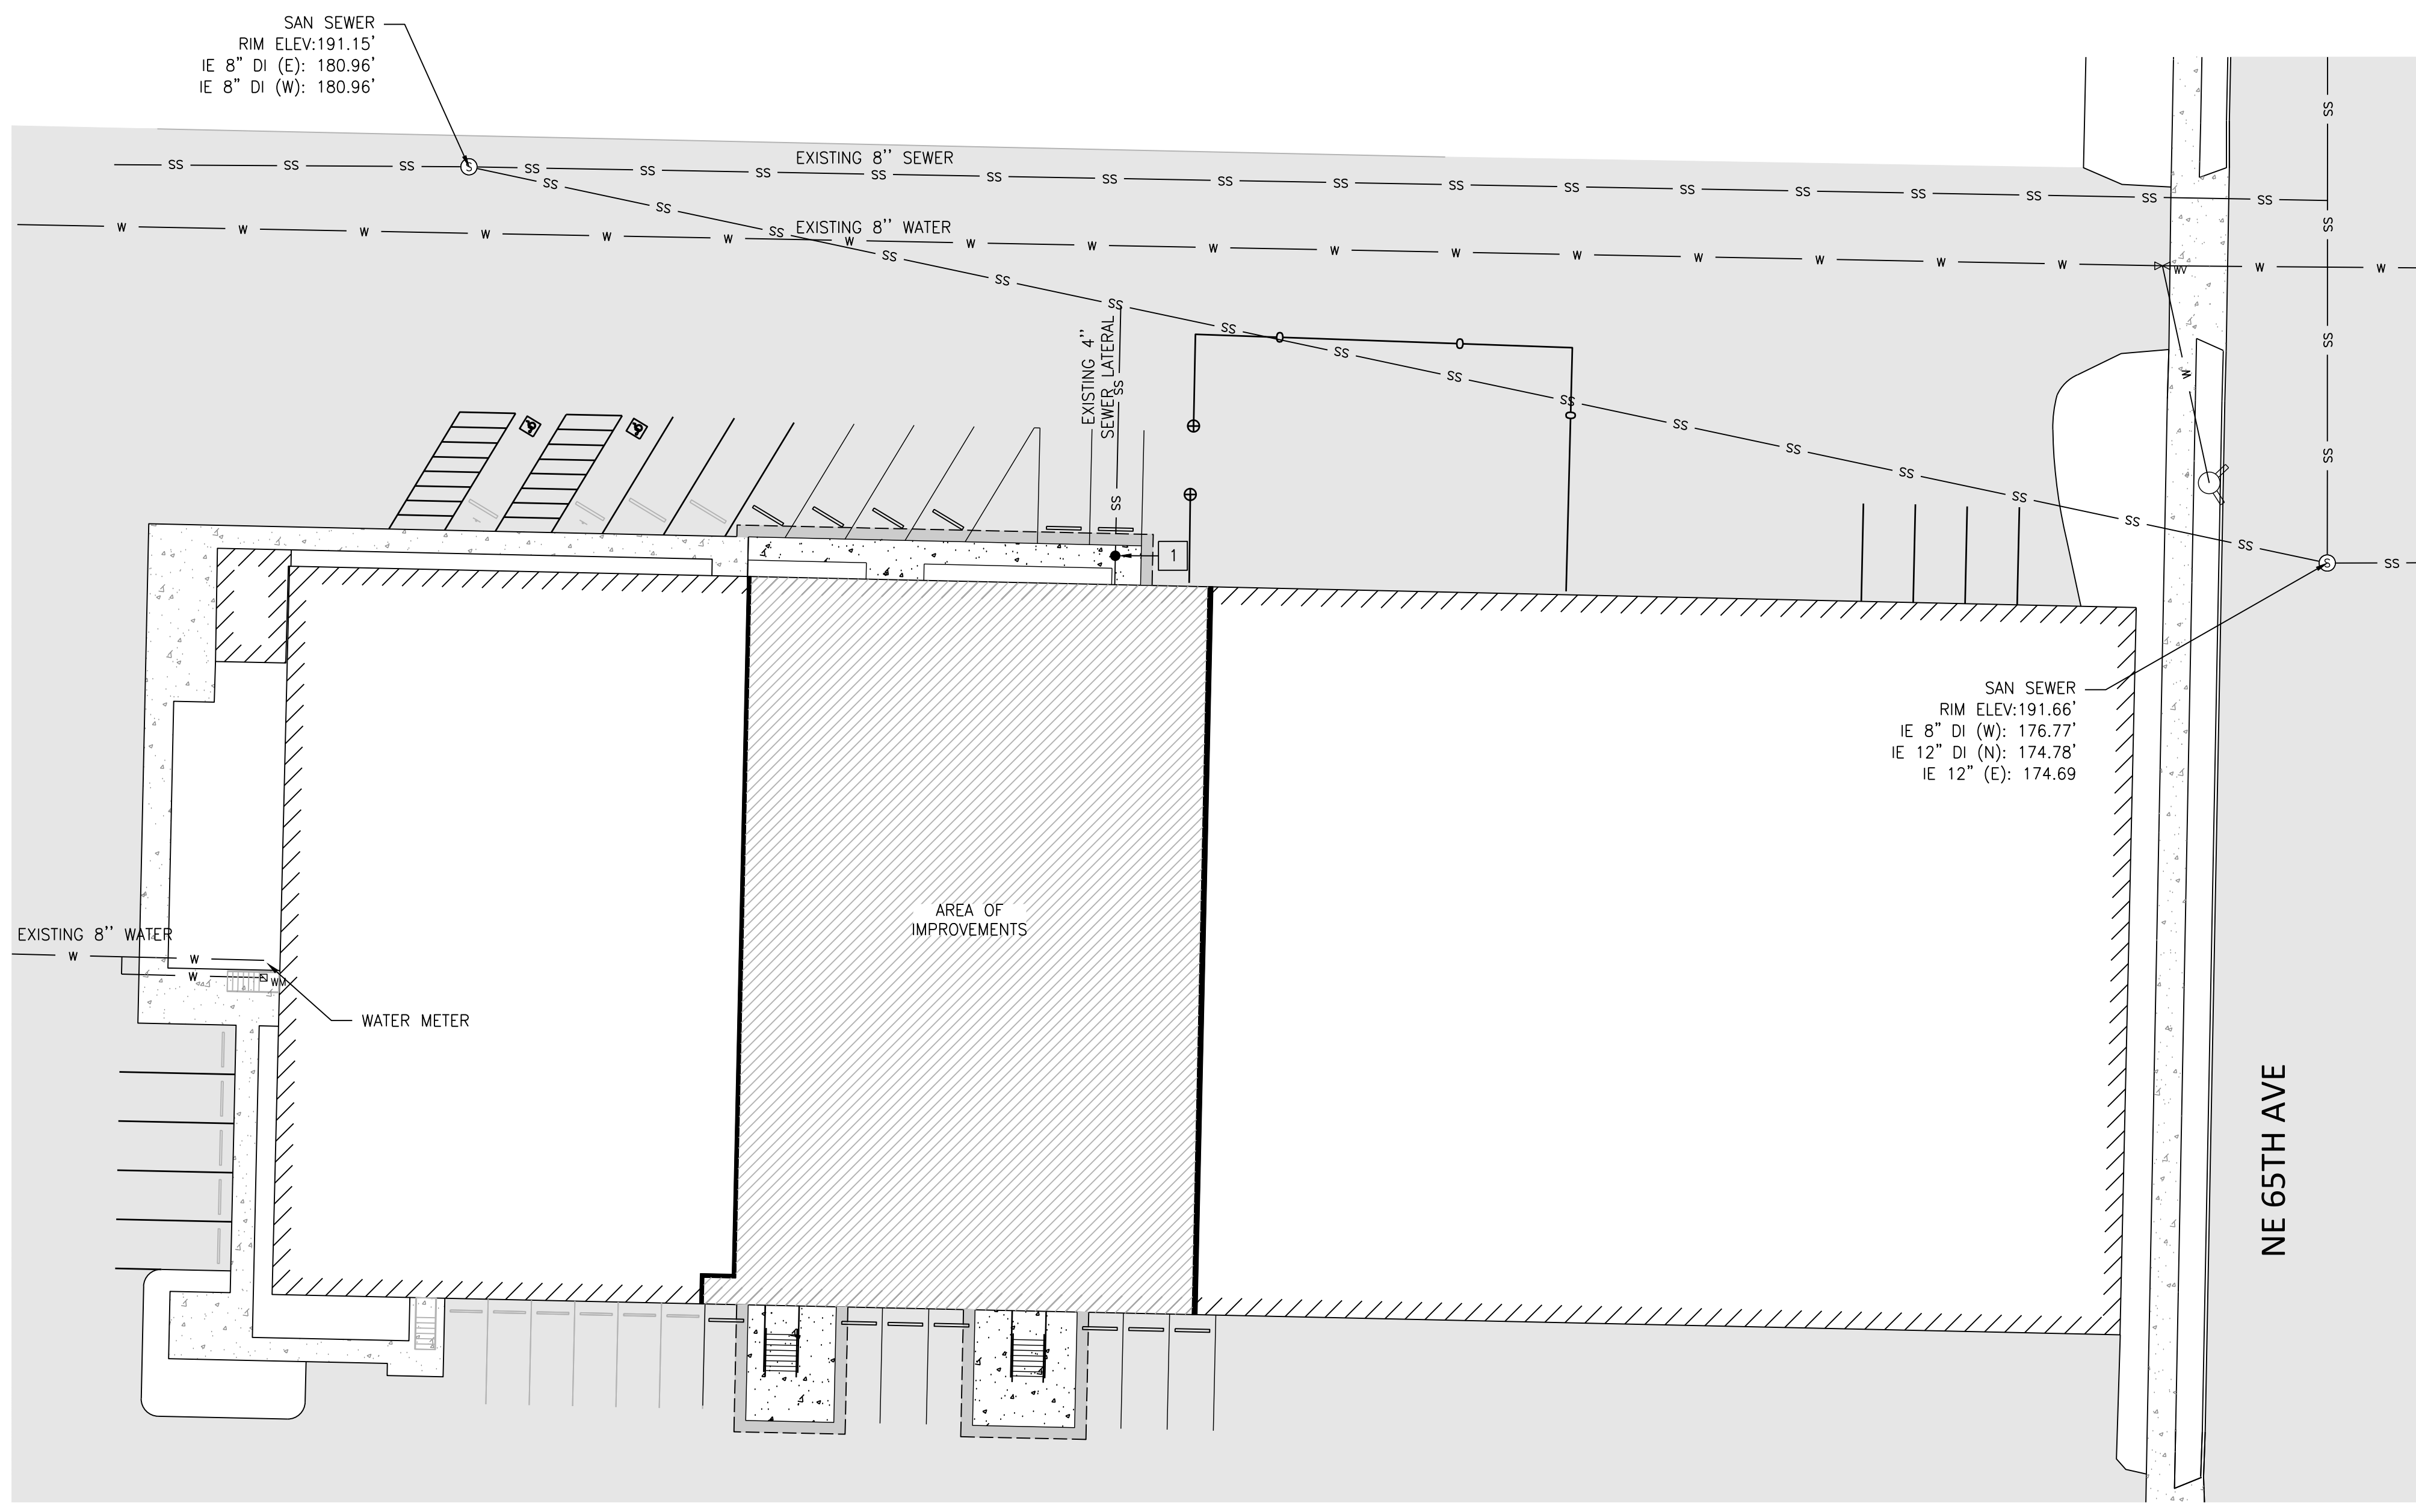


REVISED
9:21 am, Jan 22, 2024

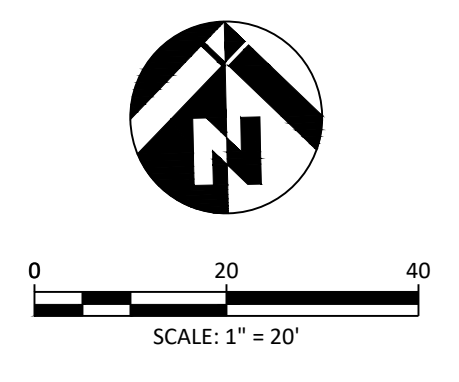

SEWER KEYNOTES

- 1 INSTALL 2-WAY COMMERCIAL SEWER CLEAN OUT PER DETAIL, THIS SHEET
- RIM= 191.05
- IE IN/OUT = MATCH EXISTING

1 2-WAY SEWER CLEANOUT
NO SCALE

FILE: W:\18009 ESD BLDG 2400\500 DESIGN\502 DRAWINGS\SHEETS\C300 UTILITY PLAN.DWG



REVISIONS:

JOB NO.:	18009
DATE:	4/19/2023
SCALE:	1" = 20'
DESIGNED BY:	PM
DRAWN BY:	PM
CHECKED BY:	DW